
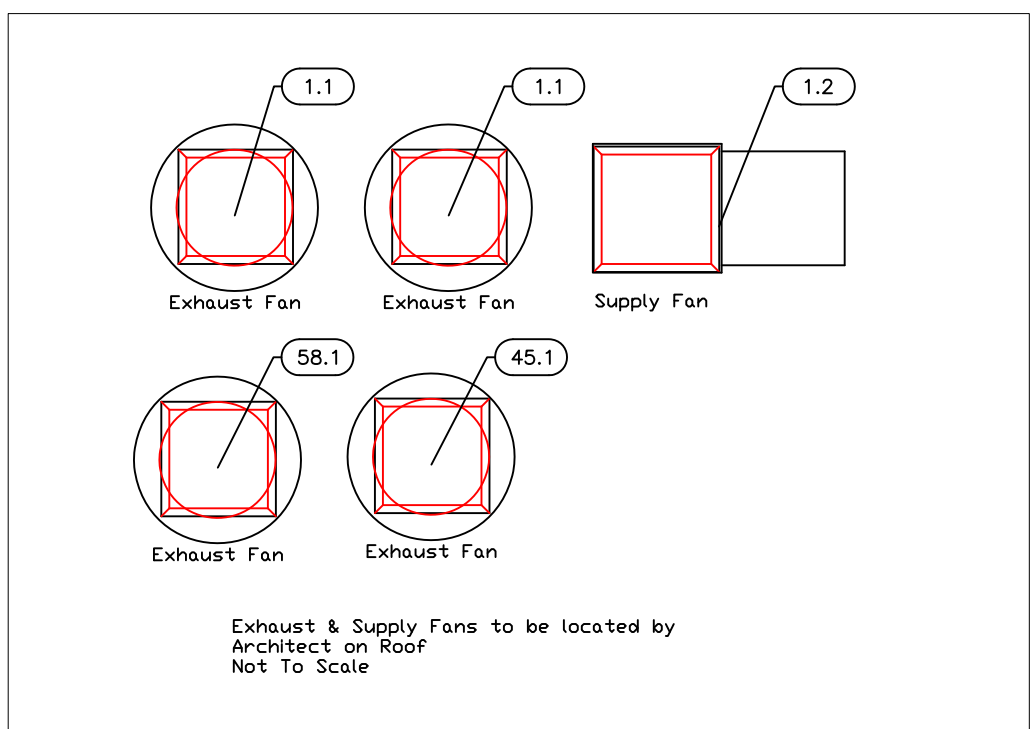
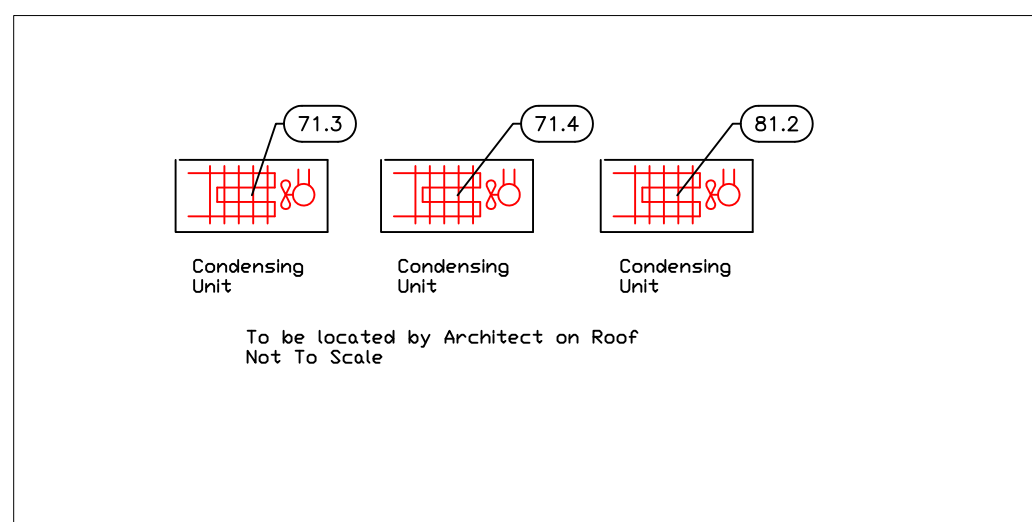


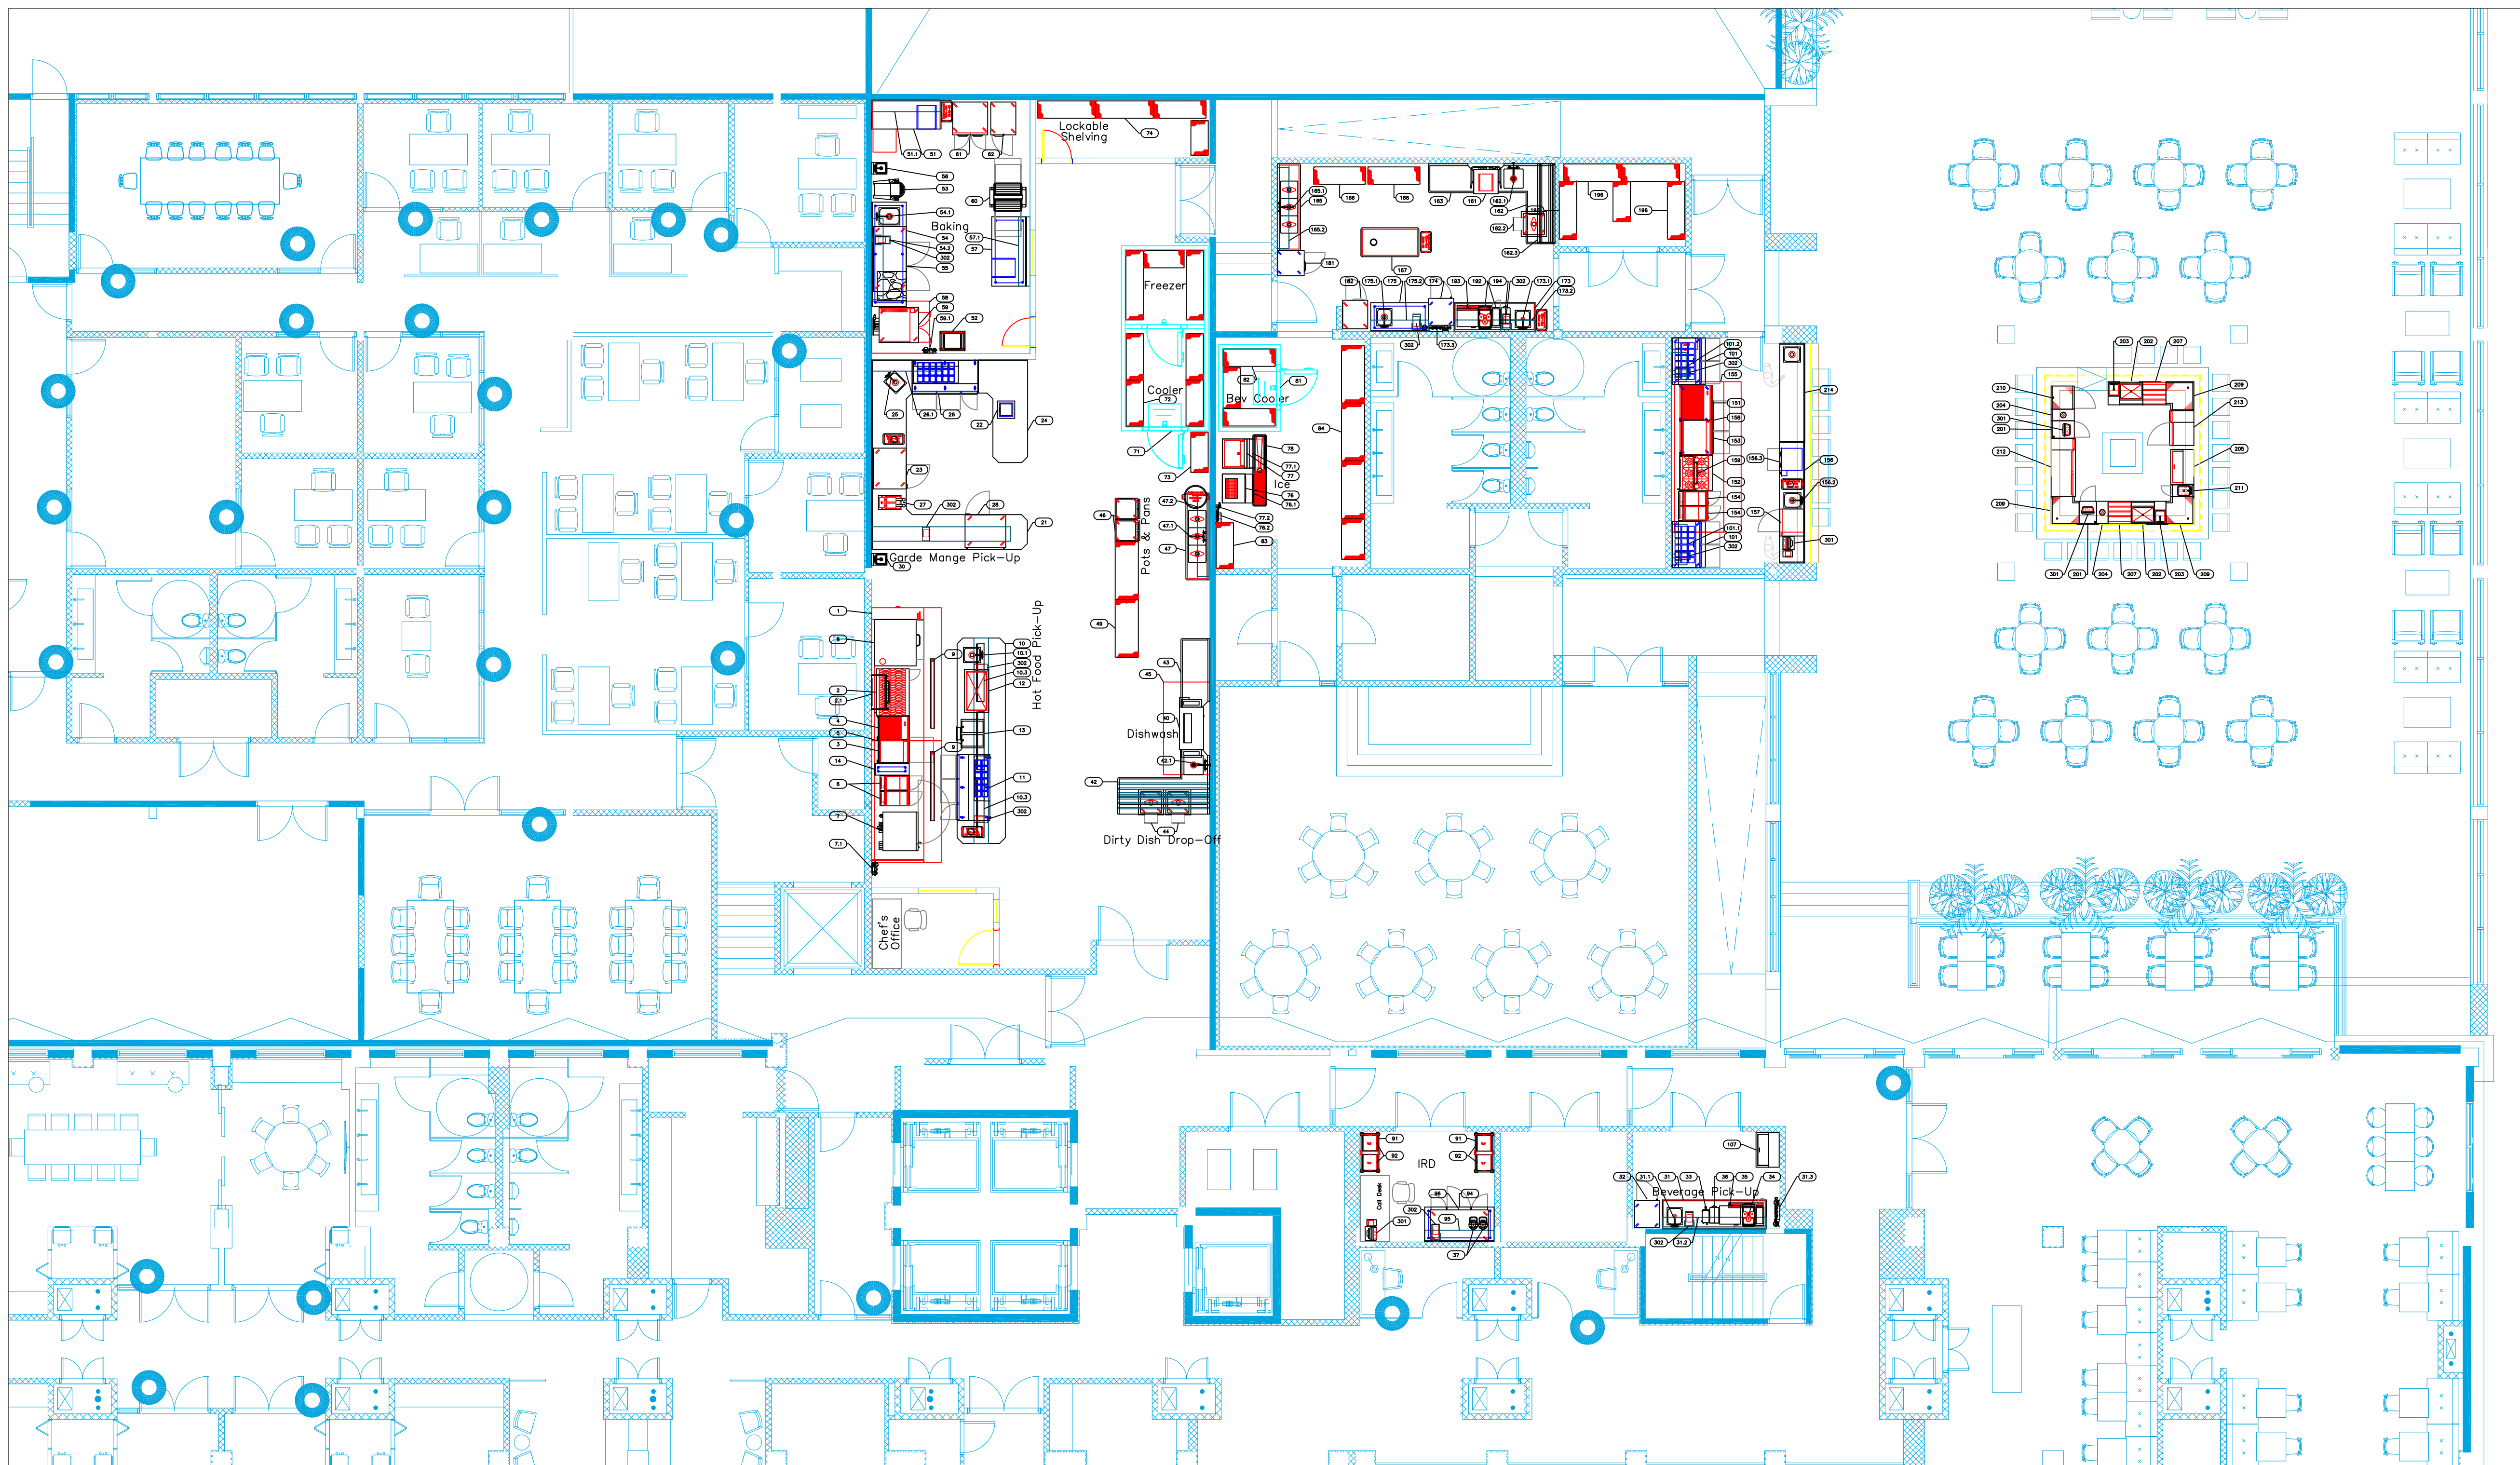

EQUIPMENT OVERVIEW

All Dimensions to be verified on the job site.
Actual locations for floor drains, and any ventilating equipment to be determined by Engineer.
Mechanical, Plumbing & Electrical to be checked and verified by Customers MEP Engineer.
Remote Condensing Units to be located by Architect.
Exhaust & Supply fans to be located by Architect.

Rok Hotel Kingston
Main & Outdoor Grill
Kingston, Jamaica

TAPESTRY
COLLECTION
BY HILTON™

uni-source
SUPPLY

INTERNATIONAL INC.



2055 W 73rd Street, Miami, FL 33016

Ph:(305)826-8696 Fax:(305)826-9131


8	Updated Background From Architect with Bar Change	6-24-20
9	Updated Background From Architect with Bar Change	10-29-20
10	Moved Garde Mange, Added Chef's office, New Bev Room	3-10-21
11	Added Back in MEP Information. Final	3-18-21
No.	Revision/Issue	Date

Date
March 18, 2021
Drawn By
Dayne Gauntlett
Scale
1/8" = 1'0"

Sheet
FF-0.0

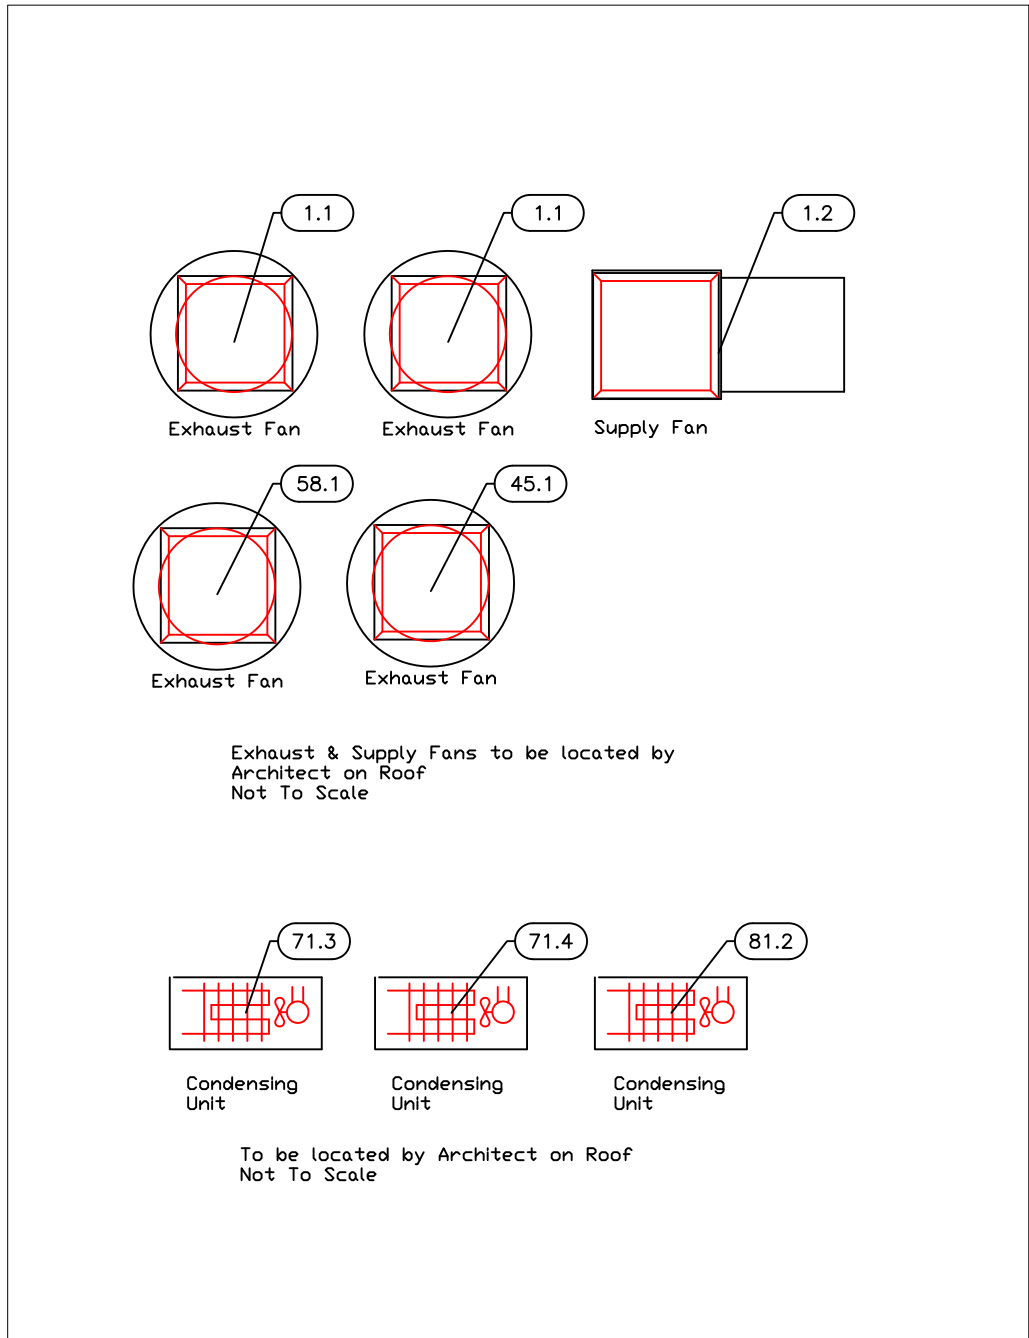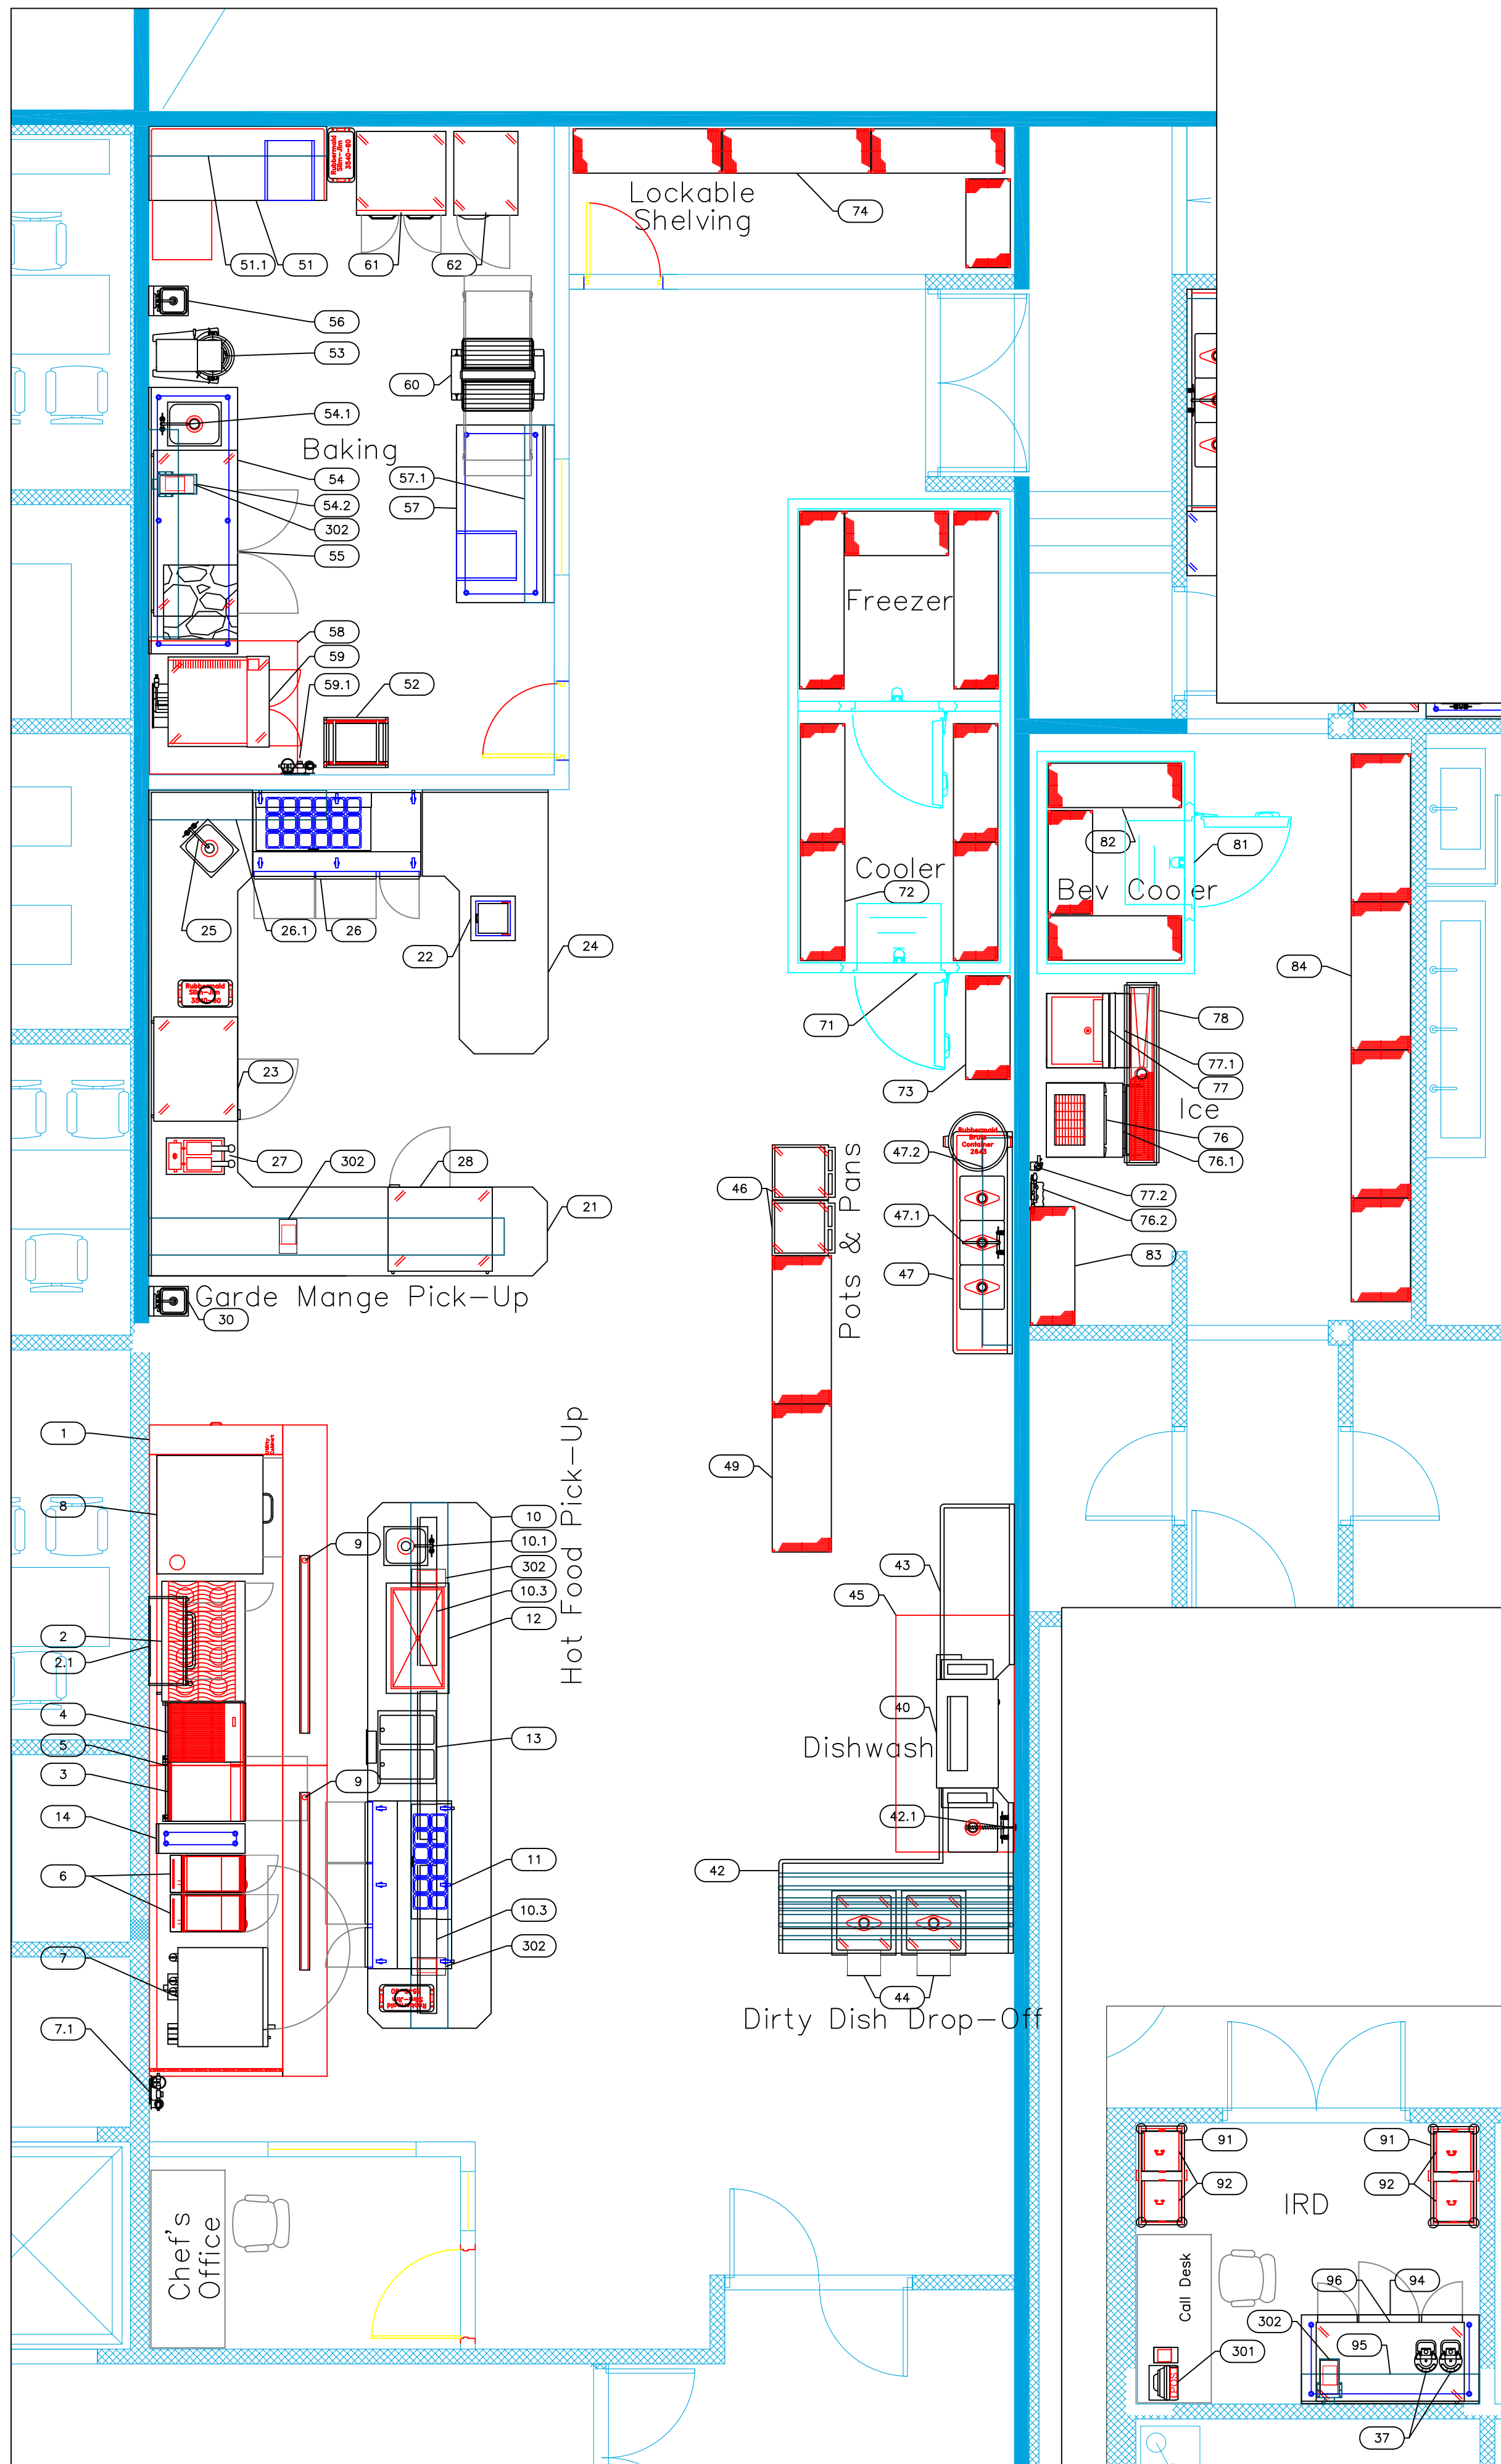

ItemNo	Category	Mfr	Model	Quantity	Equipment Remarks
1	Main Hood	Captive-Aire	HOOD - MAIN	1	
1.1	Exhaust Fan	Captive-Aire	E FAN - MAIN	2	
1.2	Supply Fan	Captive-Aire	S FAN - MAIN	1	
2	Range, 48" 8 Open Burners	Southbend	4482DC	1	
2.1	Salamander Broiler, Gas	Southbend	P36-AFR	1	
3	Gas Countertop Griddle	Southbend	HDC-24-M	1	
4	Charbroiler, Gas, Countertop	Southbend	HDC-24	1	
5	Equipment Stand, Refrigerated Base	Southbend	20048SB	1	
6	Gas Floor Fryer	Southbend	SB45S	2	
7	Combi Oven, Gas	Blodgett Combi	BCX-14G SGL	1	
7.1	Water Filtration System, for Steam Equipment	Everpure	EV979750	1	
8	Pizza Bake Oven, Deck-Type, Gas	Bakers Pride	252	1	
9	Drain, Floor Trough	Innox	F33893-9	2	
10	Chef's Table	Innox	F33893-10	1	
10.1	Deck Mount Faucet	Krowne	15-401L	1	
10.3	Heat Lamp	Nemco	6151-60	3	See Elevation
11	Sandwich / Salad Preparation Refrigerator	Continental Refrigerator	CRA68-12-D	1	
12	Cold Food Well Unit, Drop-In, Refrigerated	Wells	RCP-300	1	
13	Hot Food Well Unit, Drop-In, Electric	Wells	MOD-200TDM	1	
14	Worktable	Innox	F33893-14	1	
21	Island Counter	Innox	F33893-21	1	
22	Ice Cream Dispensing Cabinet	Glastender	DHFR	1	
23	Reach-In Undercounter Freezer	Continental Refrigerator	CFA43-U	1	
24	Garge Marge Side Counter	Innox	F33893-24	1	
25	Deck Mount Faucet	Krowne	15-410L	1	
26	Mega Top Sandwich / Salad Preparation Refrigerator	Continental Refrigerator	CRA68-18MD	1	
26.1	Shelving, Wall Mounted	Advance Tabco	WS-12-72	1	
27	Electric Drop-In Fryer	Wells	F-556	1	
28	Undercounter Refrigerator	Continental Refrigerator	RA43N-U	1	
30	Hand Sink	Advance Tabco	7-PS-56	1	
31	Beverage Counter	Innox	F33893-31	1	
31.1	Wall / Splash Mount Faucet	Krowne	14-401L	1	
31.2	Shelving, Wall Mounted	Advance Tabco	WS-12-108	1	
	Shelving, Wall Mounted	Advance Tabco	WS-12-36	1	
31.3	Water Filtration System, for Multiple Applications	Everpure	EV932806	1	
32	Reach-In Refrigerator	Continental Refrigerator	1RSN5SGDHD	1	
33	Hot Water Dispenser	BUNN	43600.0003	1	
34	Espresso Cappuccino Machine	WMF	03.1900.0412	1	By Owner/Operator
	Milk, Chiller	WMF	03.9192.3001	1	By Owner/Operator
35	Coffee Brewer	BUNN	34600.0000	1	
36	Coffee Grinder	BUNN	35600.0022	1	
37	Thermal Server Parts/Accessories	BUNN	39795.0003	2	
40	Dishwasher, Conveyor Type	Jackson VWS	AJX-44CE	1	
42	Dishable, Soiled "L" Shaped	Advance Tabco	DTS-D70-96R	1	
42.1	Pra-Rinse Faucet Assembly	Krowne	17-108W/L	1	
43	Clean Dishable	Advance Tabco	DTC-370-72L	1	
44	Soak Sink	Advance Tabco	9-FSC-20	2	
45	Exhaust Hood	Captive-Aire	DISH HOOD	1	
45.1	Exhaust Fan	Captive-Aire	FAN D	1	
46	Rack Dolly	Cambro	CD2020H401	2	
47	Three (3) Compartment Sink	Advance Tabco	FC-3-1818-18RL	1	
47.1	Wall / Splash Mount Faucet	Krowne	14-814L	1	
47.2	Overshelf	Advance Tabco	PS-12-84	1	
49	Wire Shelving Unit	NEXEL	24606N	2	
51	Work Table, Bakers Top	Advance Tabco	BS1-306L	1	
51.1	Shelving, Wall Mounted	Advance Tabco	WS-12-72	1	
52	Bun / Sheet Pan Rack	Advance Tabco	PR20-3W	1	
53	Planetary Mixer	Univex	SRM40+	1	
54	Work Table, Stainless Steel Top	Innox	F33893-54	1	
54.1	Deck Mount Faucet	Krowne	15-410L	1	
54.2	Shelving, Wall Mounted	Advance Tabco	WS-12-84	1	
55	Undercounter Refrigerator	Continental Refrigerator	RA68N-U	1	
56	Hand Sink	Advance Tabco	7-PS-56	1	
57	Work Table, Stainless Steel Top	Innox	F33893-57	1	
57.1	Shelving, Wall Mounted	Advance Tabco	WS-12-72	1	
58	Exhaust Hood	Captive-Aire	HOOD - BAKE	1	
58.1	Exhaust Fan	Captive-Aire	E FAN - BAKE	1	
59	Convection Oven / Proofer, Electric	Doyon	JAOP6	1	
59.1	Water Filtration System, for Steam Equipment	Everpure	EV979750	1	
60	Dough Sheeter	Univex	SFG 500 TM	1	
61	Reach-In Refrigerator	Continental Refrigerator	2RSEN	1	
62	Reach-In Freezer	Continental Refrigerator	1FN	1	
71	Walk-In Combo	Arctic Industries	CUSTOM	1	
71.1	Evaporator for Cooler	Arctic Industries	EVAP	1	
71.2	Evaporator for Freezer	Arctic Industries	EVAP	1	
71.3	Remote Condenser Unit for Cooler	Arctic Industries	COND	1	
71.4	Remote Condenser Unit for Freezer	Arctic Industries	COND	1	
72	Wire Shelving Unit	NEXEL	18486N	4	
73	Wire Shelving Unit	NEXEL	18426N	1	
74	Wire Shelving Unit	NEXEL	18606N	2	
76	Ice Maker, Cube-Style	Ice-O-Matic	CM1136FA	1	
76.1	Ice Bin for Ice Machines	Follett	SG700S-30	1	
76.2	Water Filtration System, for Ice Machines	Everpure	EV932402	1	
77	Ice Maker, Cube-Style	Kold-Draft	GT367AC	1	
77.1	Ice Bin for Ice Machines	Kold-Draft	KDB400	1	
77.2	Water Filtration System, for Ice Machines	Everpure	EV932401	1	
78	Drain, Floor Trough	Innox	F33893-78	1	
81	Walk-In Bev Cooler	Arctic Industries	CUSTOM	1	
81.1	Evaporator for Cooler	Arctic Industries	EVAP	1	
81.2	Remote Condenser Unit for Cooler	Arctic Industries	COND	1	
82	Wire Shelving Unit	NEXEL	18426N	1	
83	Wire Shelving Unit	NEXEL	18486N	1	
84	Wire Shelving Unit	NEXEL	24608N5	3	
91	Dolly Cart	SICO	3909-100XXX	2	
92	Cabinet, Hand Lift	SICO	4918-700X	4	
93	Room Service Table	SICO	TR882F-SEX02BG	4	
94	Work Table, Stainless Steel Top	Advance Tabco	TKMS-366	1	
95	Shelving, Wall Mounted	Advance Tabco	WS-12-72	1	
96	Undercounter Refrigerator	Continental Refrigerator	RA60N-U	1	

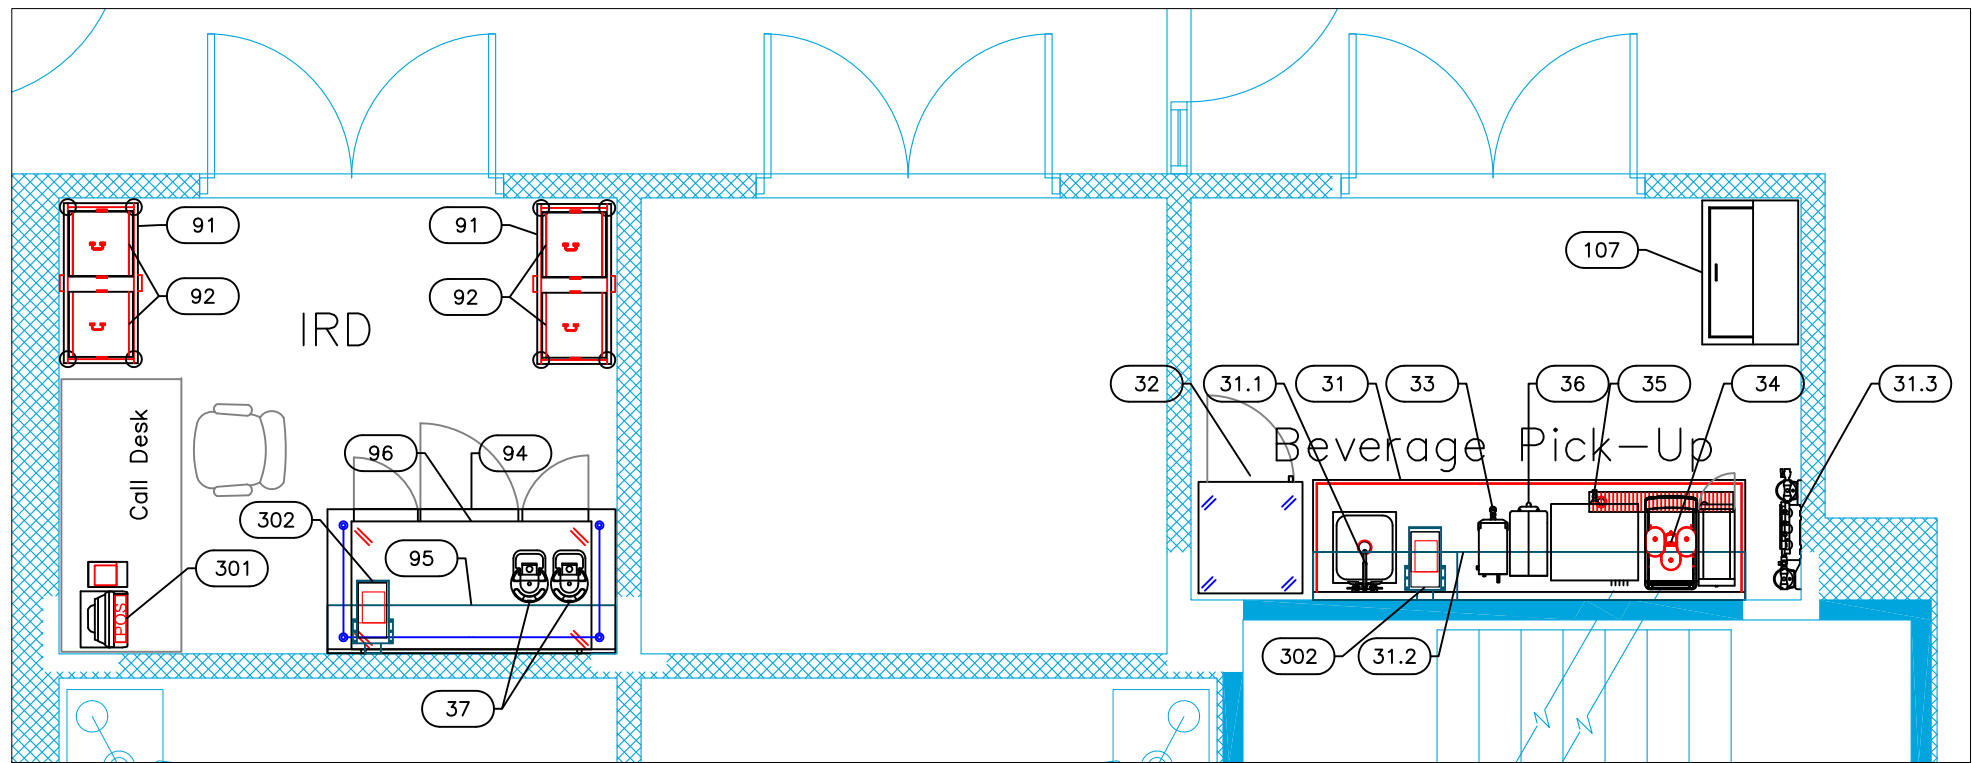

EQUIPMENT LAYOUT

All Dimensions to be verified on the job site. Actual locations for floor drains, and any ventilating equipment to be determined by Engineer. Mechanical, Plumbing & Electrical to be checked and verified by Customers MEP Engineer. Remote Condensing Units to be located by Architect. Exhaust & Supply fans to be located by Architect.

Rok Hotel Kingston
Main Kitchen
Kingston, Jamaica

TAPESTRY COLLECTION
BY HILTON

uni-source
SUPPLY

INTERNATIONAL INC.



2055 W 73rd Street, Miami, FL 33016

Ph: (305)826-8696 Fax: (305)826-9131


8	Updated Background From Architect with Bar Change	6-24-20
9	Updated Background From Architect with Bar Change	10-29-20
10	Moved Garde Marge, Added Chef's office, New Bev Room	3-10-21
11	Added Back in MEP Information. Final	3-18-21
No.	Revision/Issue	Date

Date
March 18, 2021
Drawn By
Dayne Gauntlett
Scale
1/4" = 1'0"

Sheet
FF-1.0

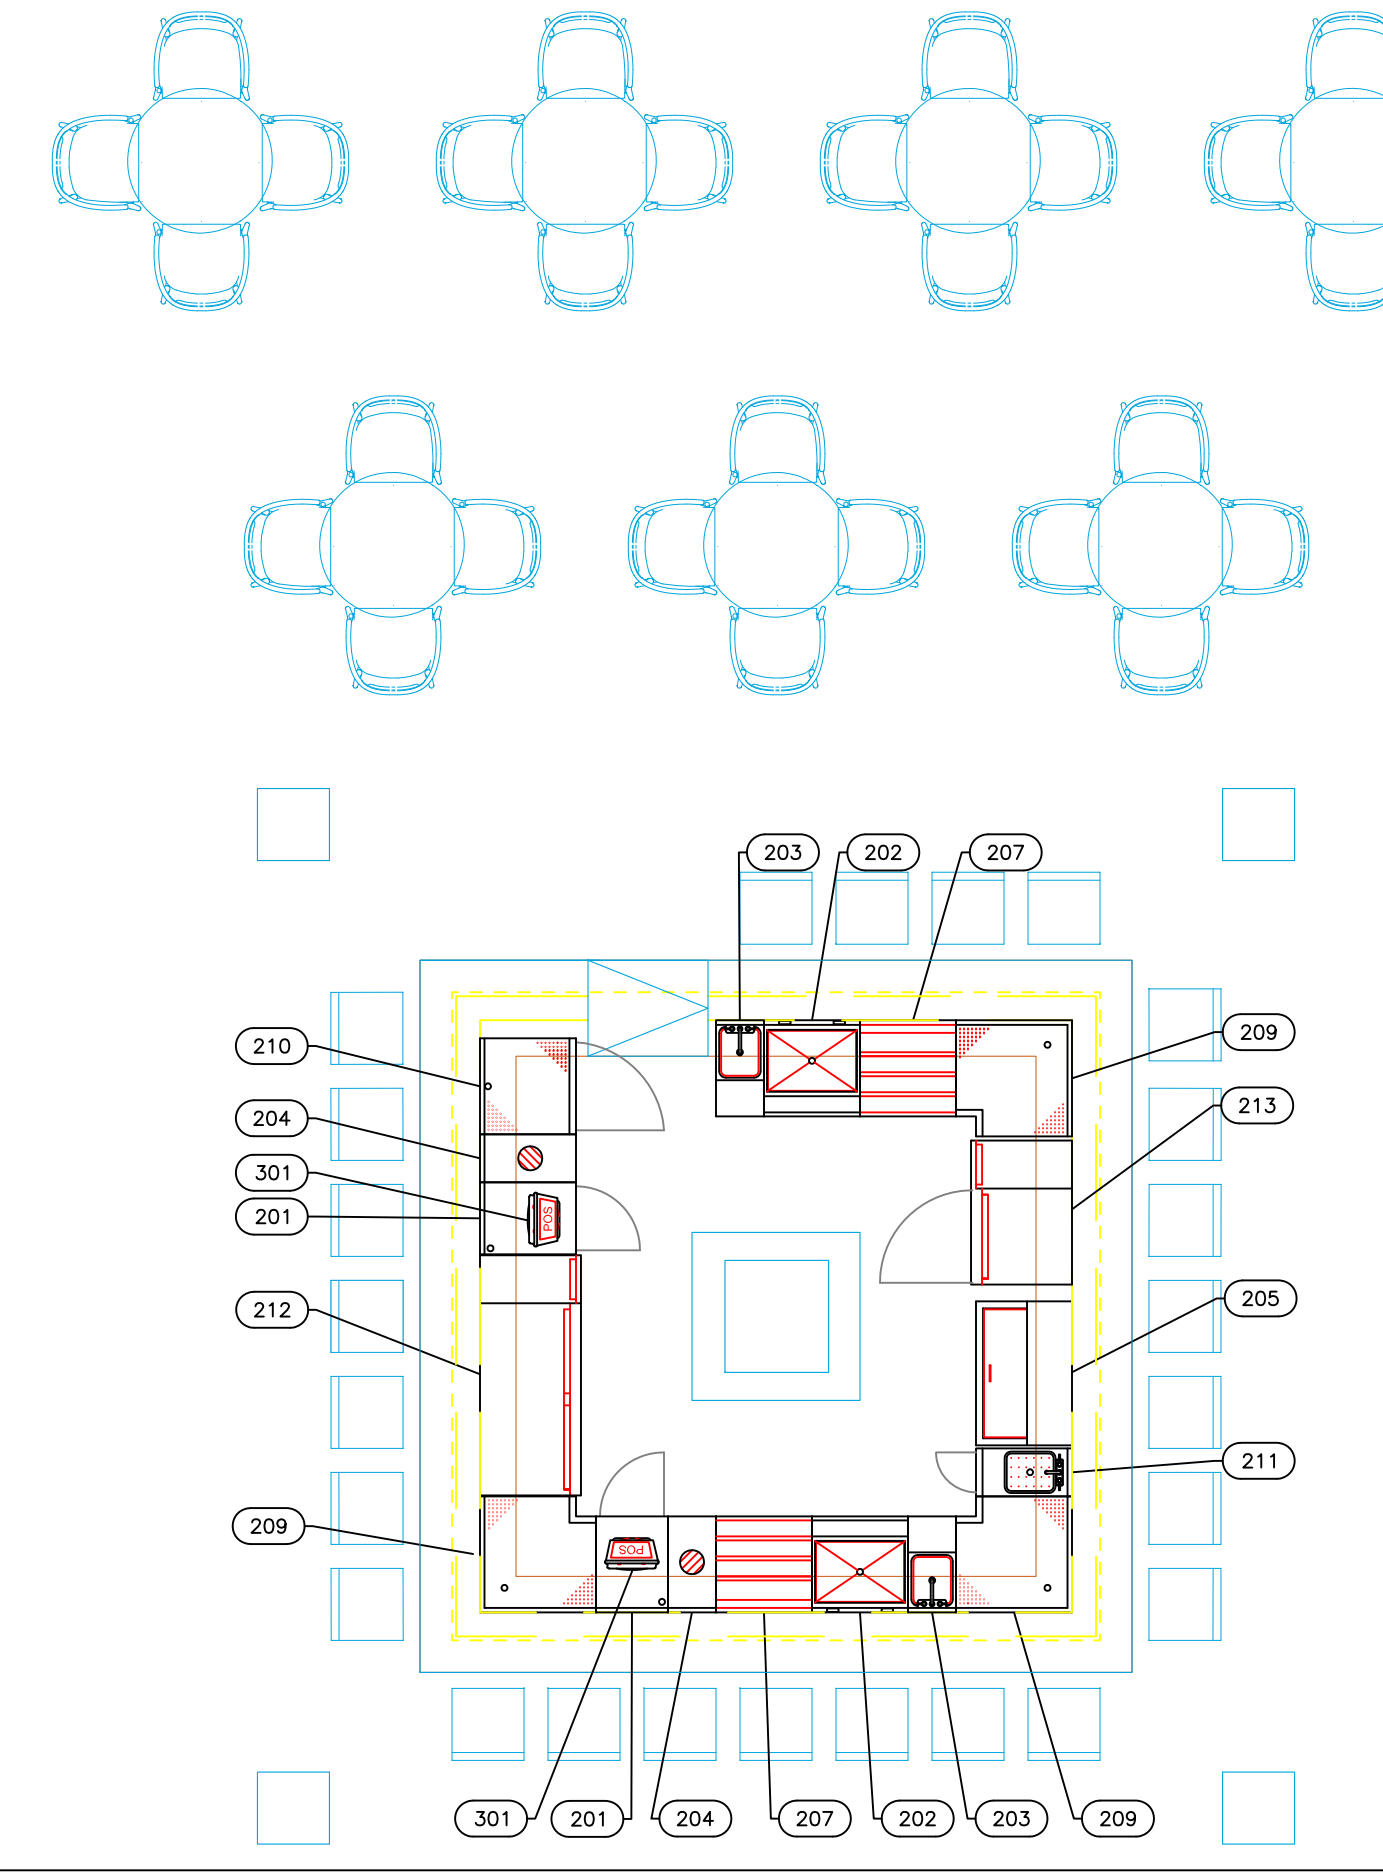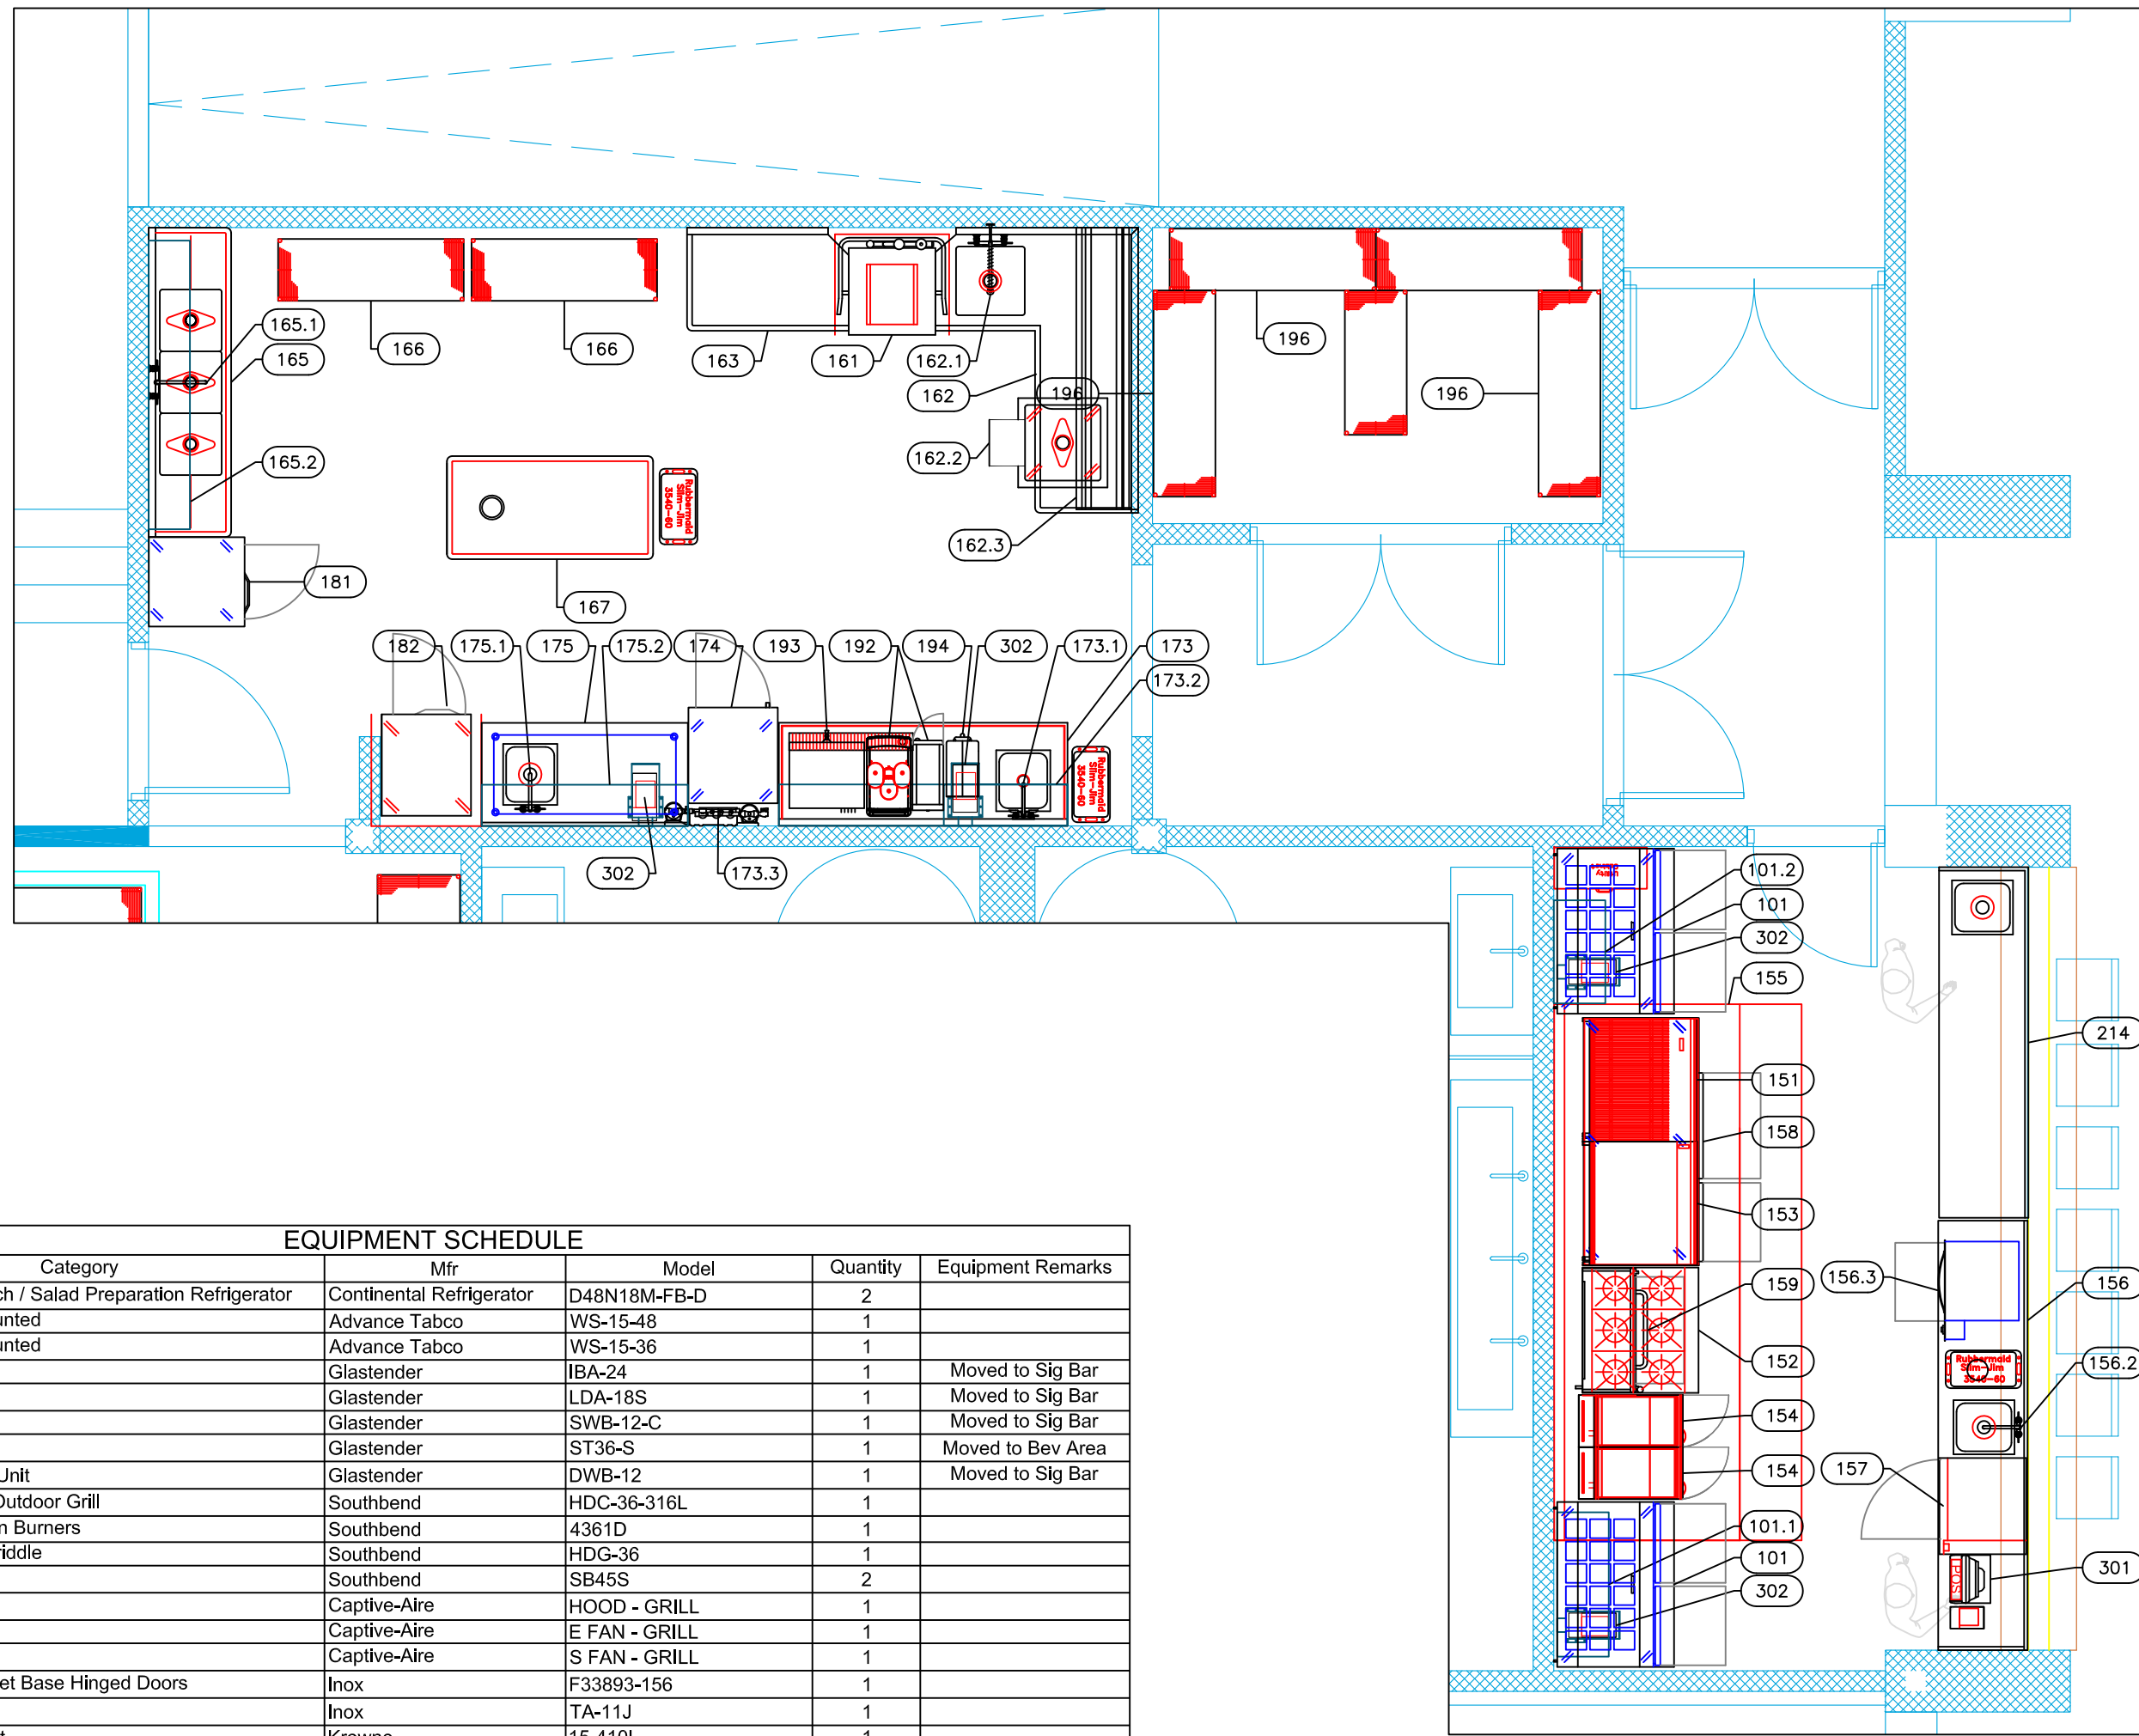

EQUIPMENT SCHEDULE					
ItemNo	Category	Mfr	Model	Quantity	Equipment Remarks
101	Mega Top Sandwich / Salad Preparation Refrigerator	Continental Refrigerator	D48N18MFB-D	2	
101.1	Shelving, Wall Mounted	Advance Tabco	WS-15-48	1	
101.2	Shelving, Wall Mounted	Advance Tabco	WS-15-36	1	
104	Ice Bin	Glastender	IBA-24	1	Moved to Sig Bar
105	Bottle Storage Unit	Glastender	LDA-18S	1	Moved to Sig Bar
106	Waste Cabinet	Glastender	SWB-12-C	1	Moved to Sig Bar
107	Bottle Cooler	Glastender	ST36-S	1	Moved to Bev Area
108	Underbar Add-On Unit	Glastender	DWB-12	1	Moved to Sig Bar
151	Charbroiler, Gas, Outdoor Grill	Southbend	HDC-36-316L	1	
152	Range, 36" 6 Open Burners	Southbend	4361D	1	
153	Gas Countertop Griddle	Southbend	HDG-36	1	
154	Gas Floor Fryer	Southbend	SB45S	2	
155	Grill Hood	Captive-Aire	HOOD - GRILL	1	
155.1	Exhaust Fan	Captive-Aire	E FAN - GRILL	1	
155.2	Supply Fan	Captive-Aire	S FAN - GRILL	1	
156	Work Table, Cabinet Base Hinged Doors	Inox	F33893-156	1	
	Weld-In Sink	Inox	TA-11J	1	
156.2	Deck Mount Faucet	Krowne	15-410L	1	
156.3	Warming Drawer, Built-In	Wells	RW-26HD	1	
157	Glass Frontier	Glastender	F1SL28	1	
158	Equipment Stand, Refrigerated Base	Continental Refrigerator	D72GN	1	
159	Salamander Broiler, Gas	Southbend	P36-NFR	1	
161	Dishwasher, Door Type, Ventless	Jackson VWS	TEMPSTAR VENTLESS	1	
162	Dish Table, Soiled "L" Shaped	Advance Tabco	DTS-K70-84R	1	
162.1	Pre-Rinse Faucet Assembly	Krowne	17-108WL	1	
162.2	Soak Sink	Advance Tabco	9-FSC-20	1	
162.3	Dish Table Sorting Shelf	Advance Tabco	DT-6R-24	1	
163	Clean Dish Table	Advance Tabco	DTC-S30-48L	1	
165	Three (3) Compartment Sink	Advance Tabco	FC-3-1818-18RL	1	
165.1	Wall / Splash Mount Faucet	Krowne	14-814L	1	
165.2	Overshelf	Advance Tabco	PS-12-84	1	
166	Wire Shelving Unit	NEXEL	18546N	2	
167	Dish Table Sorting Table	Advance Tabco	SR-60	1	
173	Beverage Counter	Advance Tabco	BEV-30-84L	1	
173.1	Wall / Splash Mount Faucet	Krowne	14-408L	1	
173.2	Shelving, Wall Mounted	Advance Tabco	WS-12-84	1	
173.3	Water Filtration System, for Multiple Applications	Everpure	EV932806	1	
174	Reach-In Display Refrigerator, 1 section	Continental Refrigerator	D1RSNSSGDHD	1	
175	Work Table, Stainless Steel Top	Advance Tabco	KMS-305	1	
	Weld-In Sink	Advance Tabco	TA-11J	1	
175.1	Deck Mount Faucet	Krowne	15-410L	1	
175.2	Shelving, Wall Mounted	Advance Tabco	WS-12-60	1	
181	Reach-In Refrigerator	Continental Refrigerator	1RSN	1	
182	Reach-In Freezer	Continental Refrigerator	1FSN	1	
192	Espresso Cappuccino Machine	WMF	03.1900.0412	1	By Owner/Operator
	Milk Chiller	WMF	03.9192.3001	1	By Owner/Operator
193	Coffee Brewer	BUNN	34600.0000	1	
194	Coffee Grinder	BUNN	35600.0022	1	
196	Wire Shelving Unit	NEXEL	18606N	4	
201	Work Center	Glastender	PCB-18	2	
202	Ice Bin	Glastender	IBA-24	2	
203	Blender Station	Glastender	BSA-12	2	
204	Underbar Add-On Unit	Glastender	DWB-12	2	
205	Bottle Cooler	Glastender	ST36-S	1	
207	Bottle Storage Unit	Glastender	LDA-24S	2	
209	Corner Angle Filler	Glastender	JFCB-90	3	
210	Drainboard	Glastender	DBC-24	1	
211	Waste Cabinet	Glastender	SWB-12-C	1	
212	Back Bar Cabinet, Refrigerated	Glastender	C1FL60	1	
213	Back Bar Cabinet, Refrigerated	Glastender	C1FL36	1	
214	Table	Emtec	TABLE	4	
301	POS System	POS	POS SYSTEM	4	
302	POS Printer	POS	POS PRINTER	10	

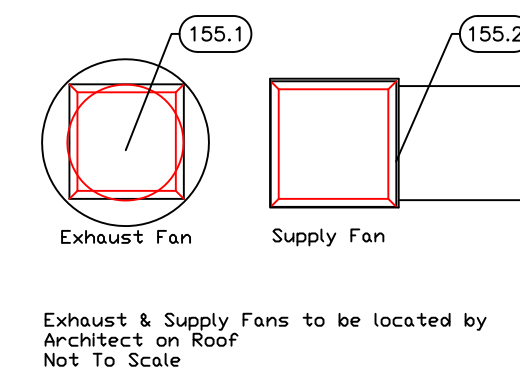

Exhaust & Supply Fans to be located by Architect on Roof Not To Scale

EQUIPMENT LAYOUT

All Dimensions to be verified on the job site.
Actual locations for floor drains, and any ventilating equipment to be determined by Engineer.
Mechanical, Plumbing & Electrical to be checked and verified by Customers MEP Engineer.
Remote Condensing Units to be located by Architect.
Exhaust & Supply fans to be located by Architect.

Rok Hotel Kingston Outdoor Bar & Grill Kingston, Jamaica

TAPESTRY
COLLECTION
BY HILTON™


uni-source
SUPPLY
INTERNATIONAL INC.

2055 W 73rd Street, Miami, FL 33016
Ph: (305)826-8696 Fax: (305)826-9131


8	Updated Background From Architect with Bar Change	6-24-20
9	Updated Background From Architect with Bar Change	10-29-20
10	Moved Garde Manger, Added Chef's office, New Bev Room	3-10-21
11	Added Back in MEP Information. Final	3-18-21
No.	Revision/Issue	Date

Date
March 18, 2021
Drawn By
Dayne Gauntlett
Scale
1/4" = 1'0"

Sheet
FF-1.1

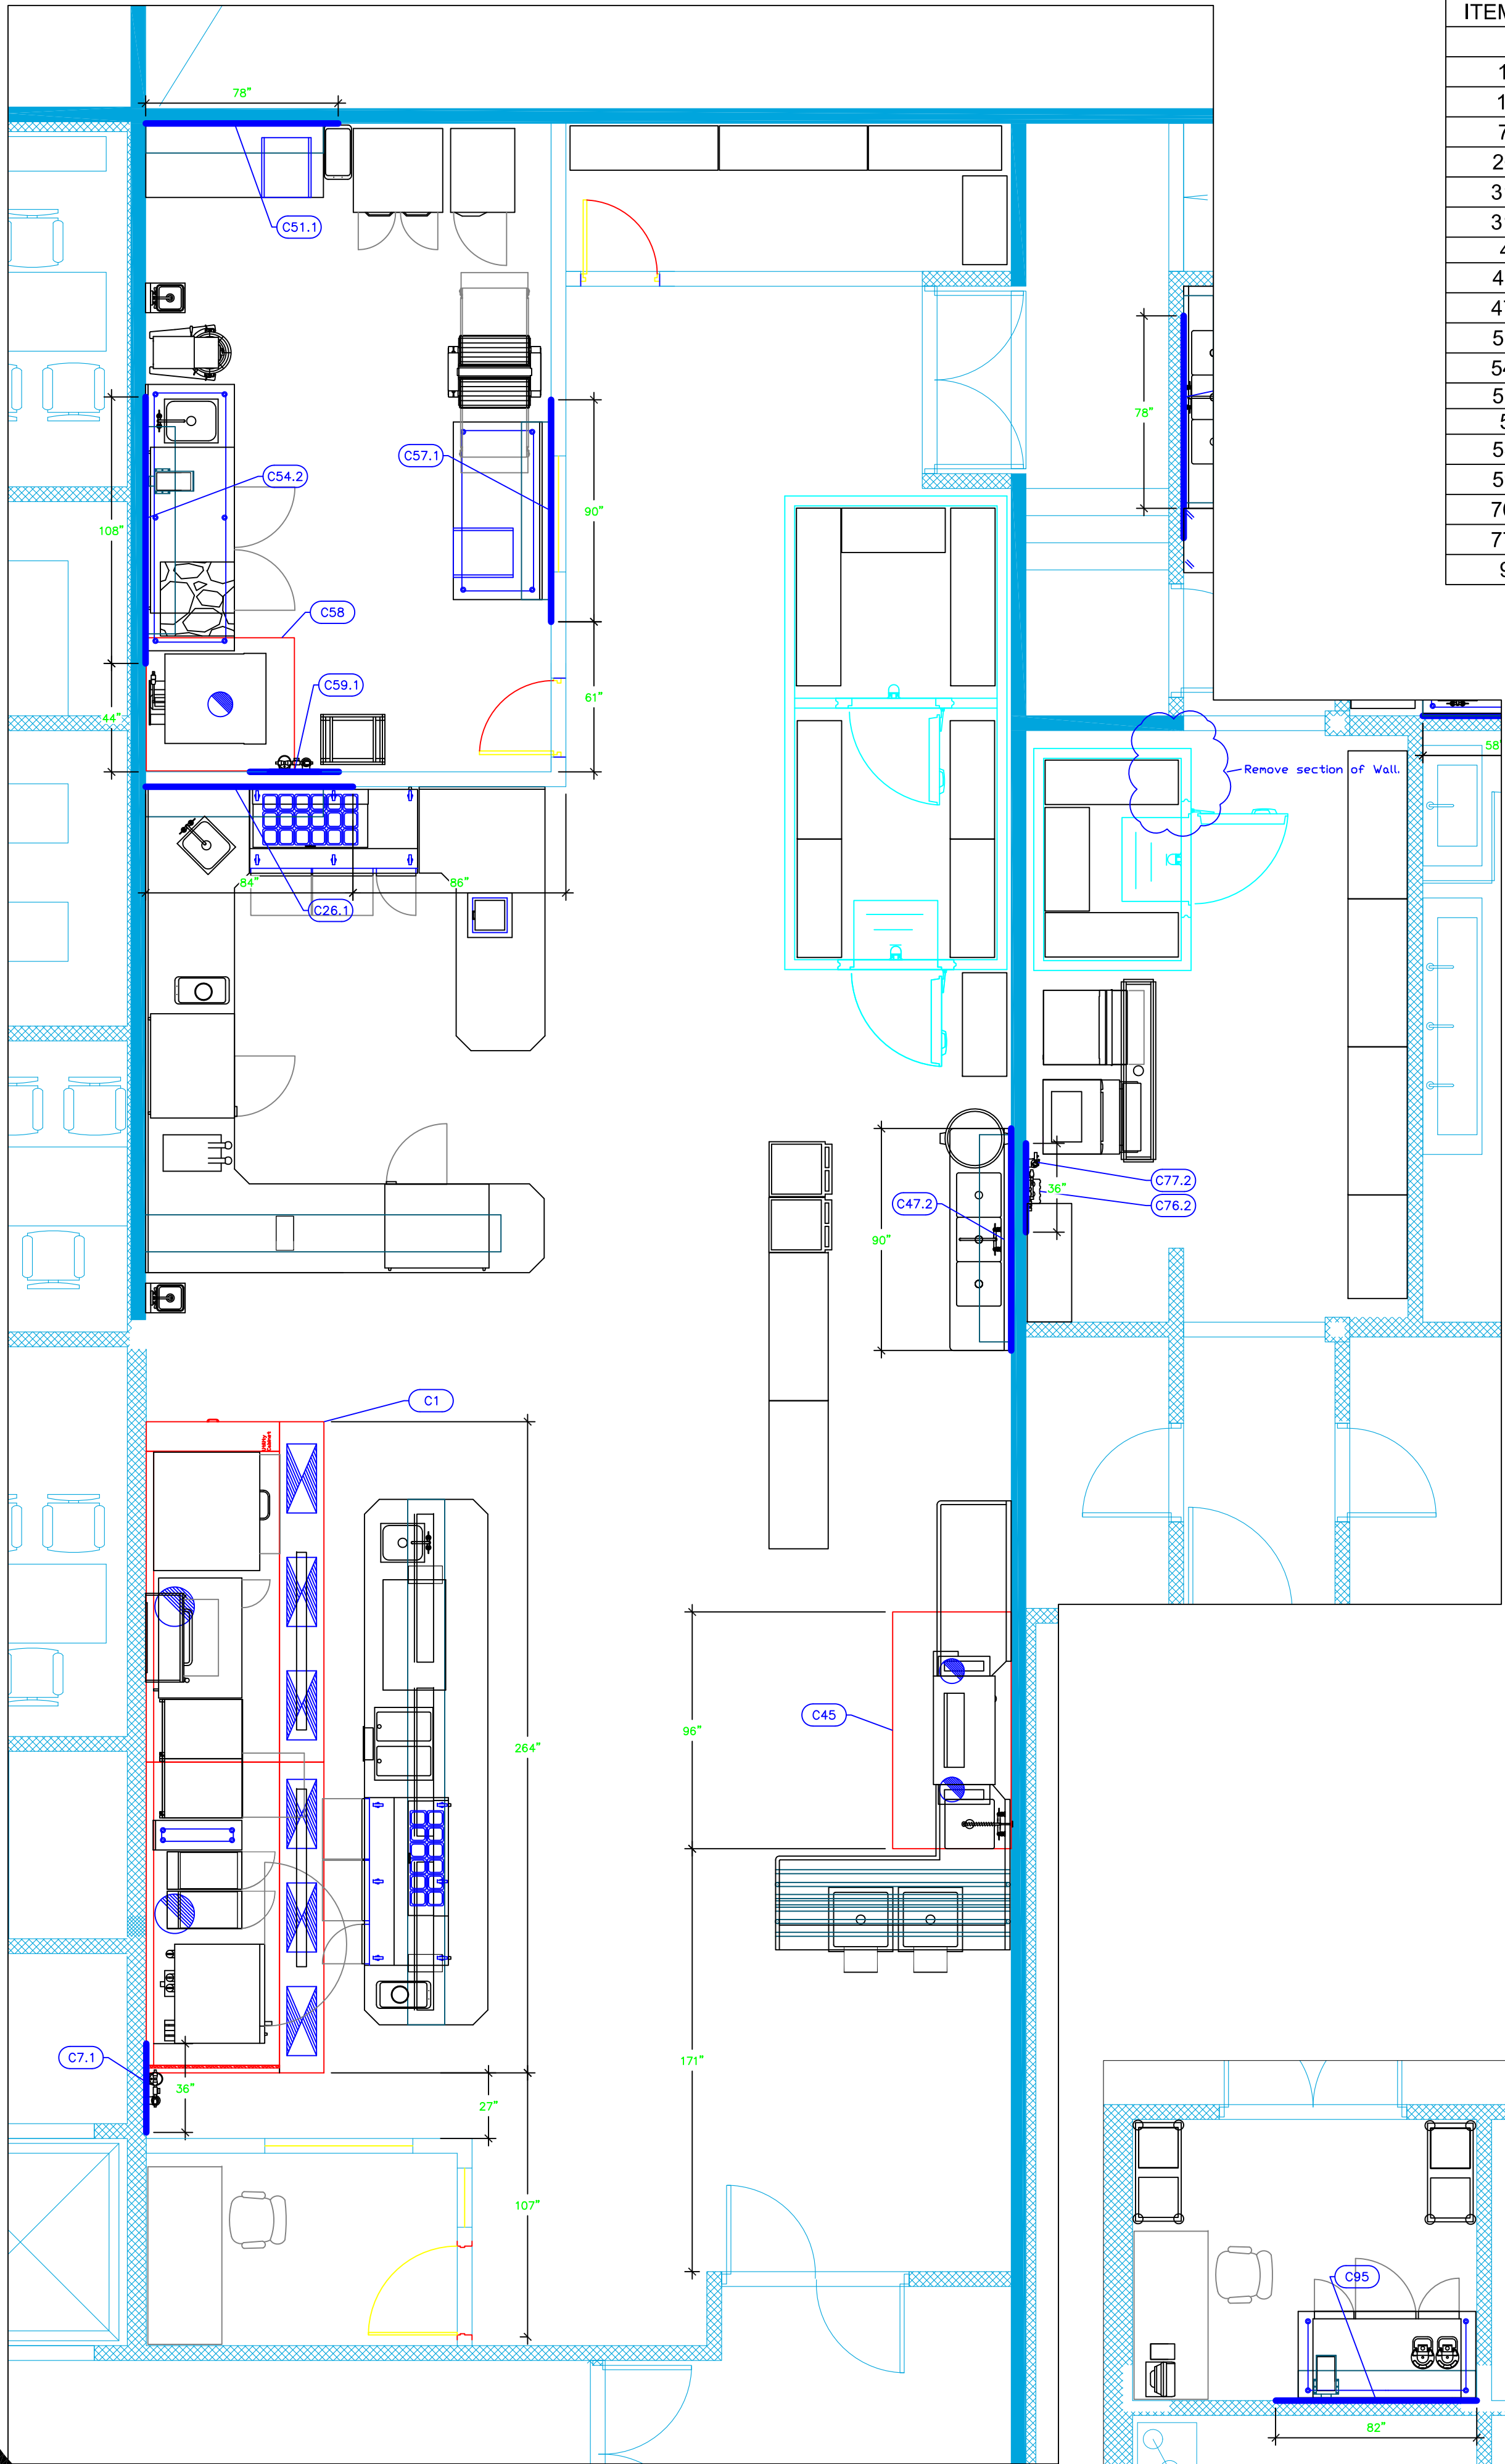

Mechanical Schedule						
ITEM NO.	QTY	DISCRIPTION	EXHAUST (L X W)	EXHAUST (CFM)	SUPPLY (L X W)	SUPPLY (CFM)
1	1	Main Hood	(2) 16"dia		(6) 28"x12"	
1.1	2	Exhaust Fan	(2) 26"x26"	2614 & 2678		
1.2	1	Supply Fan			29"x29"	4233
7.1	1	Water Filtration System, for Steam Equipment				
26.1	1	Shelving, Wall Mounted				
31.2	1	Shelving, Wall Mounted				
31.3	1	Water Filtration System, for Multiple Applications				
45	1	Exhaust Hood	(2) 10"dia			
45.1	1	Exhaust Fan	19"x19"	1200		
47.2	1	Overshelf				
51.1	1	Shelving, Wall Mounted				
54.2	1	Shelving, Wall Mounted				
57.1	1	Shelving, Wall Mounted				
58	1	Exhaust Hood	10" dia			
58.1	1	Exhaust Fan	19"x19"	675		
59.1	1	Water Filtration System, for Steam Equipment				
76.2	1	Water Filtration System, for Ice Machines				
77.2	1	Water Filtration System, for Ice Machines				
95	1	Shelving, Wall Mounted				

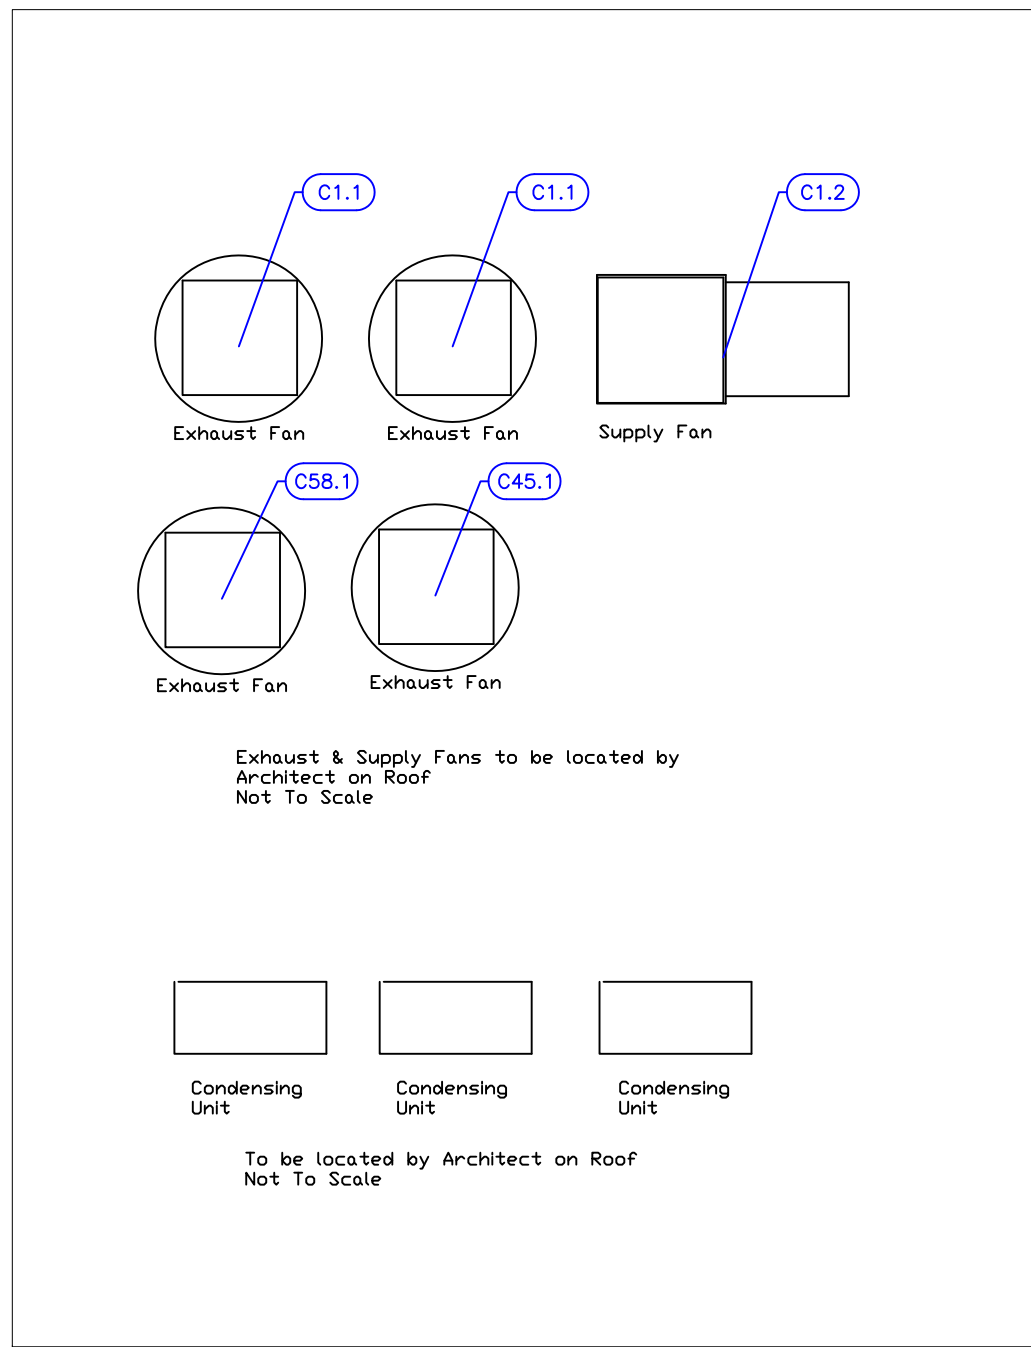

NOTE # M5:
ALL NATIONAL, STATE, AND LOCAL CODES SHALL APPLY.

NOTE # M6:
ARCHITECT OR ENGINEER TO SIZE AND LOCATE. CONTRACTOR TO PROVIDE ALL OPENINGS FOR DUCTS, PLUMBING LINES, ELECTRICAL LINES, AND REFRIGERATION LINES, AS REQUIRED BY EQUIPMENT.

NOTE # M7:
SUPPLY FANS TO BE LOCATED A MINIMUM OF 10' FROM EXHAUST FANS.

NOTE # M8:
SHEP DRAWING WILL BE PROVIDED BY MANUFACTURER FOR HOOD, EXHAUST FANS, & SUPPLY FANS, ONCE ORDER IS PLACE WITH.


NOTE # M9:
GENERAL CONTRACTOR TO PROVIDE 3/4" PLYWOOD WALL BACKING FROM 42" TO 78" AFF FOR ALL WALL MOUNTED EQUIPMENT.

NOTE # M10:
CEILING HEIGHTS TO BE VERIFIED FOR SUFFICIENT CLEARANCE FOR EQUIPMENT.

NOTE # M11:
REFRIGERATION CONTRACTOR TO HANG EVAPORATORS FOR WALK-IN, RUN & CHARGE LINES BETWEEN EVAP. & CONDENSING UNIT.

LEGEND -- MECHANICAL

- EXHAUST DUCT COLLAR
- SUPPLY DUCT COLLAR
- INWALL BACKING FOR WALL SHELVES
- RECESSED FLOOR
- RAISED EQUIPMENT PAD

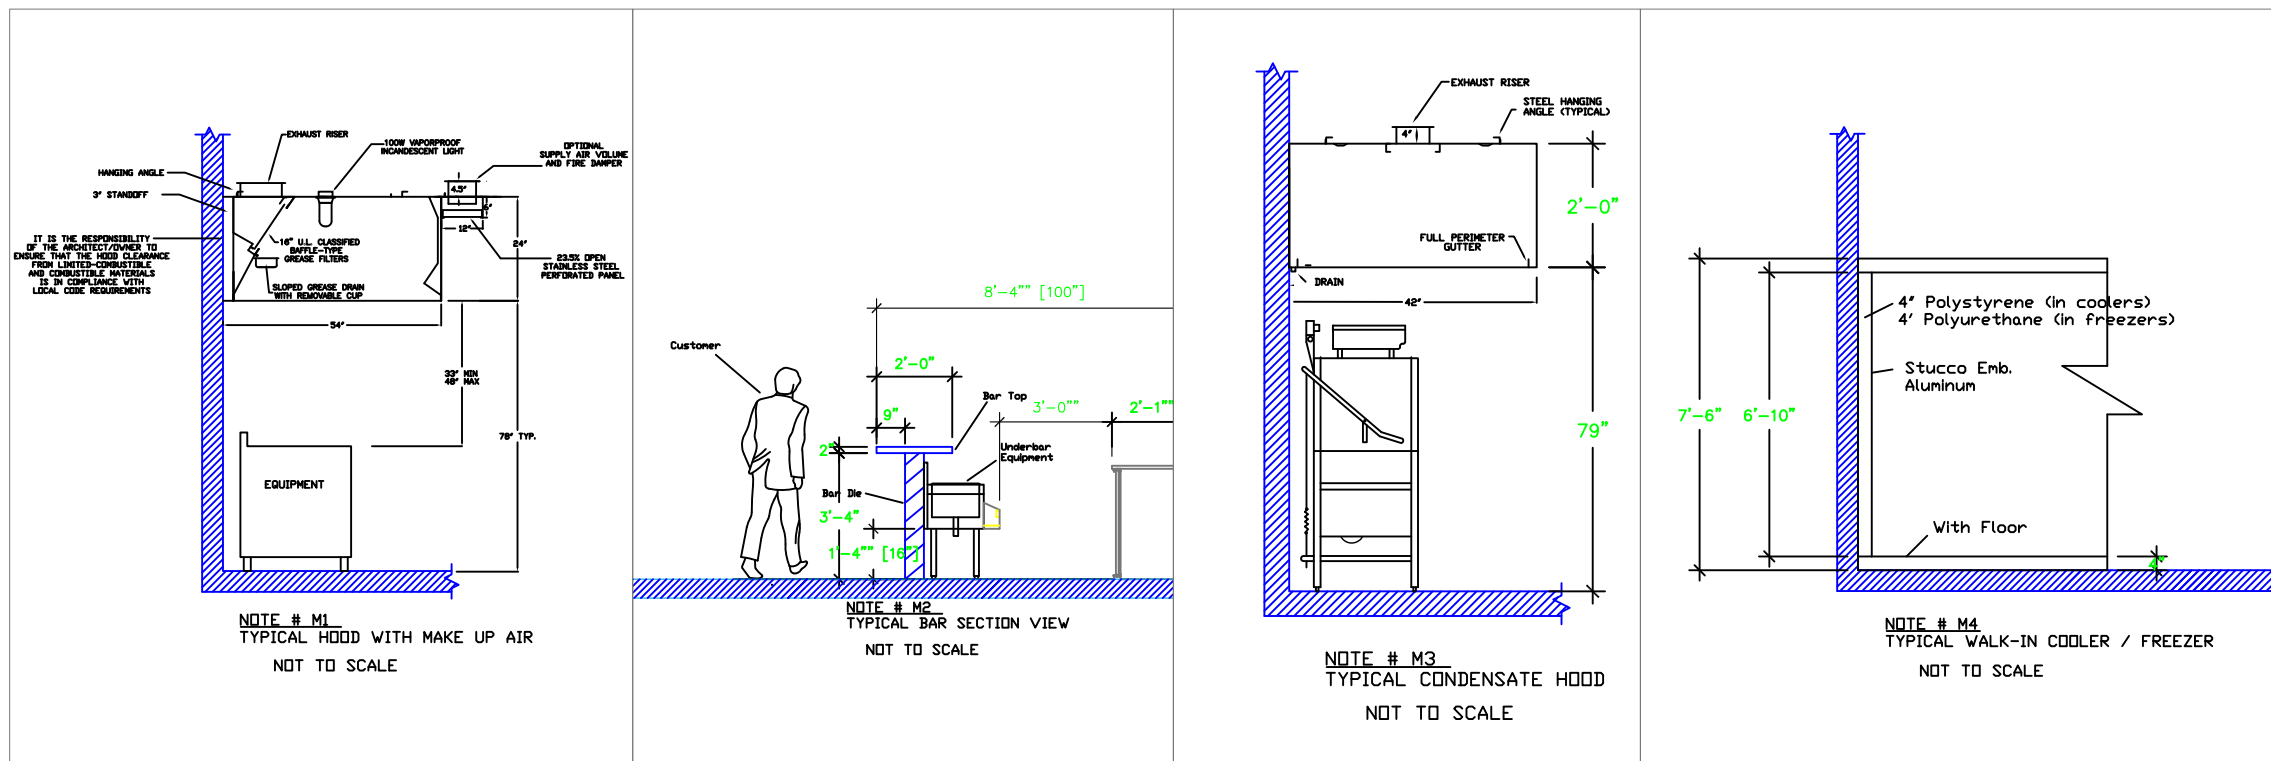

Equipment MECHANICAL Service Requirements

All Dimensions to be verified on the job site. Actual locations for floor drains, and any ventilating equipment to be determined by Engineer. Mechanical, Plumbing & Electrical to be checked and verified by Customers MEP Engineer. Remote Condensing Units to be located by Architect. Exhaust & Supply Fans to be located by Architect.

Rok Hotel Kingston Main Kitchen

Kingston, Jamaica

TAPESTRY COLLECTION BY HILTON™

INTERNATIONAL INC.

2055 W 73rd Street, Miami, FL 33016
Ph:(305)826-8696 Fax:(305)826-9131



8	Updated Background from Architect with Bar Change	6-24-20
9	Updated Background from Architect with Bar Change	10-29-20
10	Moved Garde Manger, Added Chef's office, New Bev Room	3-10-21
11	Added Back in MEP Information. Final	3-18-21
No.	Revision/Issue	Date

Date
March 18, 2021


Drawn By
Dayne Gauntlett

Scale
1/4" = 1'0"


Sheet
FF-2.0

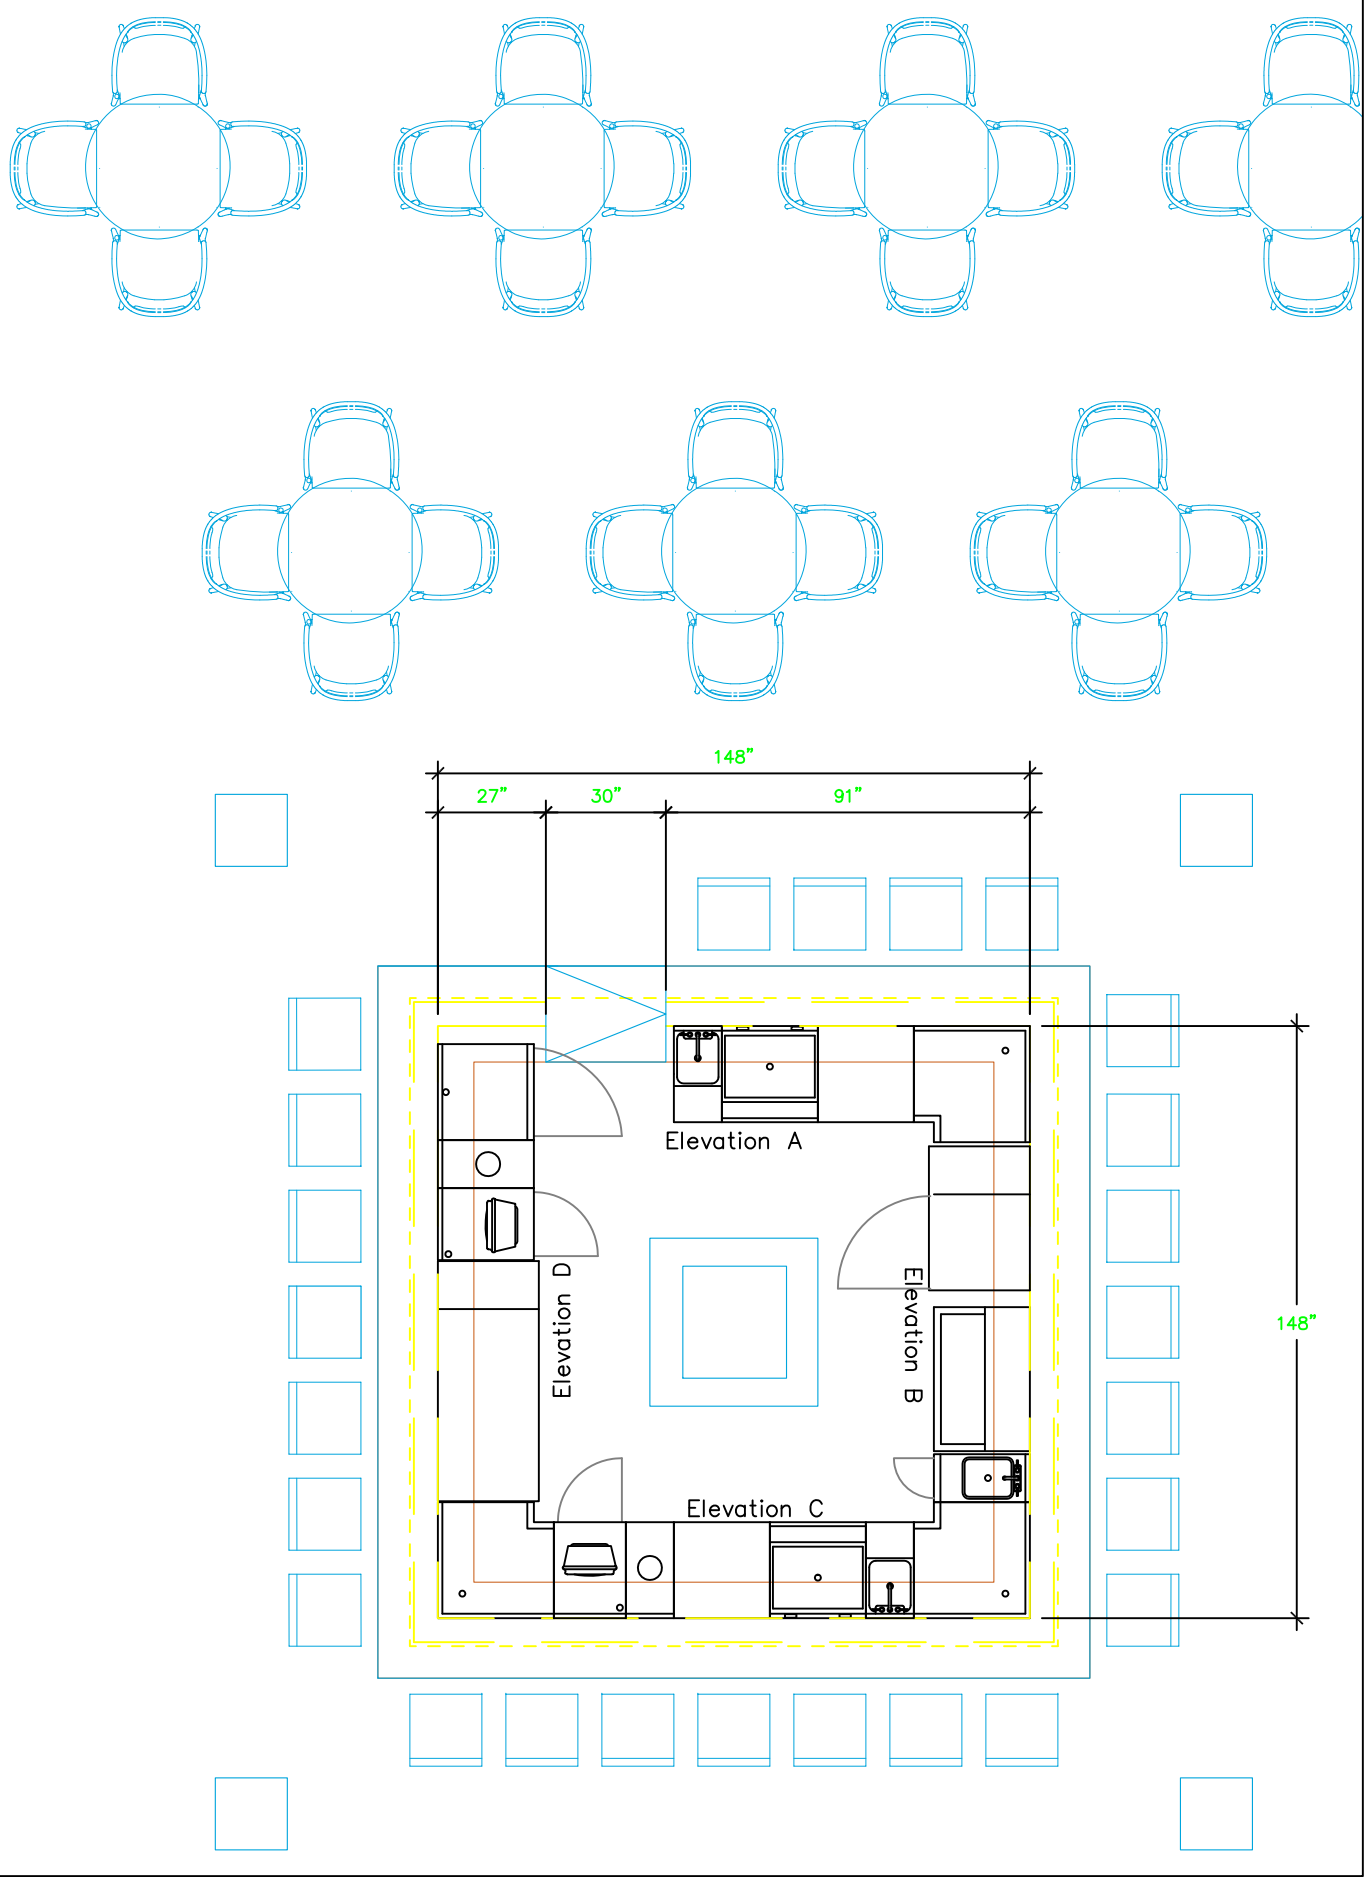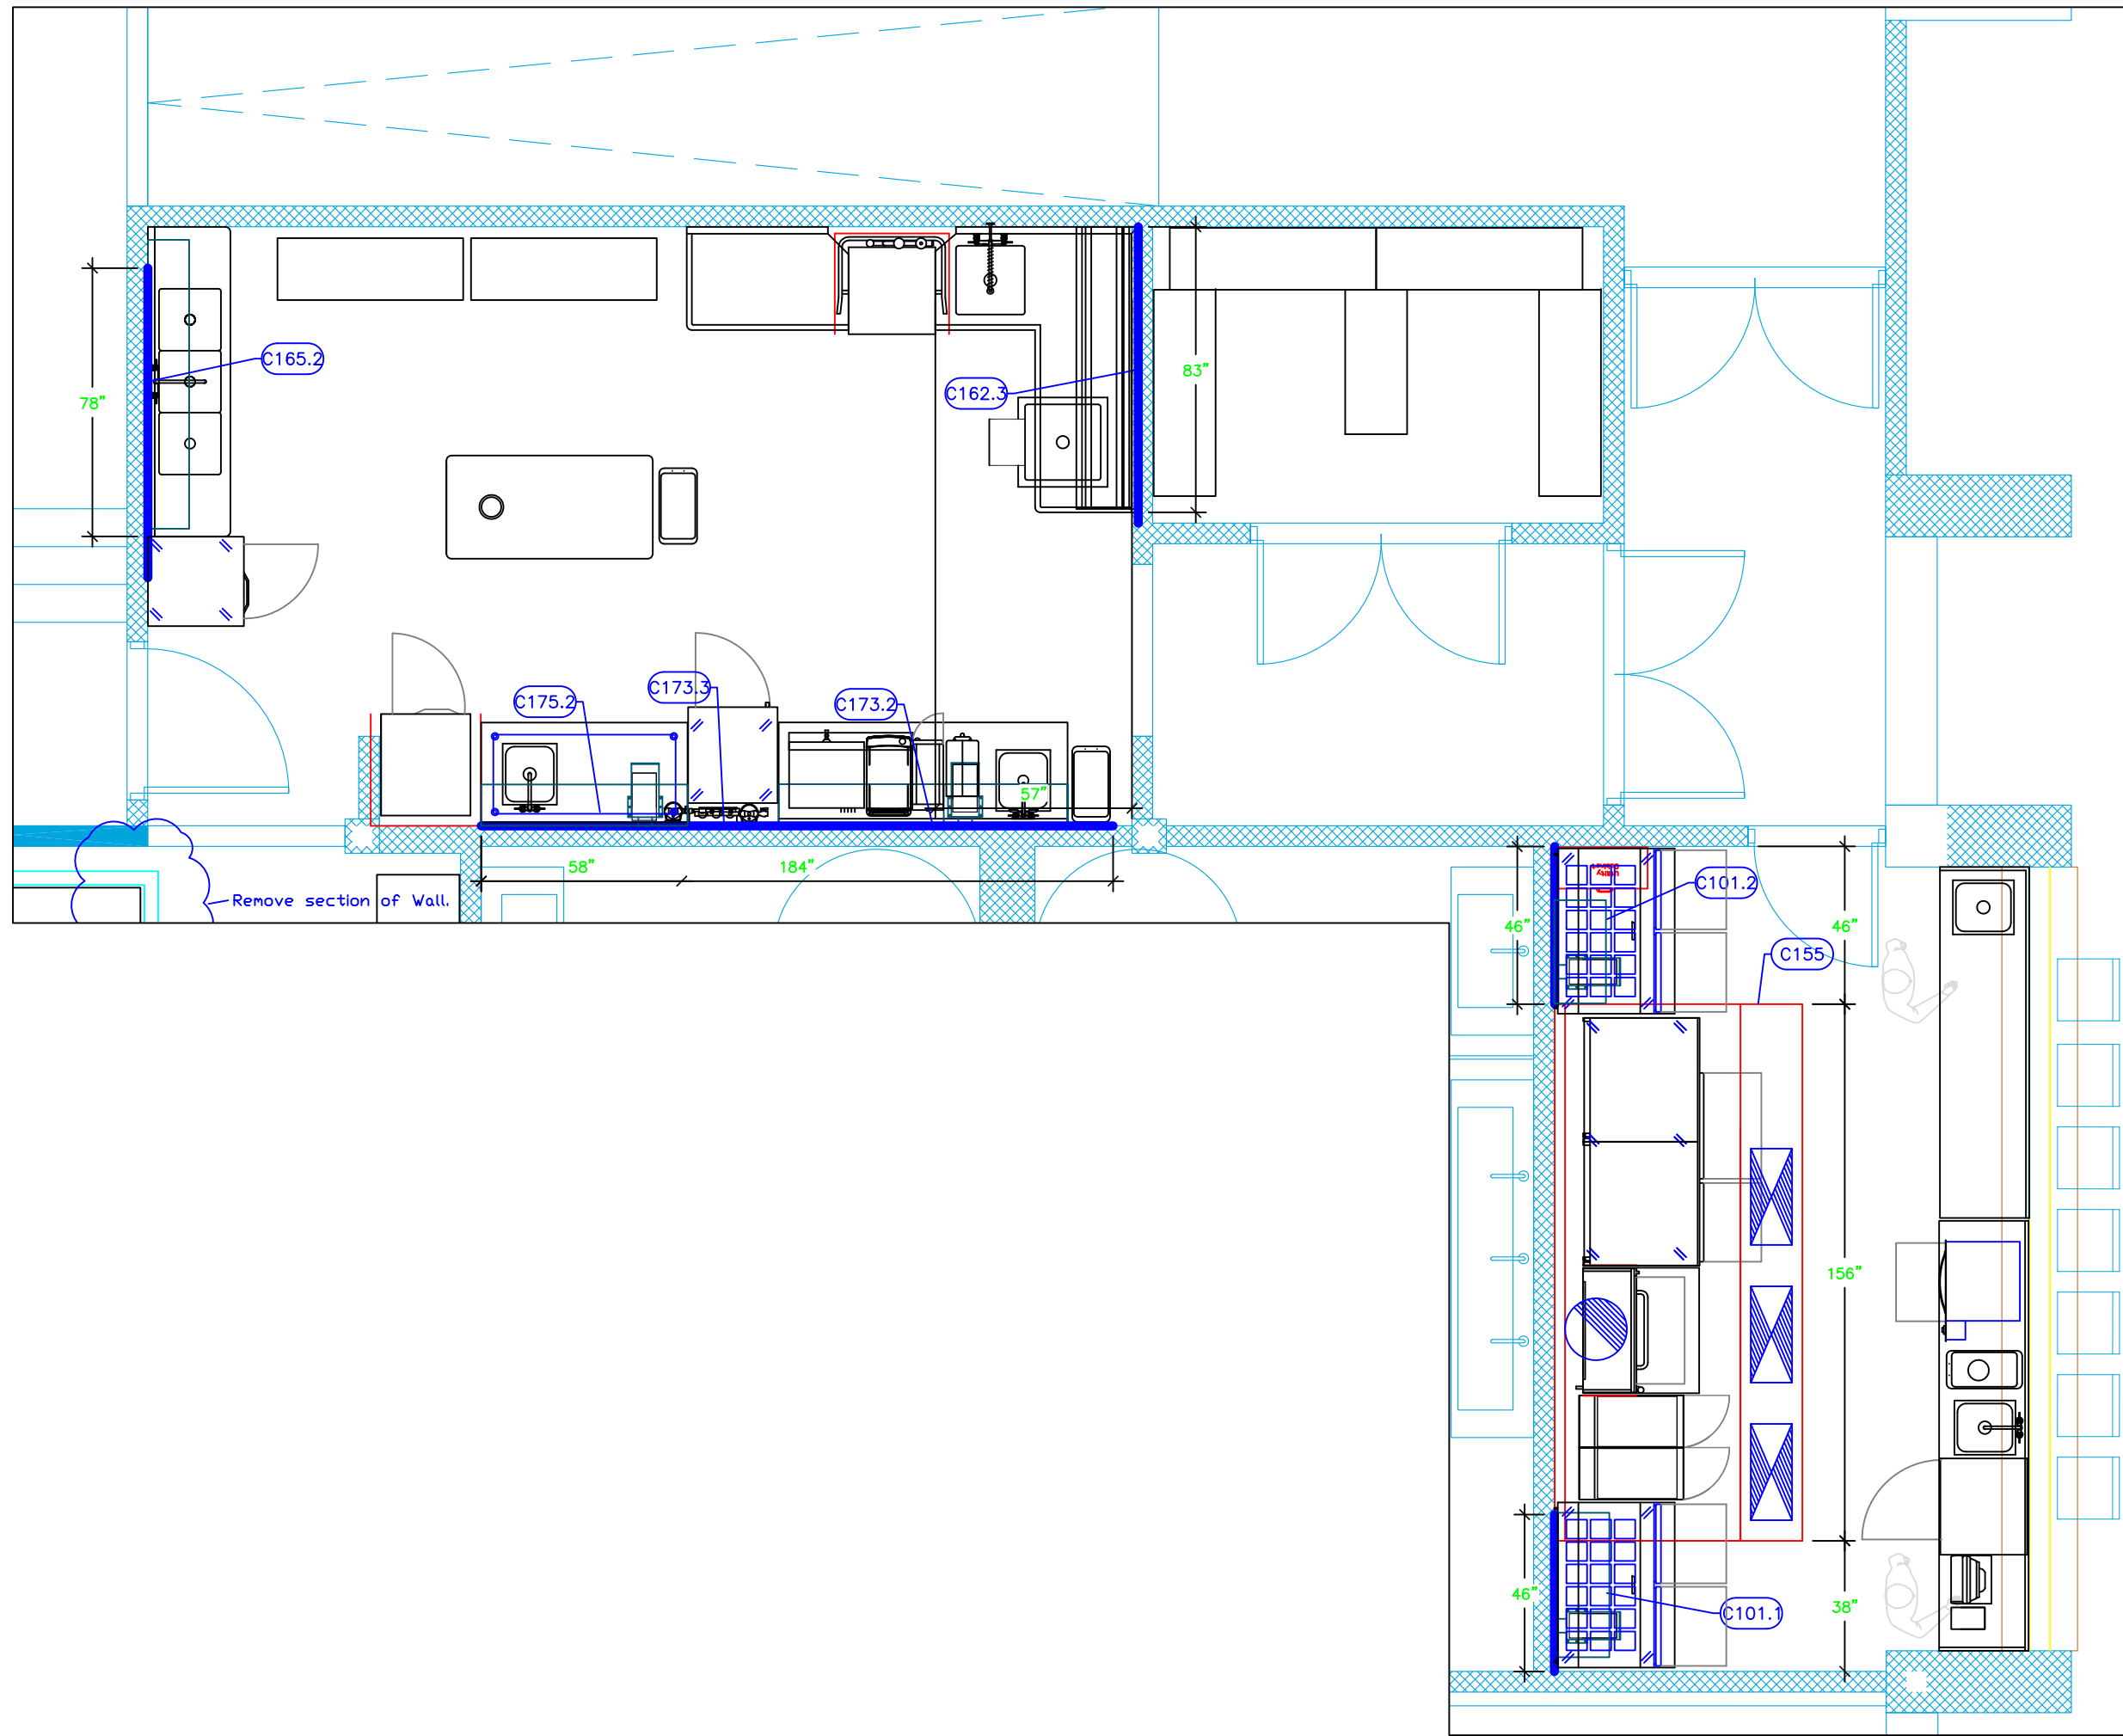

- LEGEND — MECHANICAL
- EXHAUST DUCT COLLAR
 - SUPPLY DUCT COLLAR
 - INWALL BACKING FOR WALL SHELVES
 - RECESSED FLOOR
 - RAISED EQUIPMENT PAD

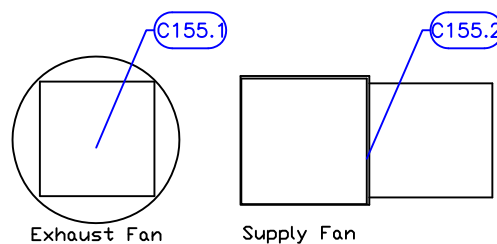

Exhaust & Supply Fans to be located by Architect on Roof
Not To Scale

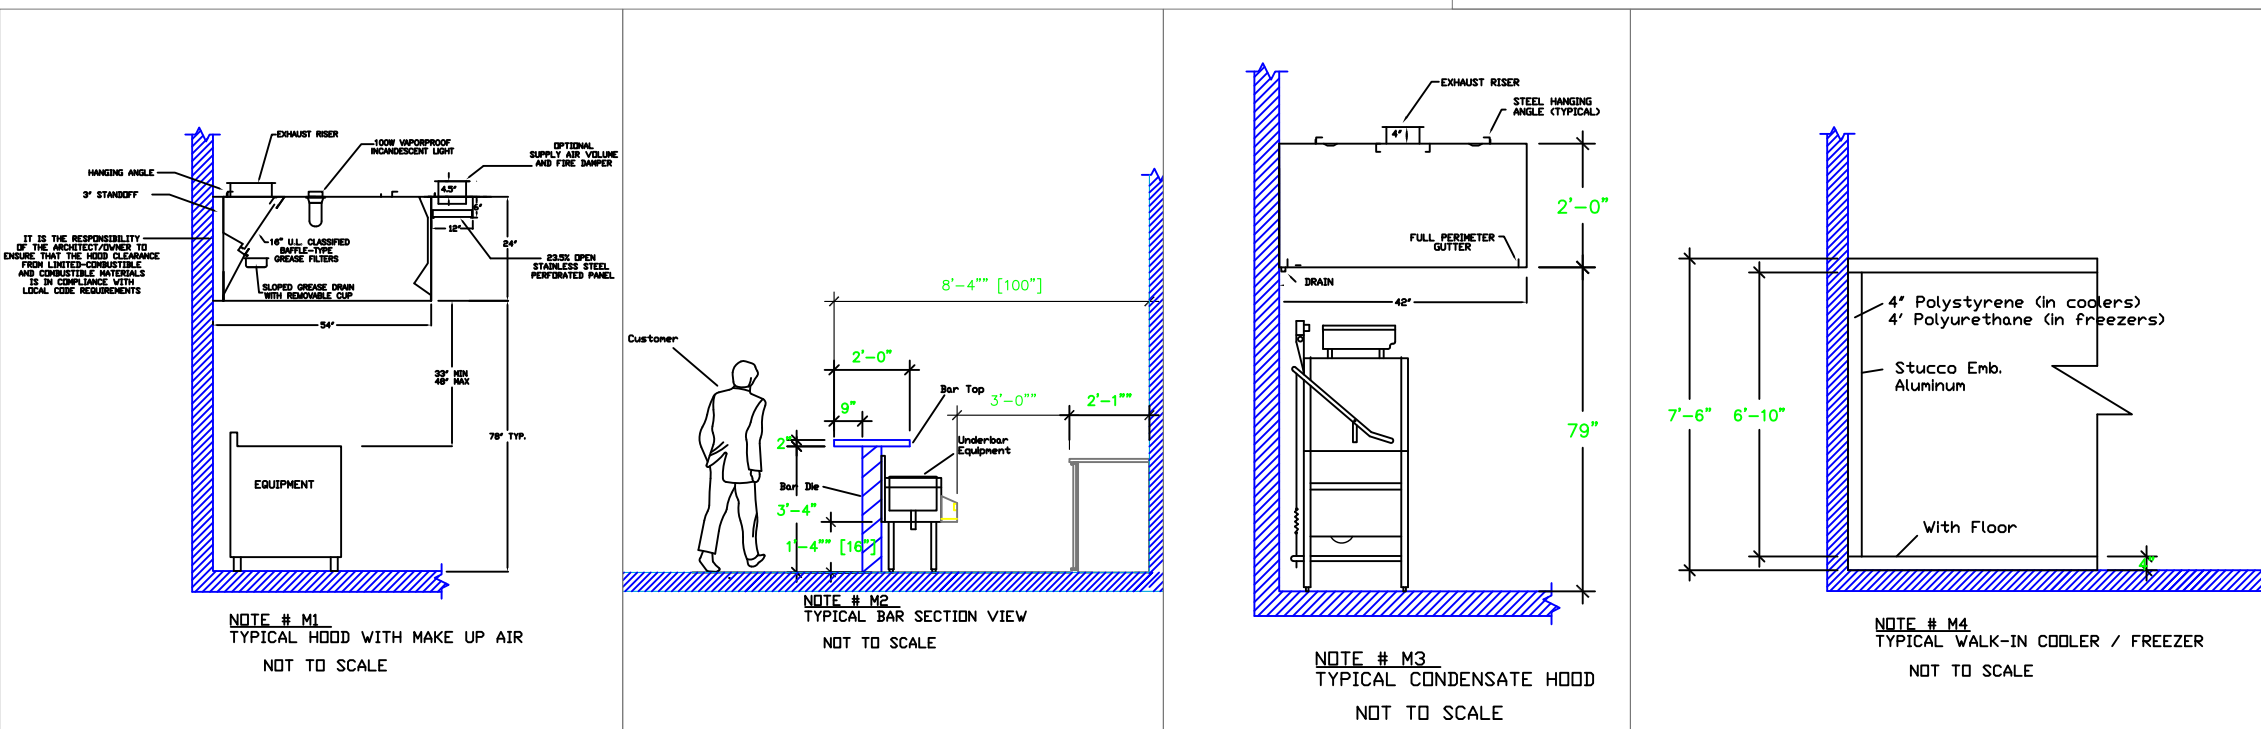

NOTE # M5
SHEP DRAWING WILL BE PROVIDED BY MANUFACTURER FOR HOOD, EXHAUST FANS, & SUPPLY FANS, UNCE ORDER IS PLACE WITH.

NOTE # M6
ARCHITECT OR ENGINEER TO SIZE AND LOCATE, CONTRACTOR TO PROVIDE ALL OPENINGS FOR DUCTS, PLUMBING LINES, ELECTRICAL LINES, AND REFRIGERATION LINES, AS REQUIRED BY EQUIPMENT.

NOTE # M7
SUPPLY FANS TO BE LOCATED A MINIMUM OF 10' FROM EXHAUST FANS.

NOTE # M8
SHEP DRAWING WILL BE PROVIDED BY MANUFACTURER FOR HOOD, EXHAUST FANS, & SUPPLY FANS, UNCE ORDER IS PLACE WITH.

NOTE # M9
GENERAL CONTRACTOR TO PROVIDE 2" PLYWOOD WALL BACKING FROM 48" TO 78" AFF FOR ALL WALL MOUNTED EQUIPMENT.

NOTE # M10
CEILING HEIGHTS TO BE VERIFIED FOR SUFFICIENT CLEARANCE FOR EQUIPMENT.

NOTE # M11
REFRIGERATION CONTRACTOR TO HANG EVAPORATORS FOR WALK-IN, RUN & CHARGE LINES BETWEEN EVAP. & CONDENSING UNIT.

Equipment MECHANICAL Service Requirements

All Dimensions to be verified on the job site. Actual locations for floor drains, and any ventilating equipment to be determined by Engineer. Mechanical, Plumbing & Electrical to be checked and verified by Customers MEP Engineer. Remote Condensing Units to be located by Architect. Exhaust & Supply fans to be located by Architect.

Mechanical Schedule							
ITEM NO.	QTY	DISCRIPTION	EXHAUST (L X W)	EXHAUST (CFM)	SUPPLY (L X W)	SUPPLY (CFM)	Ventilation Remarks
101.1	1	Shelving, Wall Mounted					Wall Backing See Note M9
102.1	1	Shelving, Wall Mounted					Wall Backing See Note M9
155	1	Grill Hood	18" dia		(3) 28"x12"		
155.1	1	Exhaust Fan	26"x26"	3025			
155.2	1	Supply Fan			29"x29"	2420	
165.2	1	Overshelf					Wall Backing See Note M9
173.2	1	Shelving, Wall Mounted					Wall Backing See Note M9
173.3	1	Water Filtration System, for Multiple Applications					Wall Backing See Note M9
175.2	1	Shelving, Wall Mounted					Wall Backing See Note M9

Rok Hotel Kingston
Outdoor Bar & Grill
Kingston, Jamaica

TAPESTRY
COLLECTION
BY HILTON™


uni-source
SUPPLY
INTERNATIONAL INC.

2055 W 73rd Street, Miami, FL 33016
Ph:(305)826-8696 Fax:(305)826-9131



8	Updated Background from Architect with Bar Change	6-24-20
9	Updated Background from Architect with Bar Change	10-29-20
10	Moved Garde Manger, Added Chef's office, New Bev Room	3-10-21
11	Added Back in MEP Information. Final	3-18-21
No.	Revision/Issue	Date

Date
March 18, 2021
Drawn By
Dayne Gauntlett
Scale
1/4" = 1'0"

Sheet
FF-2.1

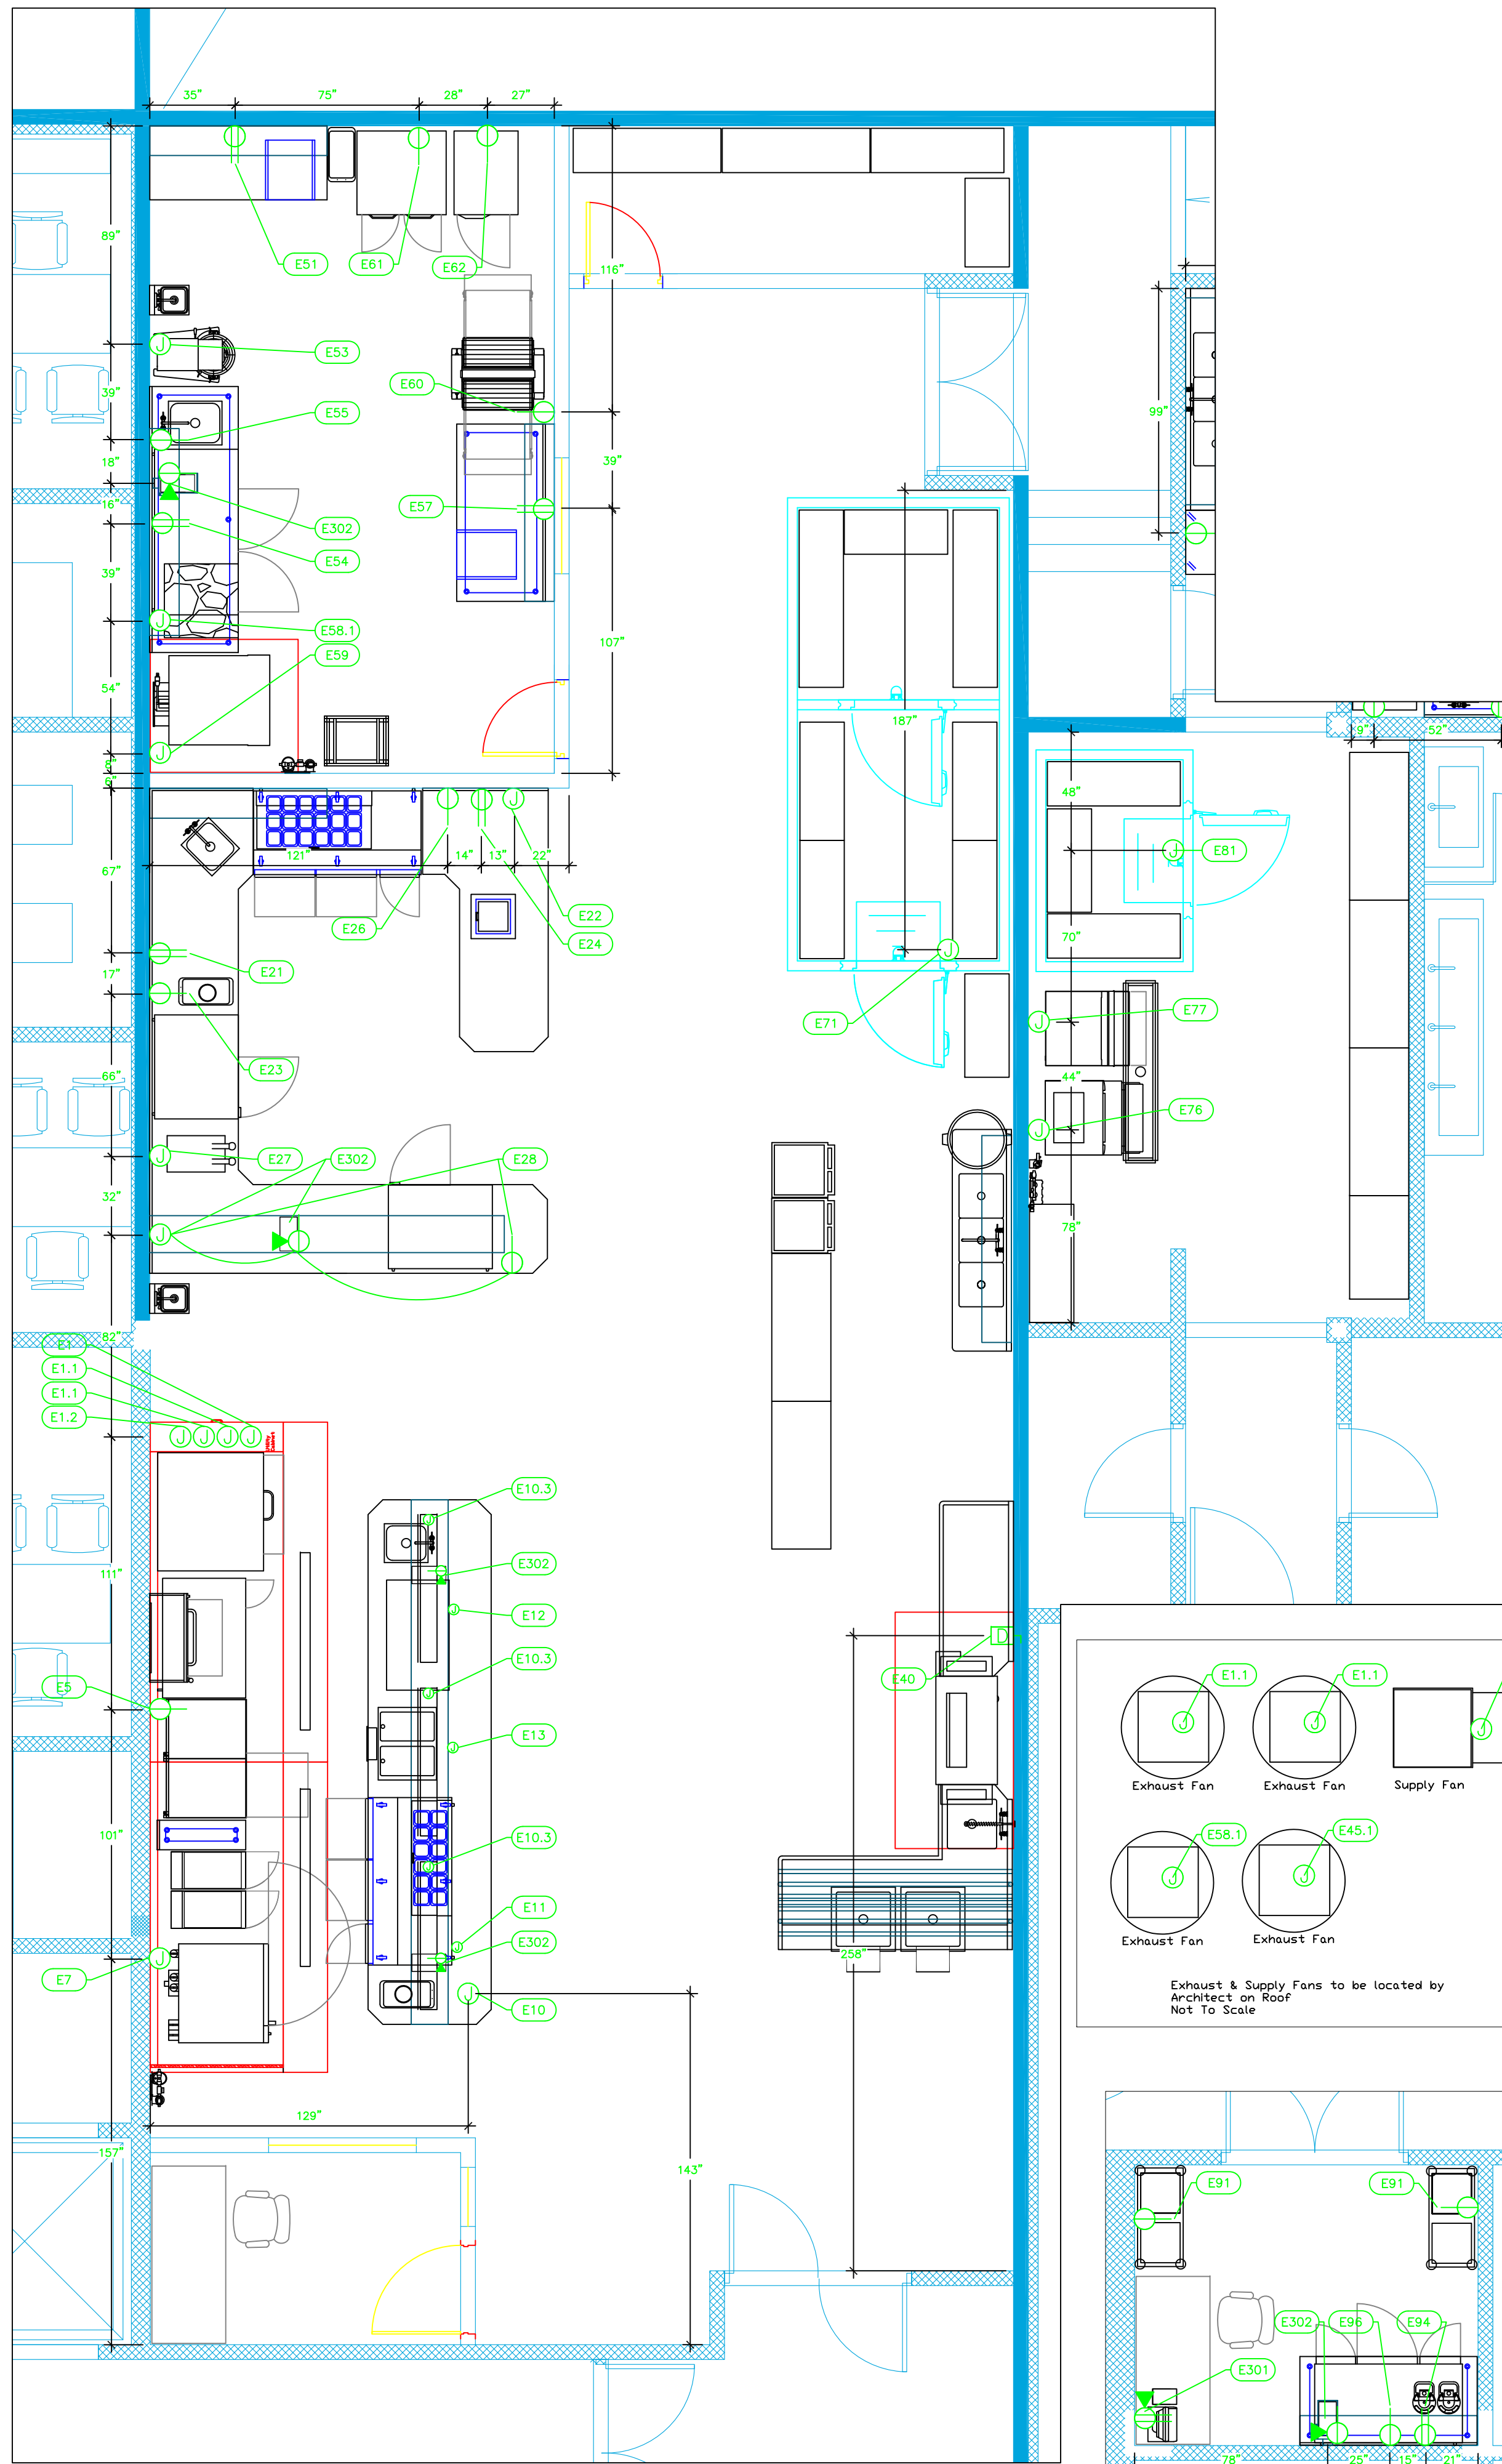

ELECTRICAL SCHEDULE											
ItemNo	Category	Voltage	Cycle	Phase	Amps	Hp	NEMA	ConnectionType	Rough-In AFF	Quantity	Electrical Remarks
1	Main Hood	115	50	1	15			J-Box	108"	1	Elec for Lights in Hood
1.1	Exhaust Fan	208	50	3	9.8	3		J-Box	108"	2	Elec at Hood Control Box
1.2	Supply Fan	208	50	3	9.8	3		J-Box	108"	1	Elec at Hood Control Box
5	Equipment Stand, Refrigerated Base	120	50-60	1	8.0	1/4		Simplex	18"	1	
7	Combi Oven, Gas	220	50	1	6.0	1/2		J-Box	18"	1	Electrician to provide Cord & Plug
10	Chef's Table	120/208	50	1	Verify			J-Box	0"	1	Main Incoming for Elec Panel, See Shops
10.3	Heat Lamp	120	50-60	1	11.7			J-box	n/a	3	Elec. Supply Prewired from #10 Elec. Panel
11	Sandwich / Salad Preparation Refrigerator	220	50	1	5.0	1/3		J-Box	n/a	1	Elec. Supply Prewired from #10 Elec. Panel
12	Cold Food Well Unit, Drop-In, Refrigerated	220/240	50/60	1	5.5	1/4		J-Box	n/a	1	Elec. Supply Prewired from #10 Elec. Panel
13	Hot Food Well Unit, Drop-In, Electric	208/240	50	1	6.7			J-Box	n/a	1	Elec. Supply Prewired from #10 Elec. Panel
21	Island Counter	110	50	1	15			Duplex	48"	1	Convenience Outlet. See Note E1
22	Ice Cream Dipping Cabinet	220	50	1		1/4		J-Box	18"	1	
23	Reach-In Undercounter Freezer	220	50	1	3.7	1/3		Simplex	18"	1	Electrician to provide Cord & Plug
24	Garge Mange Side Counter	115	50	1	15			Duplex	48"	1	Convenience Outlet. See Note E1
26	Mega Top Sandwich / Salad Preparation Refrigerator	220	50	1	5.0	1/3		Simplex	18"	1	Electrician to provide Cord & Plug
27	Electric Drop-In Fryer	208	50-60	1	27.7			J-Box	18"	1	
28	Undercounter Refrigerator	220	50	1	2.9	1/4		Simplex	18"	1	J-Box at wall connects to outlet in table
32	Reach-In Refrigerator	220	50	1	4.2	1/4		Simplex	76"	1	Electrician to provide Cord & Plug
33	Hot Water Dispenser	240	60	1	16.9			J-Box	48"	1	See Note E1
34	Espresso Cappuccino Machine	120	60	1	20		5-20P	Special	48"	1	See Note E1
	Milk Chiller	120	50/60	1	15		5-15P	Simplex	48"	1	See Note E1
35	Coffee Brewer	120/240	60	1	27.5			J-Box	48"	1	See Note E1
36	Coffee Grinder	120	60	1	11	3/4	5-15P	Simplex	48"	1	See Note E1
45.1	Exhaust Fan	115	50	1	6.3	1/2		J-Box	48"	1	Elec. at Hood Switch. See Note E6
51	Work Table, Bakers Top	115	50	1	15			Duplex	48"	1	Convenience Outlet. See Note E1
53	Planetary Mixer	208-240	50-60	1	4.98-4.50	1		J-Box	18"	1	
54	Work Table, Stainless Steel Top	115	50	1	15			Duplex	48"	1	Convenience Outlet. See Note E1
55	Undercounter Refrigerator	220	50	1	8.4	1/3		Simplex	18"	1	Electrician to provide Cord & Plug
57	Work Table, Stainless Steel Top	115	50	1	15			Duplex	48"	1	Convenience Outlet. See Note E1
58.1	Exhaust Fan	115	50	1	4.4	1/3		J-Box	48"	1	Interconnect to switch near hood.
59	Convection Oven / Proofer, Electric	220/380	50	3	20.0			J-Box	18"	1	
60	Dough Sheeter	220	50	3	2.60-7.35	3/4	L15-20	Simplex	18"	1	Electrician to provide Cord & Plug
61	Reach-In Refrigerator	220	50	1	3.6	1/4		Simplex	76"	1	Electrician to provide Cord & Plug
62	Reach-In Freezer	220	50	1	3.8	1/3		Simplex	76"	1	Electrician to provide Cord & Plug
71	Walk-in Combo	115	50	1	15			J-Box	ceiling	1	Elec. for lights in walk-in
71.1	Evaporator for Cooler	220	50	1				J-Box	ceiling	1	interconnect with Condenser 71.3
71.2	Evaporator for Freezer	220	50	1				J-Box	ceiling	1	interconnect with Condenser 71.4
71.3	Remote Condenser Unit for Cooler	220	50	1	3.3	7/8		J-Box	18"	1	Location by Architect
71.4	Remote Condenser Unit for Freezer	220	50	1	7.54	2		J-Box	18"	1	Location by Architect
76	Ice Maker, Cube-Style	220-240	50	1	13.5			Direct	72"	1	
77	Ice Maker, Cube-Style	220	50	1	6.5			J-Box	72"	1	
81	Walk-in Bev Cooler	115	50	1	15			J-Box	ceiling	1	Elec. for lights in walk-in
81.1	Evaporator for Cooler	220	50	1				J-Box	ceiling	1	interconnect with Condenser 71.3
81.2	Remote Condenser Unit for Cooler	220	50	1	1.88	1/2		J-Box	18"	1	Location by Architect
91	Dolly Cart	120	50-60	1	15			Simplex	18"	2	
92	Cabinet, Hand Lift	120	50-60	1	2.5				n/a	4	Cabinets connect to Cart #91
94	Work Table, Stainless Steel Top	115	50	1	15			Duplex	48"	1	Convenience Outlet. See Note E1
96	Undercounter Refrigerator	220	50	1	8.1	1/3		Simplex	18"	1	Electrician to provide Cord & Plug

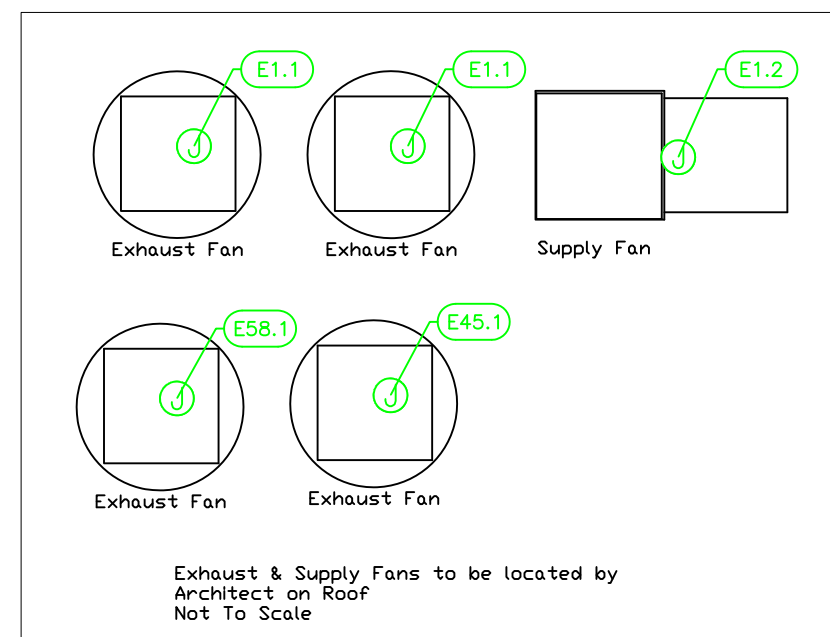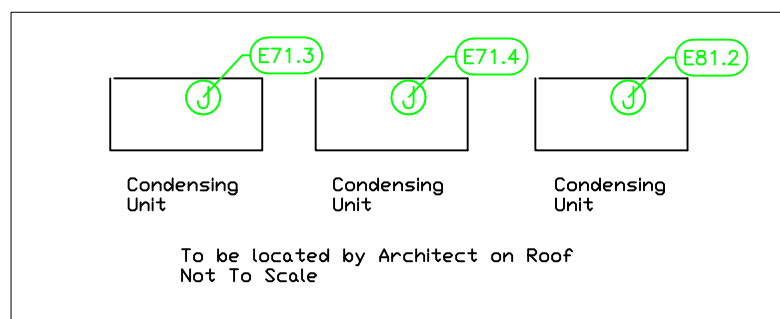

NOTE # E2:
ALL NATIONAL, STATE, AND LOCAL
CODES SHALL APPLY

NOTE # E3:
ALL ELECTRICAL CONNECTIONS
AND HARDWARE REQUIRED TO BE
PROVIDED BY ELECTRICAL
CONTRACTOR

NOTE # E4:
ALL JUNCTION BOXES, OUTLETS,
ETC. TO BE LOCATED SO AS TO
NOT INTERFERE WITH EQUIPMENT


NOTE # E5:
ALL RELAYS, CONTRACTORS,
STARTERS, AND SWITCHES
REQUIRED FOR EXHAUST & SUPPLY
FANS TO BE PROVIDED BY
ELECTRICAL CONTRACTOR
UNLESS SPECIFIED

NOTE # E6:
ELECTRICAL CONTRACTOR TO
INTERCONNECT DISHMACHINE TO
EXHAUST FAN FOR DISHMACHINE
SO THAT THE FAN RUNS WHEN
THE DISHMACHINE IS IN
OPERATION

NOTE # E7:
ELECTRICAL CONTRACTOR TO
INSTALL TABLE LIMIT SWITCH TO
END OF CLEAN DISHABLE TO
THAT MACHINE STOPS WHEN
SWITCH IS DEPRESSED

NOTE # E8:
ELECTRICAL CONTRACTOR TO
CONNECT DRAIN LINE HEATER,
PAN HEATER AND DOOR HEATER
FOR WALK-IN FREEZER

- LEGEND - ELECTRICAL CONNECTIONS
- ⊖ DUPLEX RECEPT., 15-AMP, 120-VOLT, GROUND TYPE, HORIZONTAL MOUNT
 - ⊖ SIMPLEX RECEPT., 120-VOLT, GROUND TYPE, HORIZONTAL MOUNT
 - ⊖ SPECIAL PURPOSE OUTLET, GROUND TYPE, HORIZONTAL MOUNT
 - ⊖ JUNCTION BOX, DIRECT CONNECTION
 - ⊖ DISCONNECT SWITCH, DIRECT CONNECTION
 - ⊖ FLOOR/CEILING RECEPTACLE AS INDICATED
 - ▲ (2) Telephone + (2) Data
 - FIELD CONNECTIONS
 - HARD WIRE CONNECTION POINT AT MACHINE

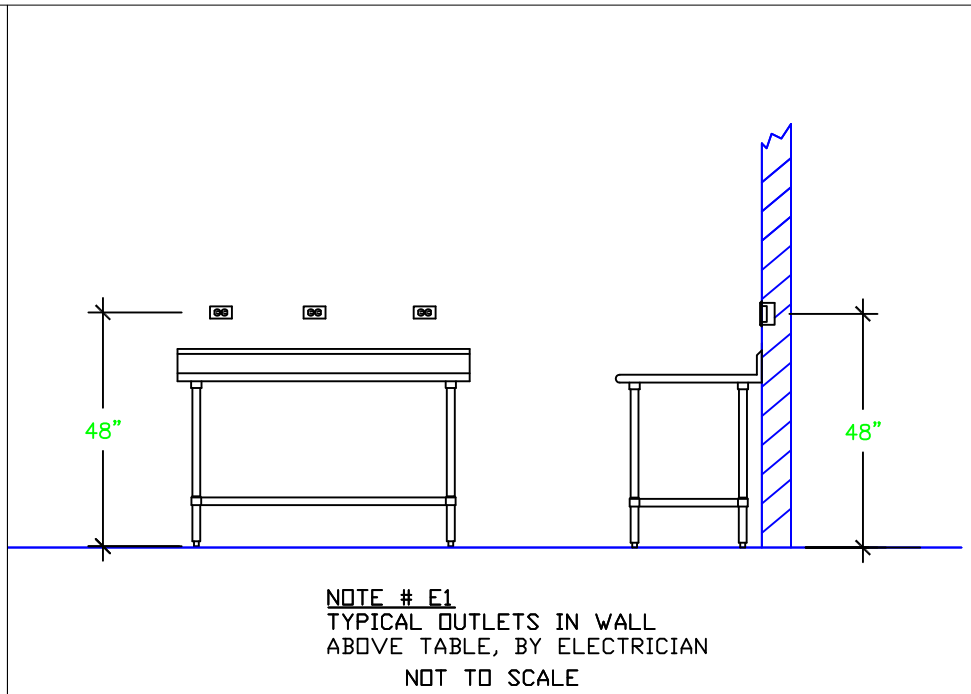

Equipment ELECTRICAL Service Requirements

All Dimensions to be verified on the job site.
Actual locations for floor drains, and any ventilating
equipment to be determined by Engineer.
Mechanical, Plumbing & Electrical to be checked and verified
by Customers MEP Engineer.
Remote Condensing Units to be located by Architect.
Exhaust & Supply fans to be located by Architect.

Rok Hotel Kingston
Main Kitchen
Kingston, Jamaica

TAPESTRY
COLLECTION
BY HILTON™

uni-source
SUPPLY
INTERNATIONAL INC.

2055 W 73rd Street, Miami, FL 33016
Ph:(305)826-8696 Fax:(305)826-9131

8	Updated Background from Architect with Bar Change	6-24-20
9	Updated Background from Architect with Bar Change	10-29-20
10	Moved Garge Mange, Added Chef's office, New Bev Room	3-10-21
11	Added Back in MEP Information. Final	3-18-21
No.	Revision/Issue	Date

Date
March 18, 2021
Drawn By
Dayne Gauntlett
Scale
1/4" = 1'0"

Sheet
FF-3.0

Rok Hotel Kingston
Outdoor Bar & Grill
Kingston, Jamaica

TAPESTRY
COLLECTION
BY HILTON™



INTERNATIONAL INC.

2055 W 73rd Street, Miami, FL 33016
Ph:(305)826-8696 Fax:(305)826-9131

8	Updated Background From Architect with Bar Change	6-24-20
9	Updated Background From Architect with Bar Change	10-29-20
10	Moved Garde Manger, Added Chef's office, New Bev Room	3-10-21
11	Added Back in MEP Information. Final	3-18-21
No.	Revision/Issue	Date

Date

March 18, 2021

Drawn By


Dayne Gauntlett

Scale

1/4" = 1'0"

Sheet

FF-3.1

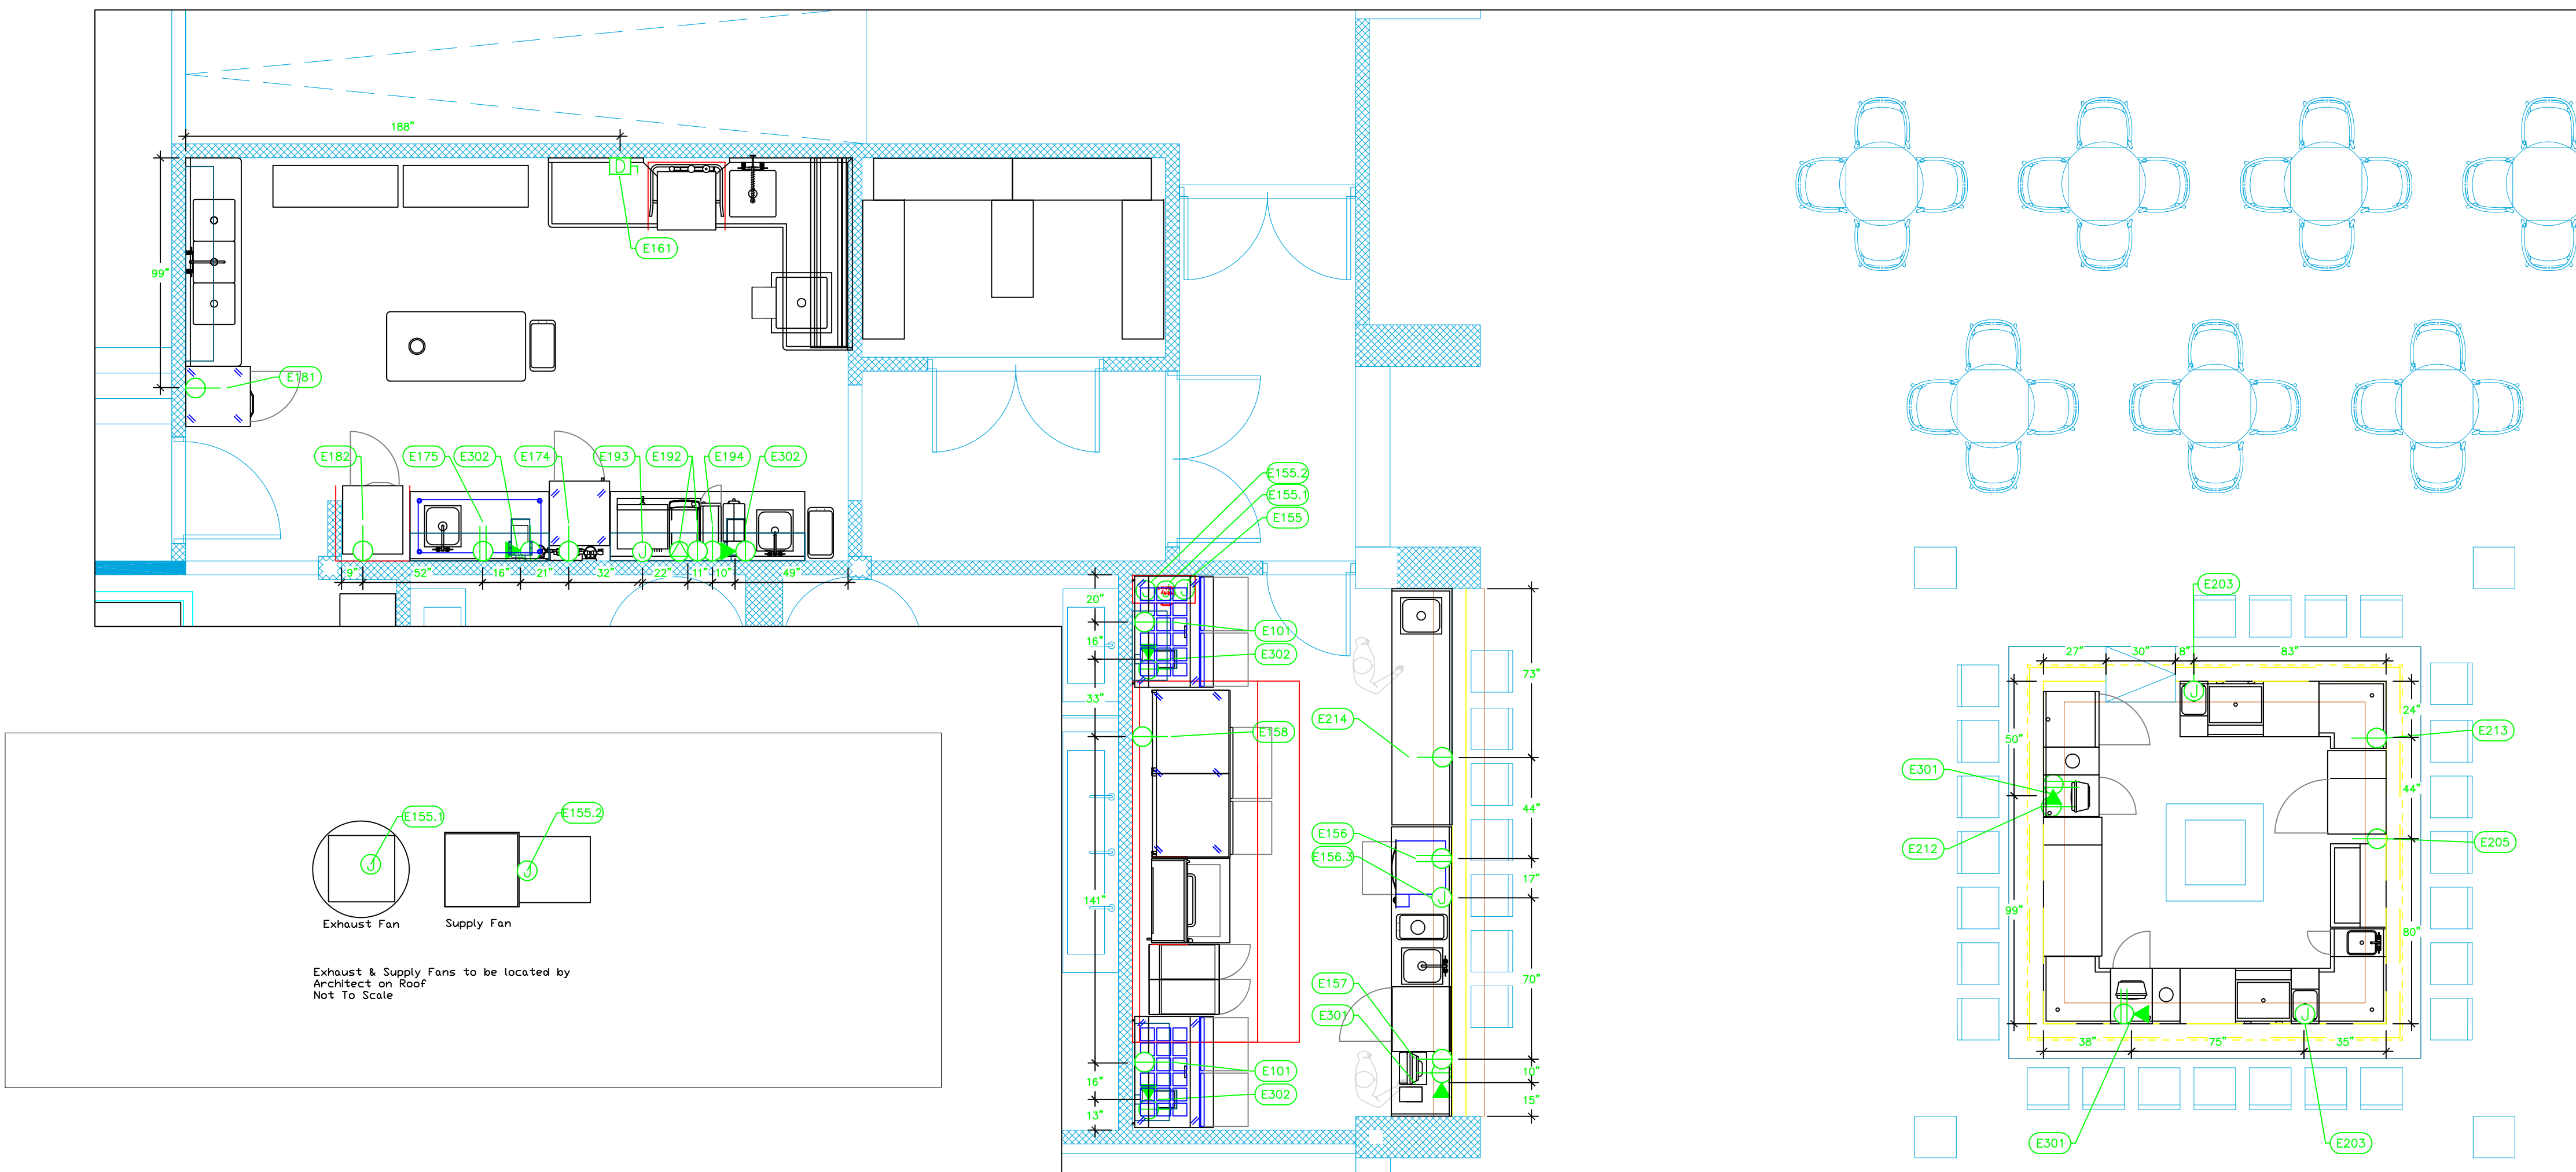

ELECTRICAL SCHEDULE											
ItemNo	Category	Voltage	Cycle	Phase	Amps	Hp	NEMA	ConnectionType	Rough-In AFF	Quantity	Electrical Remarks
101	Mega Top Sandwich / Salad Preparation Refrigerator	220	50	1	3.6	1/4		Simplex	18"	2	Electrician to provide Cord & Plug
107	Bottle Cooler	220	50	1	3.7	1/6		Simplex	18"	1	Moved to Beverage Room
155	Grill Hood	115	50	1	15			J-Box	108"	1	Elec for Lights in Hood
155.1	Exhaust Fan	208	50	3	9.8	3		J-Box	108"	1	Elec at Hood Control Box
155.2	Supply Fan	208	50	3	3.8	3		J-Box	108"	1	Elec at Hood Control Box
156	Work Table, Cabinet Base Hinged Doors	115	50	1	15			Duplex	40"	1	Horizontal Mounted Convenience Outlets
156.3	Warming Drawer, Built-In	120	50-60	1	7.5			J-Box	18"	1	
157	Glass Froster	220	50	1		1/3		Simplex	18"	1	Electrician to provide Cord & Plug
158	Equipment Stand, Refrigerated Base	220	50	1	2.0	1/4		Simplex	18"	1	Electrician to provide Cord & Plug
161	Dishwasher, Door Type, Ventless	220	50	3	tbd	1		Disconnect	18"	1	Disconnect for Wet Location
174	Reach-in Display Refrigerator, 1 section	220	50	1	8.1	1/3		Simplex	80"	1	Electrician to provide Cord & Plug
175	Work Table, Stainless Steel Top	110	50	1	15			Duplex	48"	1	Convenience Outlet. See Note E1
181	Reach-In Refrigerator	220	50	1	4.9	1/4		Simplex	18"	1	Electrician to provide Cord & Plug
182	Reach-In Freezer	220	50	1	3.8	1/3		Simplex	76"	1	Electrician to provide Cord & Plug
192	Espresso Cappuccino Machine	120	60	1	20		5-20P	Special	48"	1	See Note E1
	Milk Chiller	120	60	1	15		5-15P	Simplex	48"	1	See Note E1
193	Coffee Brewer	120/240	60	1	27.5			J-Box	48"	1	See Note E1
194	Coffee Grinder	120	60	1	11	3/4	5-15P	Simplex	48"	1	See Note E1
203	Blender Station	110/220	50	1	15			J-Box	18"	2	J-box to receptacle on machine
205	Bottle Cooler	220	50	1	3.7	1/6		Simplex	18"	1	Electrician to provide Cord & Plug
212	Back Bar Cabinet, Refrigerated	220	50	1	7.0	1/4		Simplex	18"	1	Electrician to provide Cord & Plug
213	Back Bar Cabinet, Refrigerated	220	50	1	7.0	1/8		Simplex	18"	1	Electrician to provide Cord & Plug
214	Table	120	50	1	15			Simplex	18"	1	Extra Plug from Previous Refrigerator
301	POS System	110/220	50	1	tbd			Duplex	18"	4	Confirm Electrical, & Data
								DATA	18"	4	
302	POS Printer	110/220	50	1	tbd			Simplex	18"	10	Confirm Electrical, & Data
								DATA	18"	10	

NOTE # E2:
ALL NATIONAL, STATE, AND LOCAL
CODES SHALL APPLY

NOTE # E3:
ALL ELECTRICAL CONNECTIONS
AND HARDWARE REQUIRED TO BE
PROVIDED BY ELECTRICAL
CONTRACTOR

NOTE # E4:
ALL JUNCTION BOXES, OUTLETS,
ETC. TO BE LOCATED SO AS TO
NOT INTERFERE WITH EQUIPMENT

NOTE # E5:
ALL RELAYS, CONTRACTORS,
STARTERS, AND SWITCHES
REQUIRED FOR EXHAUST & SUPPLY
FANS TO BE PROVIDED BY
ELECTRICAL CONTRACTOR
UNLESS SPECIFIED


NOTE # E6:
ELECTRICAL CONTRACTOR TO
INTERCONNECT DISHMACHINE TO
EXHAUST FAN FOR DISHMACHINE
SO THAT THE FAN RUNS WHEN
THE DISHMACHINE IS IN
OPERATION.

NOTE # E7:
ELECTRICAL CONTRACTOR TO
INSTALL TABLE LIMIT SWITCH TO
END OF CLEAN DISHTABLE TO
THAT MACHINE STOPS WHEN
SWITCH IS DEPRESSED.

NOTE # E8:
ELECTRICAL CONTRACTOR TO
CONNECT DRAIN LINE HEATER,
PAN HEATER AND DODR HEATER
FOR WALK-IN FREEZER.



LEGEND - ELECTRICAL CONNECTIONS

- ⊕ DUPLEX RECEPT., 15-AMP, 120-VOLT, GROUND TYPE, HORIZONTAL MOUNT
- ⊖ SIMPLEX RECEPT., 120-VOLT, GROUND TYPE, HORIZONTAL MOUNT
- ⊙ SPECIAL PURPOSE OUTLET, GROUND TYPE, HORIZONTAL MOUNT
- ⊕ JUNCTION BOX, DIRECT CONNECTION
- ⊖ DISCONNECT SWITCH, DIRECT CONNECTION
- ⊙ FLOOR/CEILING RECEPTACLE AS INDICATED
- ▲ (2) Telephone + (2) Data
- FIELD CONNECTIONS
- HARD WIRE CONNECTION POINT AT MACHINE

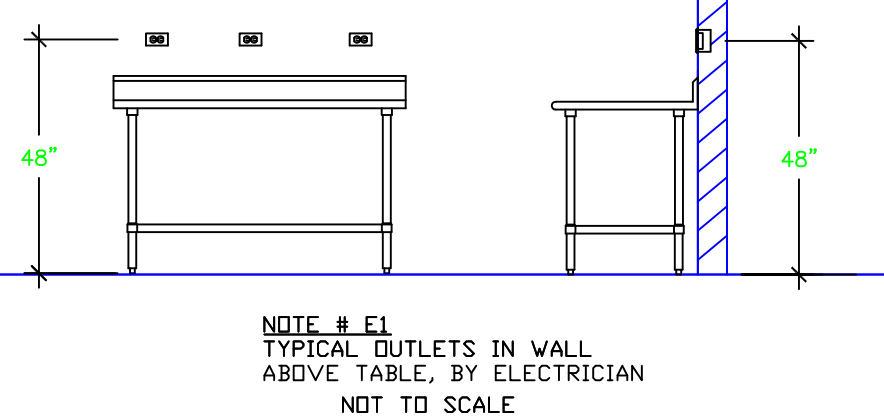


Equipment
ELECTRICAL
Service Requirements

All Dimensions to be verified on the job site.
Actual locations for floor drains, and any ventilating
equipment to be determined by Engineer.
Mechanical, Plumbing & Electrical to be checked and verified
by Customers MEP Engineer.
Remote Condensing Units to be located by Architect.
Exhaust & Supply fans to be located by Architect.

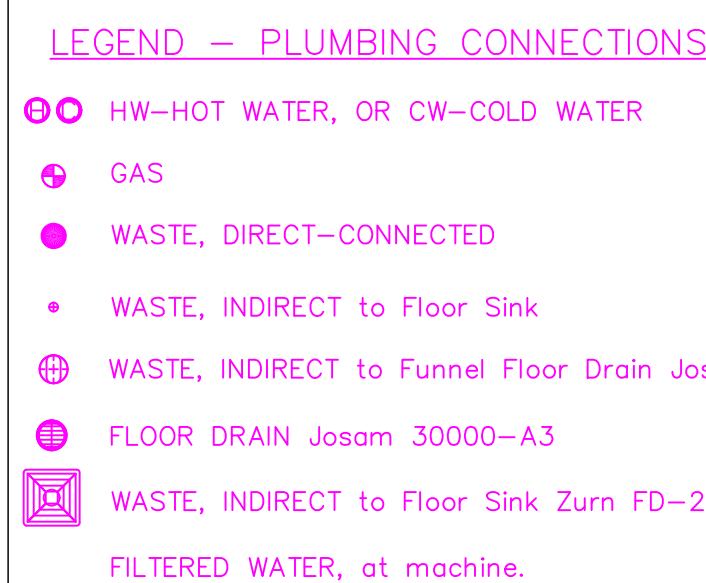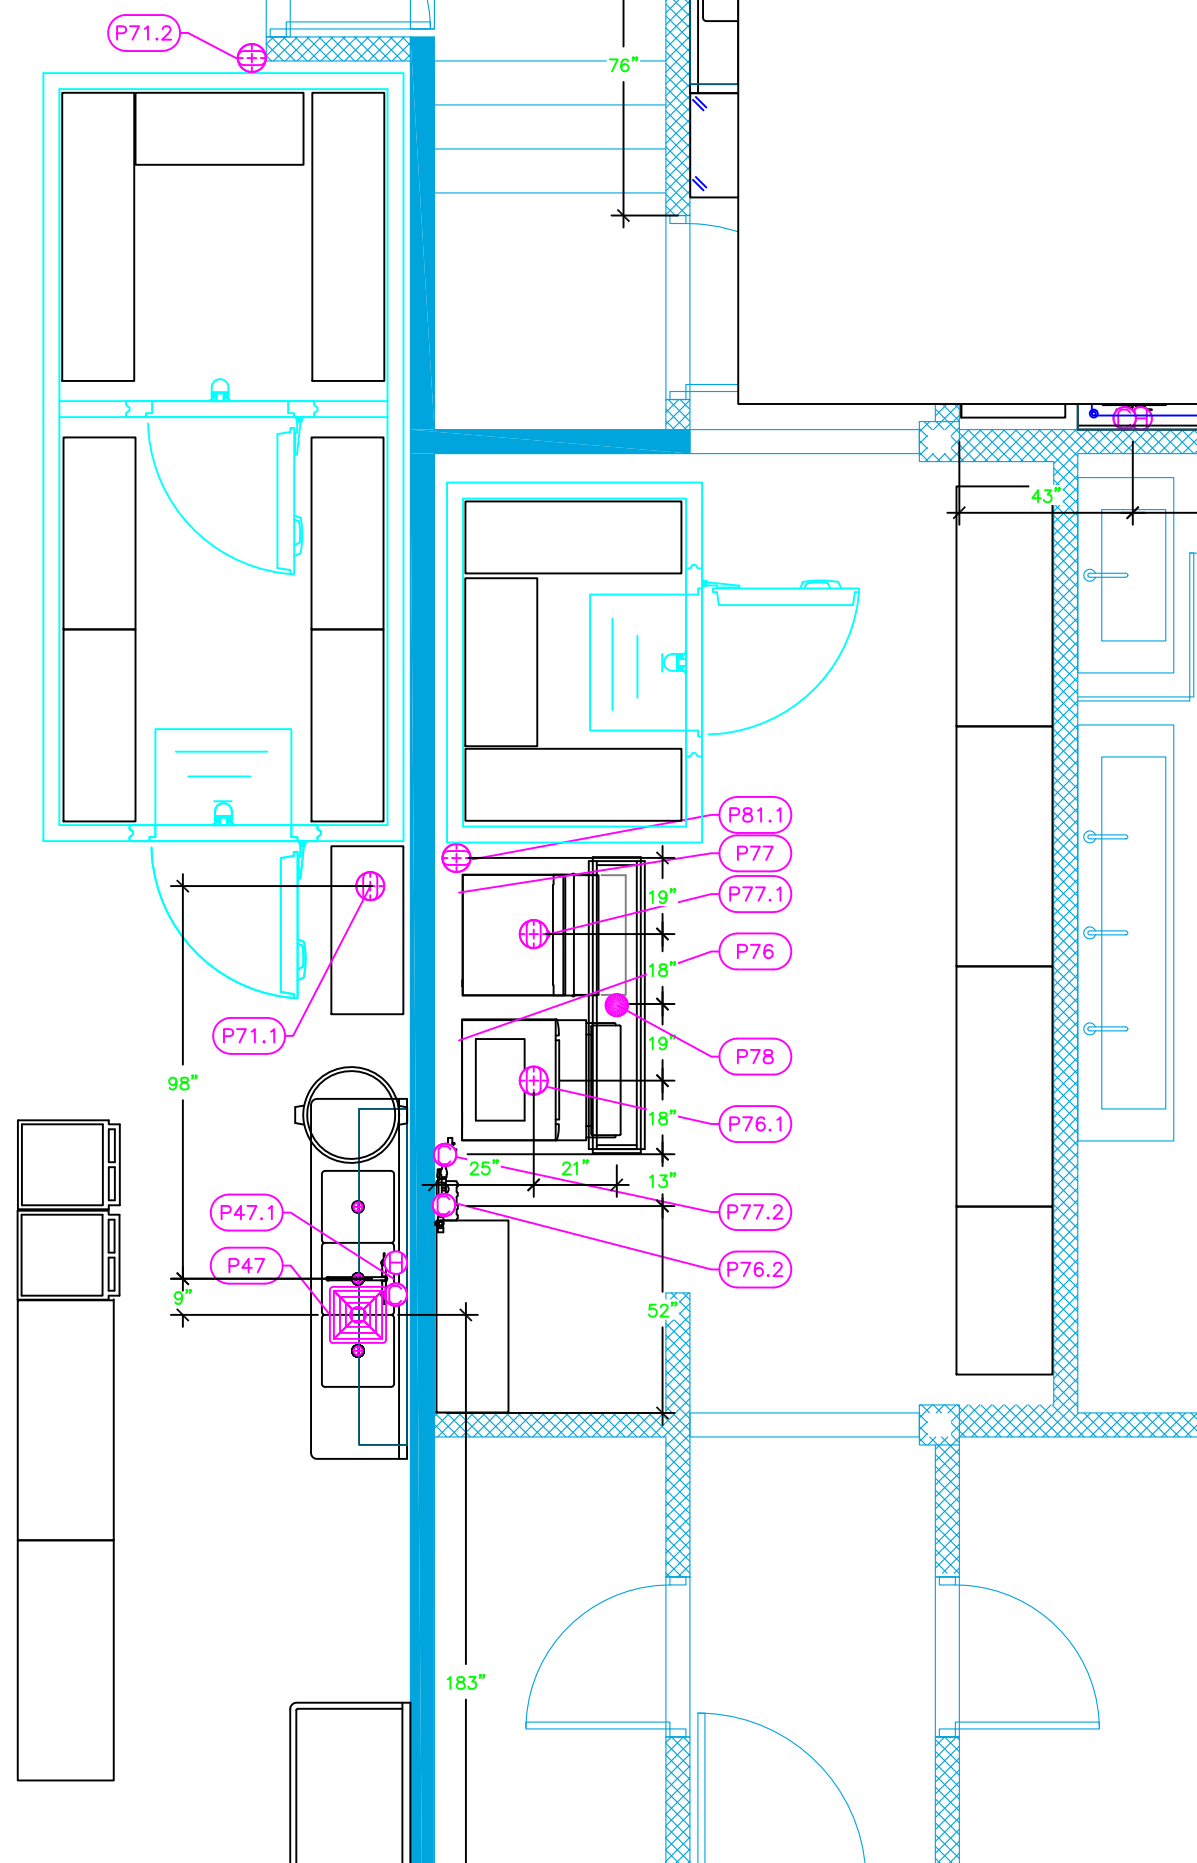

NOTE # P7
ALL WASTE LINES AND
CONDENSATE LINES TO BE EXTEND
FROM EQUIPMENT TO FLOOR
DRAINS BY PLUMBING CONTRACTOR

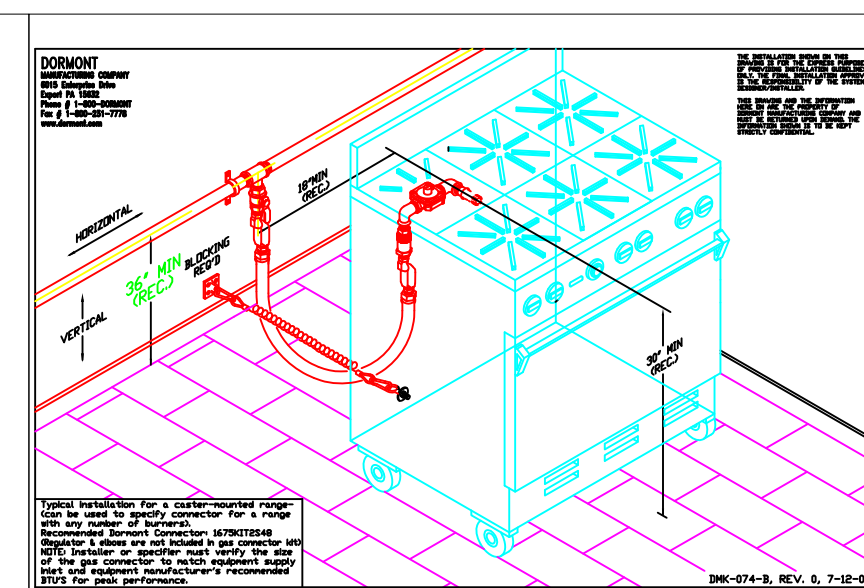

All Dimensions to be verified on the job site.
Actual locations for floor drains, and any ventilating equipment to be determined by Engineer.
Mechanical, Plumbing & Electrical to be checked and verified by Customers MEP Engineer.
Remote Condensing Units to be located by Architect.
Exhaust & Supply fans to be located by Architect.

INTERNATIONAL INC.

Sheet

FF-4.0

Rok Hotel Kingston
Outdoor Bar & Grill
Kingston, Jamaica

TAPESTRY
COLLECTION
BY HILTON™




2055 W 73rd Street, Miami, FL 33016
Ph:(305)826-8696 Fax:(305)826-9131

8	Updated Background From Architect with Bar Change	5-24-20
9	Updated Background From Architect with Bar Change	10-29-20
10	Moved Garde Manger, Added Chef's office, New Bev Room	3-10-21
11	Added Back in MEP Information. Final	3-18-21
No.	Revision/Issue	Date

Date
March 18, 2021
Drawn By
Dayne Gauntlett
Scale
1/4" = 1'0"

Sheet
FF-4.1

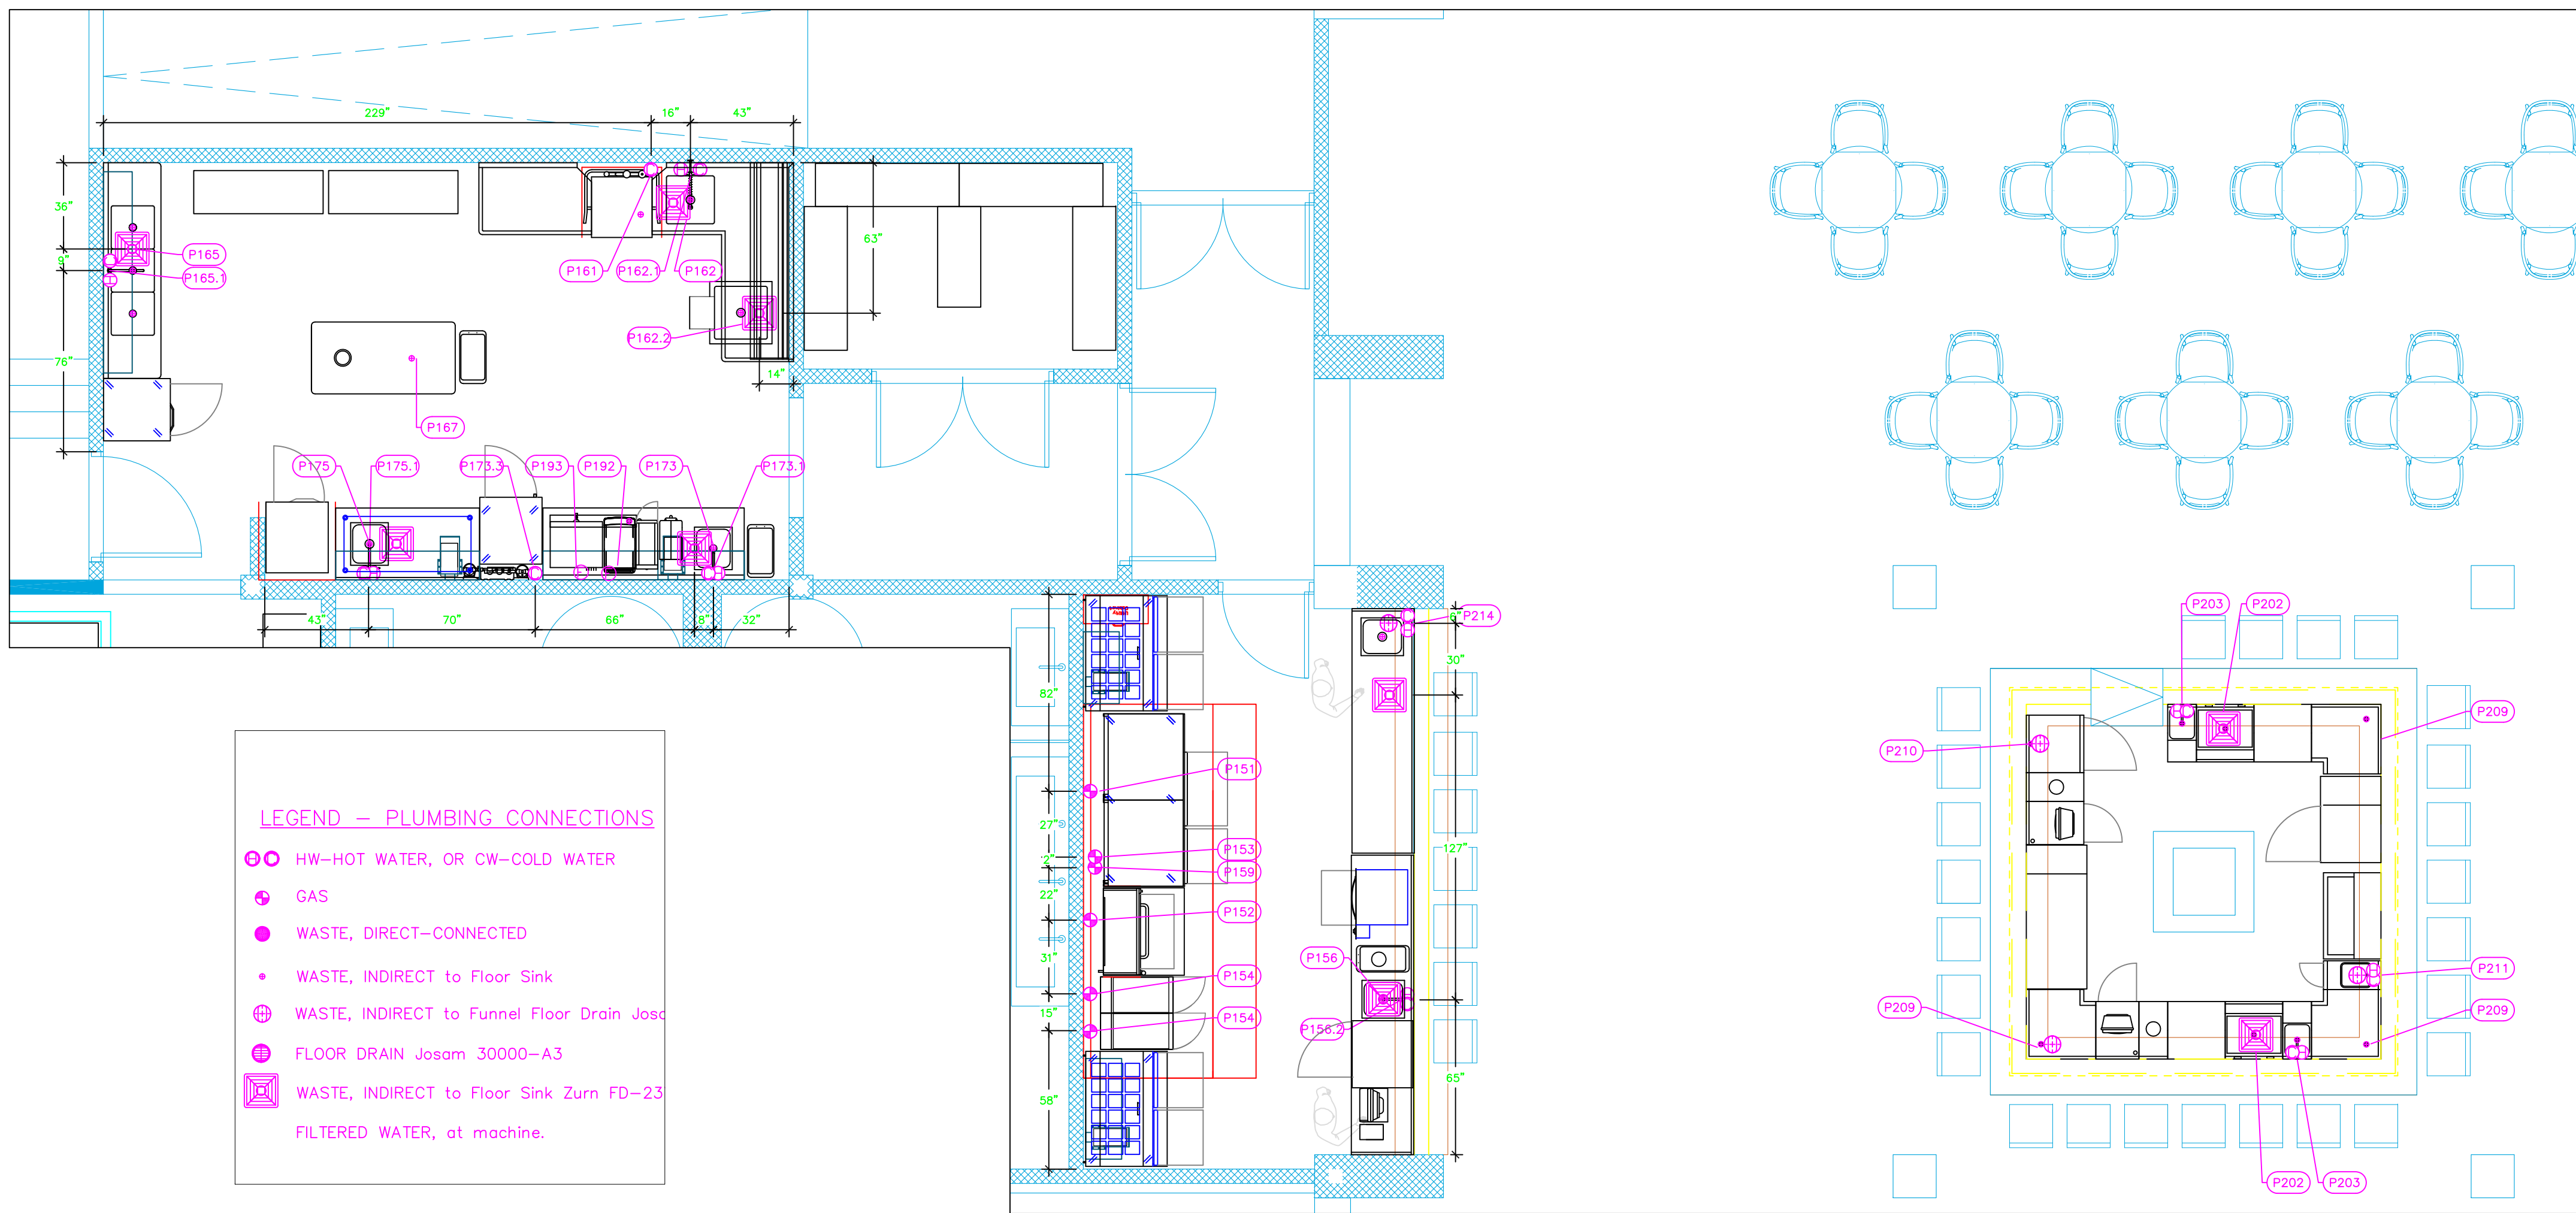



PLUMBING SCHEDULE									
ITEM NO.	DESCRIPTION	COLD WATER SIZE	HOT WATER SIZE	H&C Rough-In	DIRECT WASTE SIZE	DIRECT WASTE AFF	INDIRECT WASTE SIZE	GAS SIZE(IN)	GAS MBTU
104	Ice Bin						1-1/2"		1
106	Waste Cabinet	3/8"	3/8"				1-1/2"		1
151	Charbroiler, Gas, Outdoor Grill							3/4"	120.0
152	Range, 36", 6 Open Burners							3/4"	243.0
153	Gas Countertop Griddle							3/4"	90.0
154	Gas Floor Fryer							3/4"	122.0
156	Work Table, Cabinet Base Hinged Doors								1
	Weld-In Sink						1-1/2"		1
156.2	Deck Mount Faucet	1/2"	1/2"	12"					1
159	Salamander Broiler, Gas							3/4"	40.0
161	Dishwasher, Door Type, Ventless	3/4"		12"			1-1/2"		1
162	Dishtable, Soiled "L" Shaped						1-1/2"		1
162.1	Pre-Rinse Faucet Assembly	1/2"	1/2"	12"					1
162.2	Soak Sink						2"		1
165	Three (3) Compartment Sink						(3) 1-1/2"		1
165.1	Wall / Splash Mount Faucet	1/2"	1/2"	12"					1
167	Dishtable Sorting Table						2"		1
173	Beverage Counter						1-1/2"		1
173.1	Wall / Splash Mount Faucet	1/2"	1/2"	12"					1
173.3	Water Filtration System, for Multiple Applications	3/4"		12"					1
175	Work Table, Stainless Steel Top								1
	Weld-In Sink						1-1/2"		1
175.1	Deck Mount Faucet	1/2"	1/2"	12"					1
192	Espresso Cappuccino Machine	3/8"		n/a					1
193	Coffee Brewer	3/8"		n/a					1
202	Ice Bin						1-1/2"		2
203	Blender Station	3/8"	3/8"	12"			1-1/2"		2
209	Corner Angle Filler						1-1/2"		3
210	Drainboard						1/2"		1
211	Waste Cabinet	3/8"	3/8"				1-1/2"		1
214	Table	1/2"	1/2"	12"			1-1/2"		1

NOTE # P4
ALL NATIONAL, STATE, AND LOCAL CODES SHALL APPLY

NOTE # P5
ALL PLUMBING CONNECTIONS TO BE EXTENDED AND INTERCONNECTED TO EQUIPMENT AND ALL HARDWARE REQUIRED TO BE PROVIDED BY PLUMBING CONTRACTOR


NOTE # P6
PLUMBING CONTRACTOR TO VERIFY THAT ALL EQUIPMENT IS INSTALLED WITH THE APPROPRIATE GAS PRESSURE AND REGULATORS





NOTE # P7
ALL WASTE LINES AND CONDENSATE LINES TO BE EXTEND FROM EQUIPMENT TO FLOOR DRAINS BY PLUMBING CONTRACTOR.

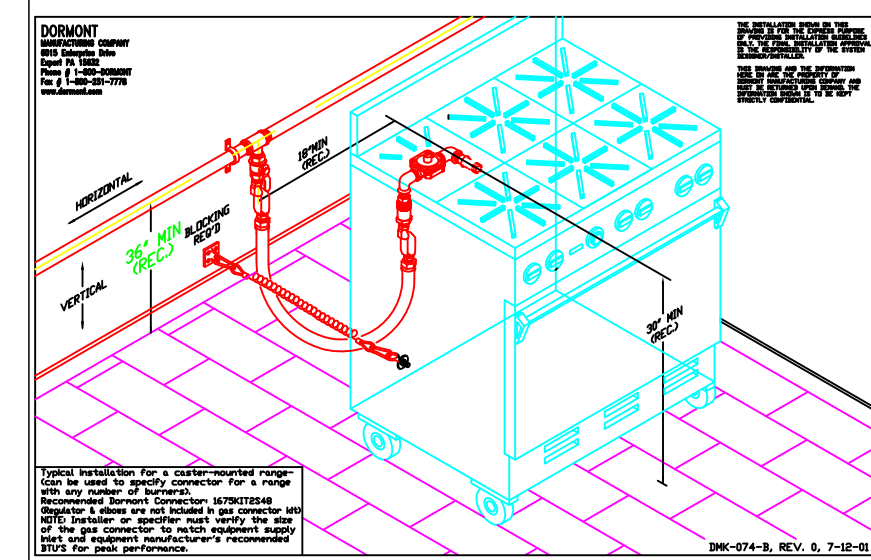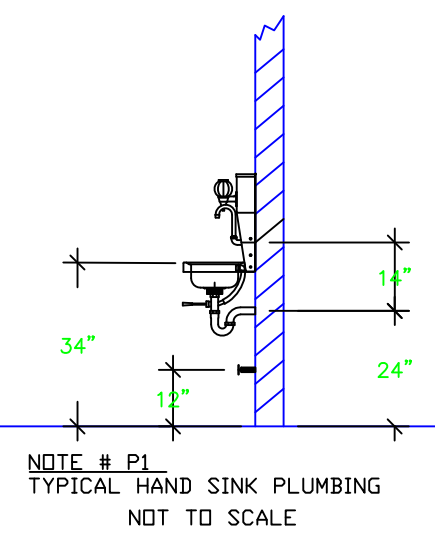

Equipment PLUMBING Service Requirements

All Dimensions to be verified on the job site.
Actual locations for floor drains, and any ventilating equipment to be determined by Engineer.
Mechanical, Plumbing & Electrical to be checked and verified by Customers MEP Engineer.
Remote Condensing Units to be located by Architect.
Exhaust & Supply fans to be located by Architect.

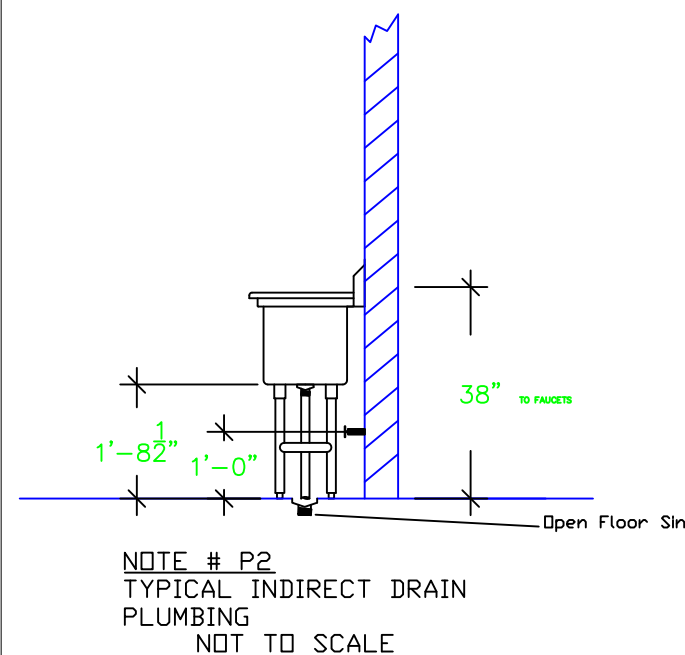

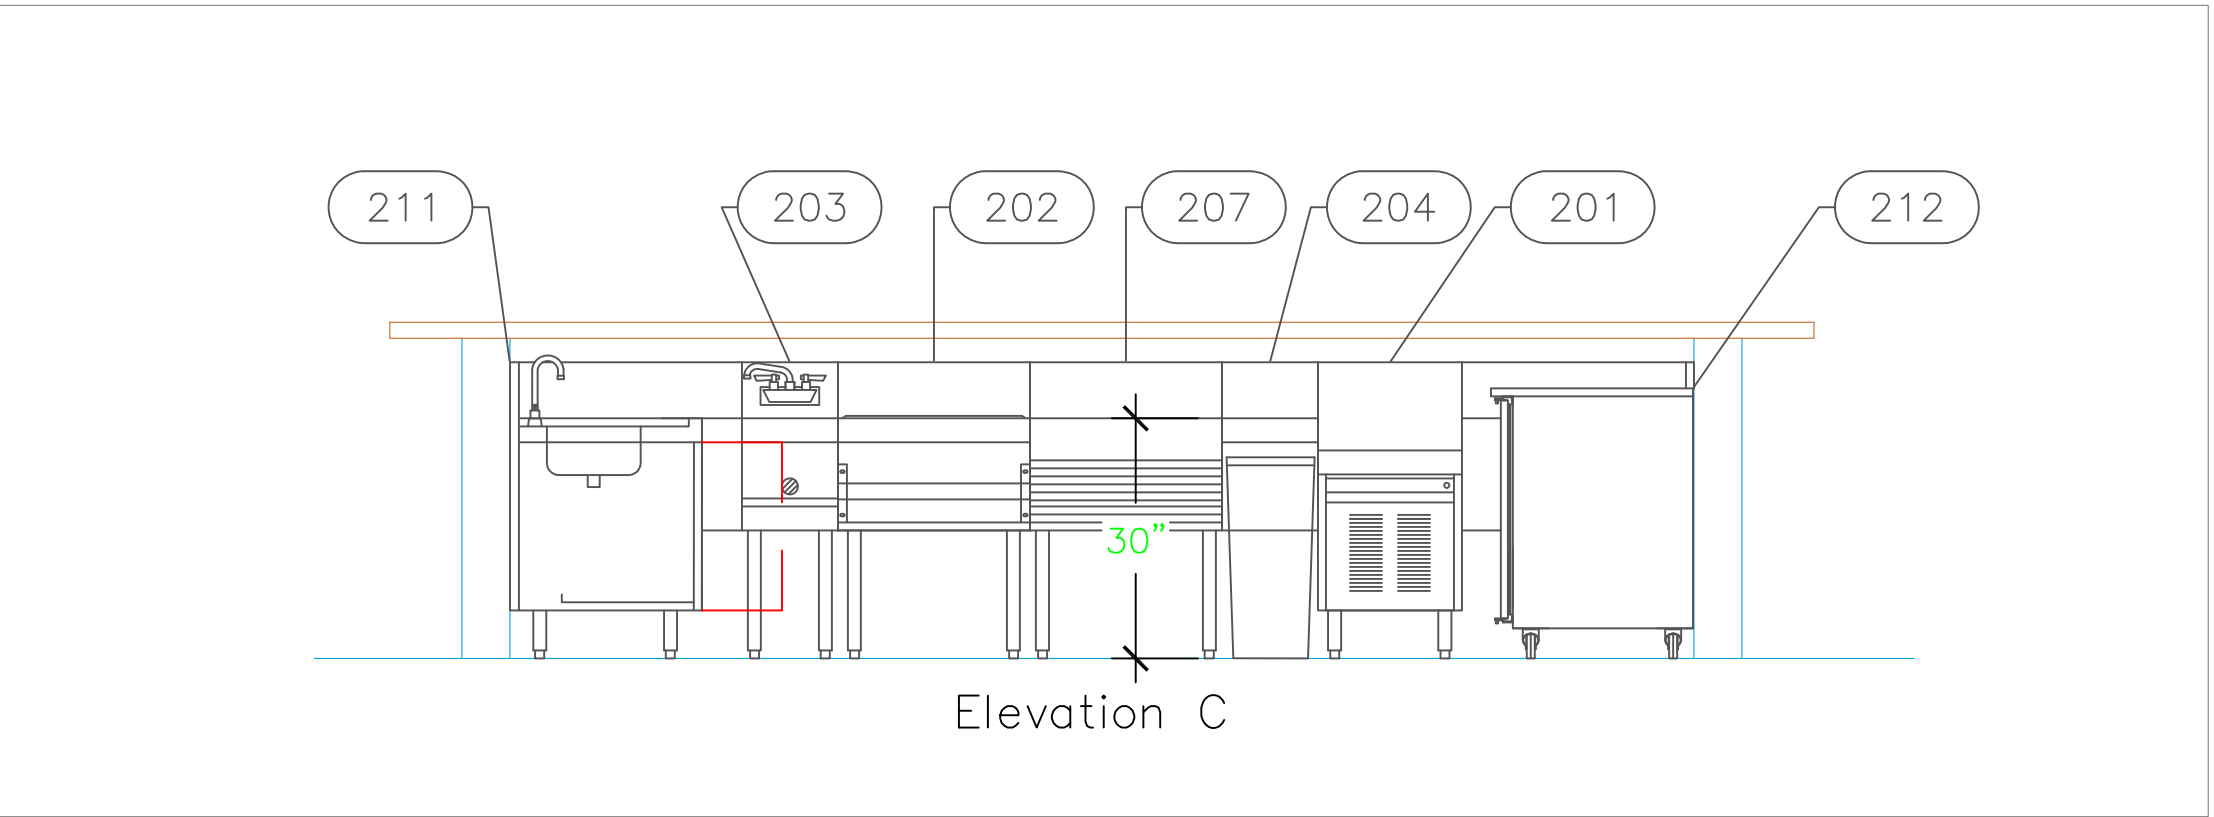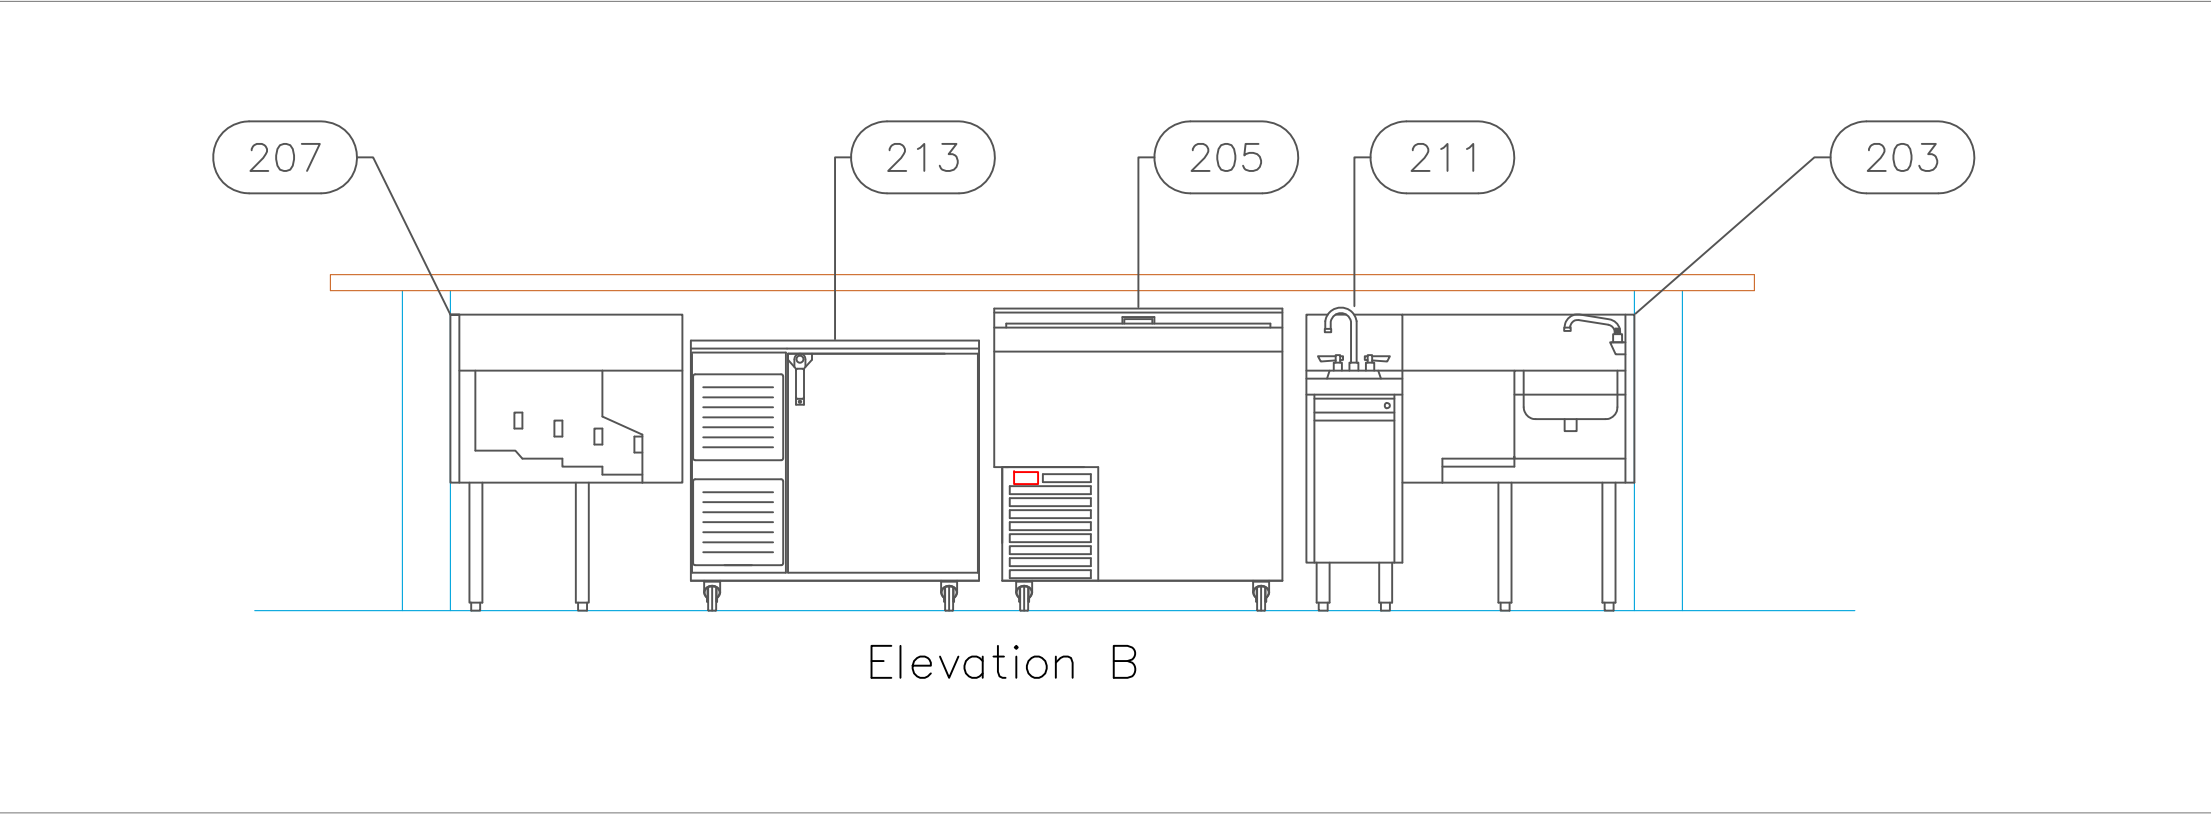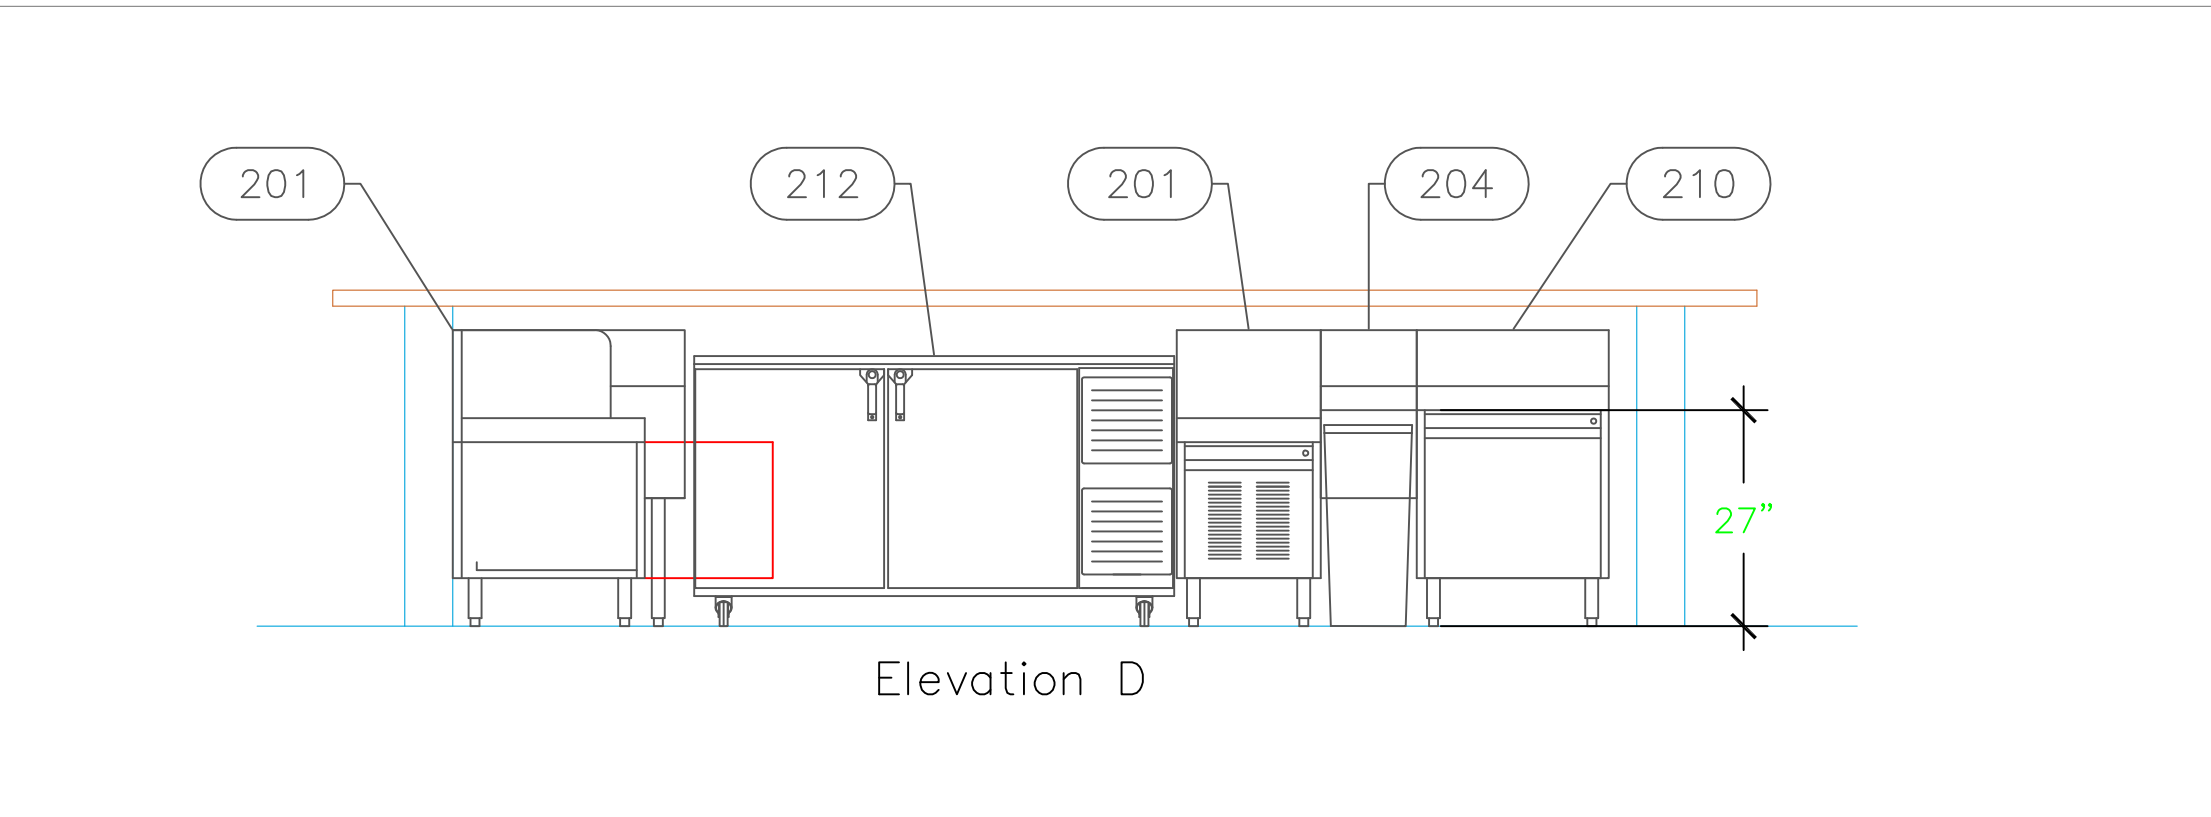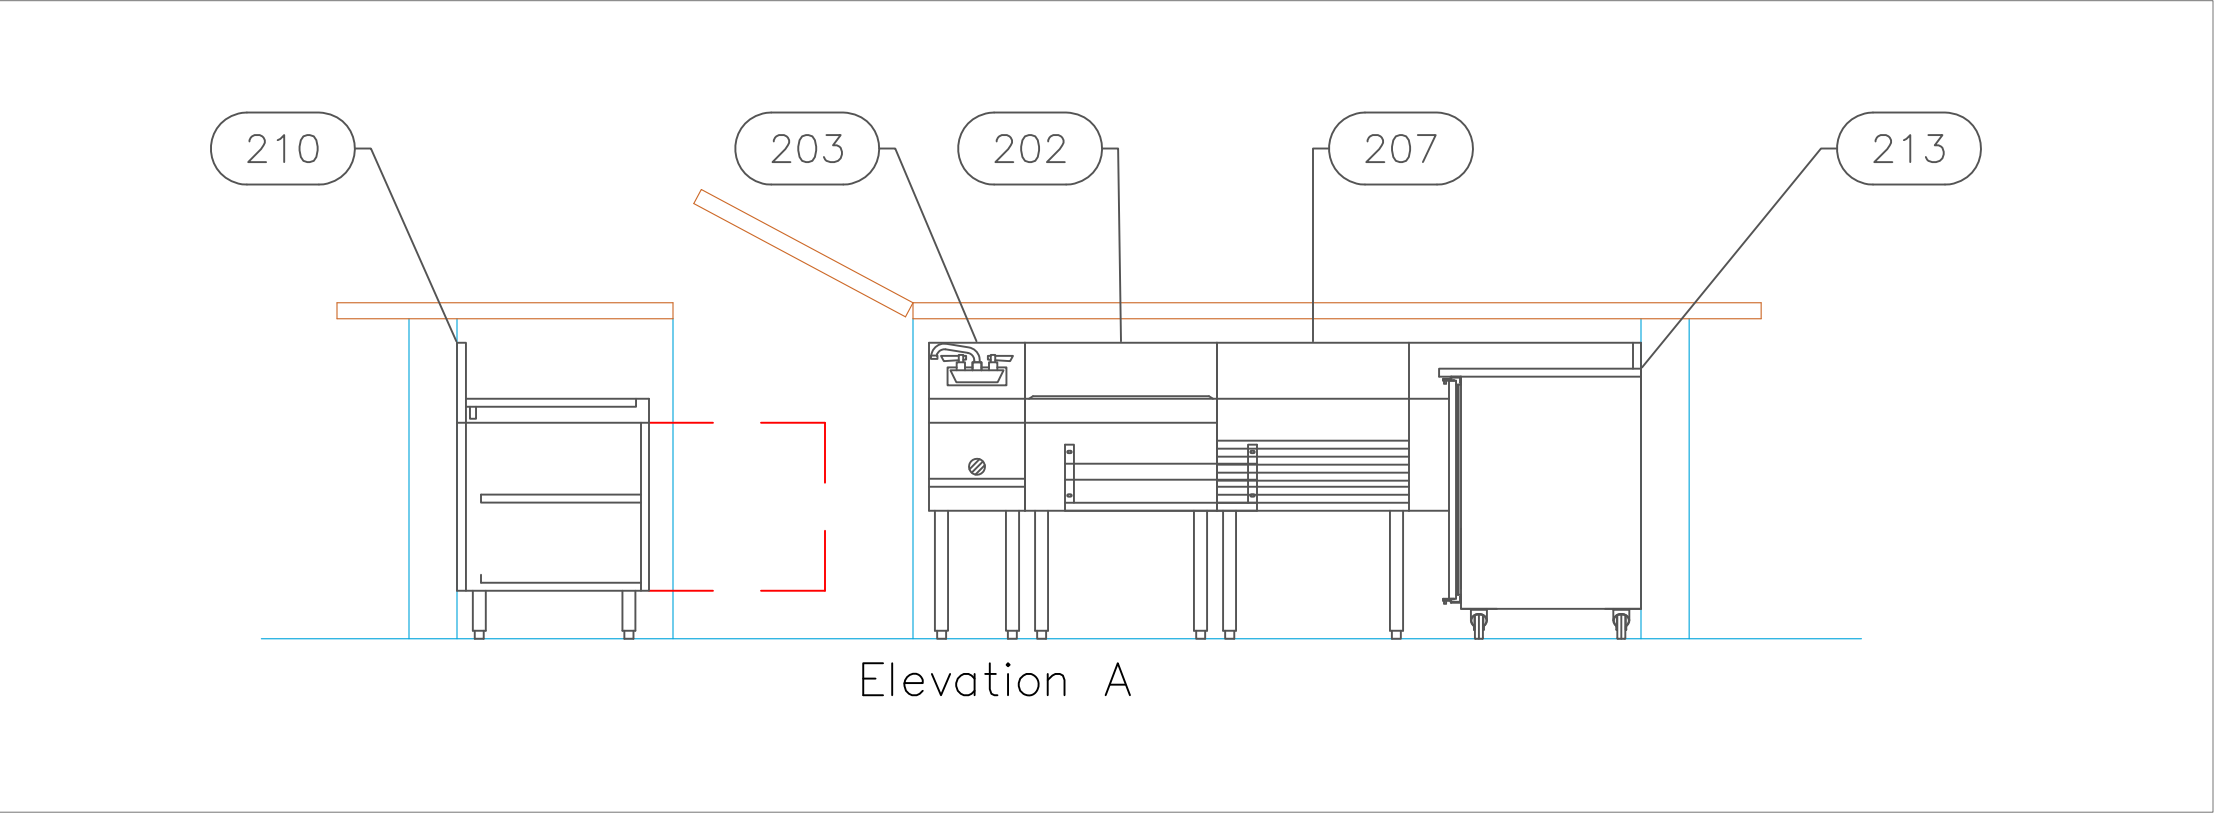

Rok Hotel Kingston

Outdoor Bar & Grill

Kingston, Jamaica

TAPESTRY

COLLECTION

BY HILTON™

uni-source

SUPPLY

INTERNATIONAL INC.

2055 W 73rd Street, Miami, FL 33016
Ph: (305) 826-8696 Fax: (305) 826-9131

8	Updated Background from Architect with Bar Change	6-24-20
9	Updated Background from Architect with Bar Change	10-29-20
10	Moved Garde Manger, Added Chef's office, New Bev Room	3-10-21
11	Added Back in MEP Information. Final	3-18-21
No.	Revision/Issue	Date

Date

March 18, 2021

Drawn By

Dayne Gauntlett

Scale

1/2" = 1'

Sheet

FF-5.0

HOOD INFORMATION - Job#3696884

HOOD NO.	TAG	MODEL	LENGTH	MAX. COOKING TEMP.	TYPE	APPLIANCE DUTY	DESIGN CFM/Ft	TOTAL EXH. CFM	EXHAUST PLENUM RISER(S)					TOTAL SUPPLY CFM	HOOD CONSTRUCTION	HOOD CONFIG.	
									WIDTH	LENG.	HEIGHT	DIA.	CFM	VEL.	S.P.	END TO END	RDV
1	58	6024 VHB	4' 6"	700 Deg.	II	N/A	150	675	4"	10"	675	1238	-0.114'	0	430 SS 100%	ALONE	ALONE
2	45	4824 VHB-G	8' 0"	700 Deg.	II	N/A	150	1200	4"	10"	600	1100	-0.090'	0	304 SS 100%	ALONE	ALONE
3	1	5424 ND-2-PSP-F	10' 3"	600 Deg.	I	Heavy	255	2614	4"	16"	2614	1872	-0.995'	2091	430 SS Where Exposed	LEFT	ALONE
4	1	5424 ND-2-PSP-F	10' 6"	600 Deg.	I	Heavy	255	2678	4"	16"	2678	1918	-1.044'	2142	430 SS Where Exposed	RIGHT	ALONE
5	155	5424 ND-2-PSP-F	12' 6"	600 Deg.	I	Heavy	275	3438	4"	18"	3438	1946	-1.250'	2750	430 SS Where Exposed	ALONE	ALONE

HOOD INFORMATION

HOOD NO.	TAG	FILTER(S)				LIGHT(S)				UTILITY CABINET(S)							
		TYPE	QTY.	HEIGHT	LENGTH	EFFICIENCY @ 7 MICRONS	QTY.	TYPE	WIRE GUARD	LOCATION	SIZE	TYPE	SIZE	ELECTRICAL MODEL #	SWITCHES QUANTITY	FIRE SYSTEM HANGING PIPING	HOOD WEIGHT
1	58						0									NO	212 LBS
2	45						0									YES	264 LBS
3	1	Captrate Solo Filter	7	20"	16"	85% See Filter Spec.	3	L55 Series E26	NO							YES	584 LBS
4	1	Captrate Solo Filter	7	20"	16"	85% See Filter Spec.	3	L55 Series E26	NO	Right	12"x54"x24"	Ansul R102	3.0/3.0	DCV-2111	1 Light 1 Fan	YES	781 LBS
5	155	Captrate Solo Filter	9	20"	16"	85% See Filter Spec.	4	L55 Series E26	NO	Wall Mnt	12"x54"x24"	Ansul R102	3.0/3.0	DCV-1111	1 Light 1 Fan	YES	771 LBS

HOOD OPTIONS

HOOD NO.	TAG	OPTION
1	58	FIELD WRAPPER 18.00" High Front, Right
2	45	FIELD WRAPPER 18.00" High Front, Left, Right
3	1	BACKSPASH 80.00" High X 264.00" Long 430 SS Vertical LEFT END STANDOFF 3" Wide 54" Long Insulated LEFT SIDESPLASH 80.00" High X 54.00" Long 430 SS Vertical
4	1	FIELD WRAPPER 18.00" High Front, Right FIELD WRAPPER 18.00" High Front, Right BACKSPASH 80.00" High X 150.00" Long 430 SS Vertical RISER SENSOR INSTALL 3IN DBL RIGHT VERTICAL END PANEL 27" Top Width, 21" Bottom Width, 80" High Insulated 430 SS
5	155	

PERFORATED SUPPLY PLENUM(S)

HOOD NO.	TAG	POS.	LENGTH	WIDTH	HEIGHT	TYPE	RISER(S)			
							WIDTH	LENG.	DIA.	S.P.
3	1	Front	126"	18"	6"	MJA	12"	28"	695	0.183"
						MJA	12"	28"	695	0.183"
						MJA	12"	28"	695	0.183"
						MJA	12"	28"	714	0.192"
4	1	Front	138"	18"	6"	MJA	12"	28"	714	0.192"
						MJA	12"	28"	714	0.192"
						MJA	12"	28"	687	0.179"
						MJA	12"	28"	687	0.179"
5	155	Front	150"	18"	6"	MJA	12"	28"	687	0.179"
						MJA	12"	28"	687	0.179"

PATENT NUMBERS

AC-PSP (United States) - US Patent 7963830 B2
AC-PSP Wall (Canada) - CA Patent 2820509
AC-PSP Island (Canada) - CA Patent 2520330

SPECIFICATION: CAPTRATE® GREASE-STOP® SOLID FILTER

THE CAPTRATE GREASE-STOP SOLID FILTER IS A SINGLE-STAGE FILTER FEATURING A UNIQUE S-BAFFLE DESIGN IN CONJUNCTION WITH A SLOTTED REAR BAFFLE DESIGN, TO DELIVER EXCEPTIONAL FILTRATION EFFICIENCY.


FILTER IS STAINLESS STEEL CONSTRUCTION, AND SIZED TO FIT INTO STANDARD 2-INCH DEEP HOOD CHANNEL(S).

UNITS SHALL INCLUDE STAINLESS STEEL HANDLES AND A FASTENING DEVICE TO SECURE THE TWO COMPONENTS WHEN ASSEMBLED.

GREASE EXTRACTION EFFICIENCY PERFORMANCE SHALL REMOVE AT LEAST 75% OF GREASE PARTICLES FIVE MICRONS IN SIZE, AND 85% GREASE PARTICLES SEVEN MICRONS IN SIZE AND LARGER, WITH A CORRESPONDING PRESSURE DROP NOT TO EXCEED 1.0 INCHES OF WATER GAUGE.

THE CAPTRATE GREASE-STOP SOLID WAS TESTED TO ASTM STANDARD ASTM F2519-05.

EFFICIENCY VS. PARTICLE DIAMETER


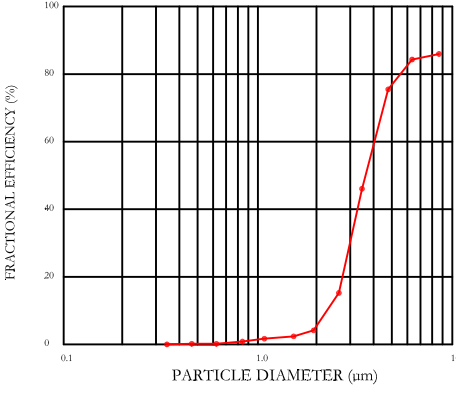


CAPTRATE FILTERS ARE BUILT IN COMPLIANCE WITH:

NFPA #96
NSF STANDARD #1046
INT. MECH. CODE (IMC)
ULC-S649



PRESSURE DROP VS. FLOW RATE

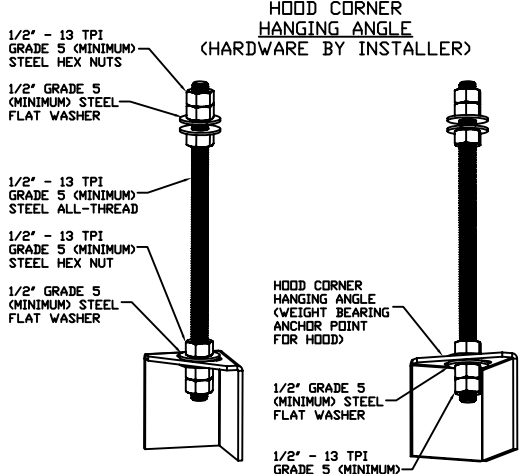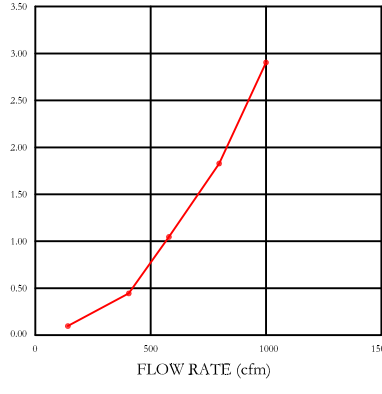


ASSEMBLY INSTRUCTIONS

HANGING ANGLE MUST BE SUPPORTED WITH 1/2" - 13 TPI GRADE 5 (MINIMUM) ALL-THREAD SANDWICH HANGING ANGLES AND CEILING ANCHOR POINTS WITH 1/2" GRADE 5 (MINIMUM) STEEL FLAT WASHERS AND 1/2" - 13 TPI GRADE 5 (MINIMUM) HEX NUTS AS SHOWN. MUST USE DOUBLED HEX NUT CONFIGURATION BENEATH HOOD HANGING ANGLES AND ABOVE CEILING ANCHORS. MAINTAIN 1/4" OF EXPOSED THREADS BENEATH BOTTOM HEX NUT. TORQUE ALL HEX NUTS TO 57 FT-LBS.

Fire System Information - Job#3696884


FIRE SYSTEM NO.	Tag	TYPE	SIZE	FLOW POINTS	INSTALLATION	
					SYSTEM	LOCATION ON HOOD
1	1	Ansul R102	3.0/3.0/3.0	6	Fire Cabinet Right	Right
2	155	Ansul R102	3.0/3.0	4	Fire Cabinet Right	Right

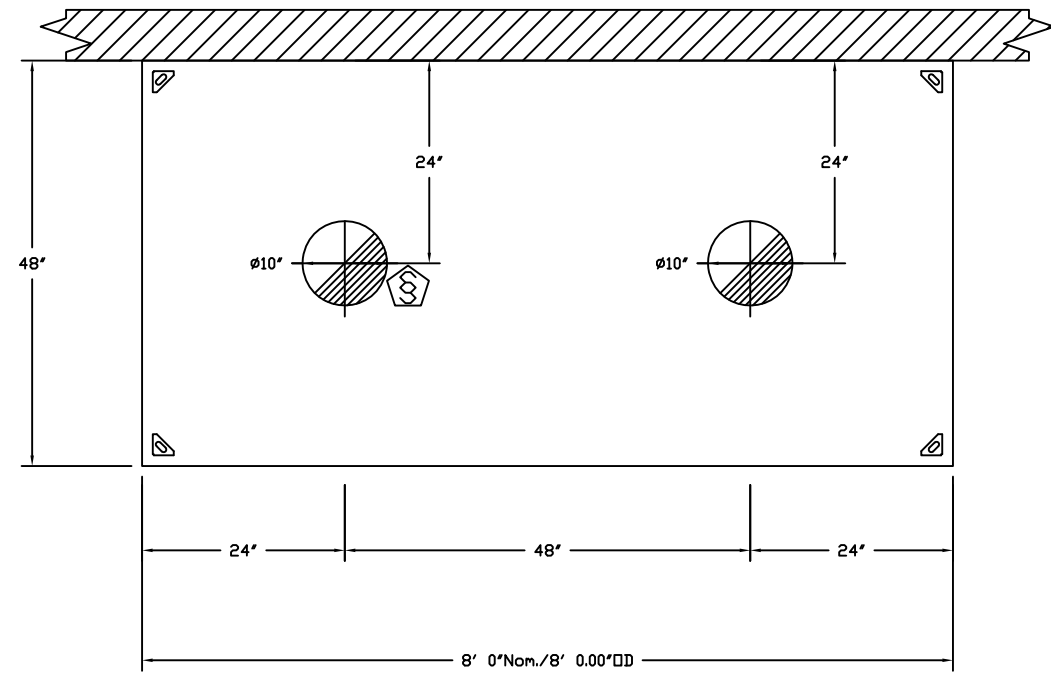


PLAN VIEW - Hood #2 (45)
8' 0.00" LONG 4824VHB-G

CAPTIVE-AIRE HOODS ARE BUILT IN COMPLIANCE WITH
UL 710 AND NFPA 96
AND ARE RECOGNIZED BY ONE OR MORE OF THE FOLLOWING:


ETL SANITATION LISTED
ETL LISTED FILE# 3054804-001

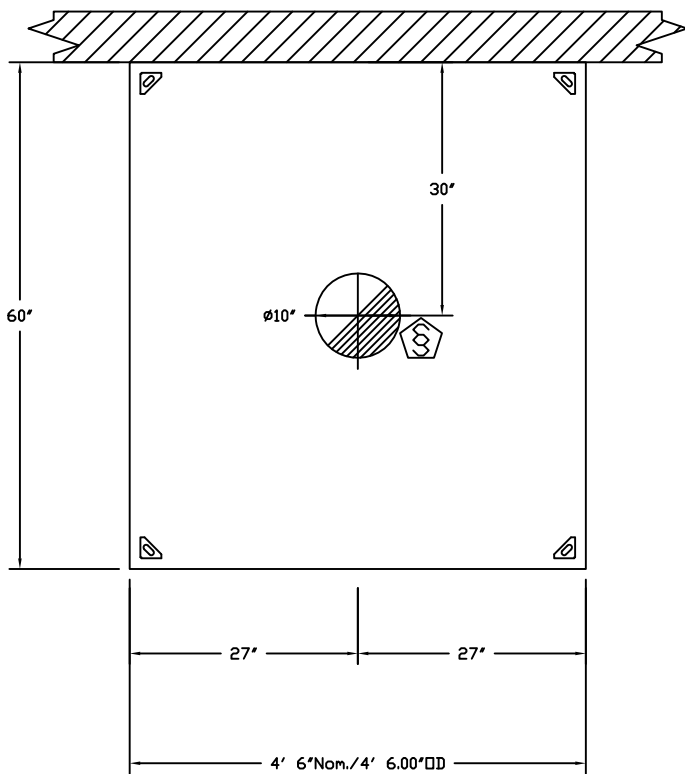

PLAN VIEW - Hood #1 (58)
4' 6.00" LONG 6024VHB

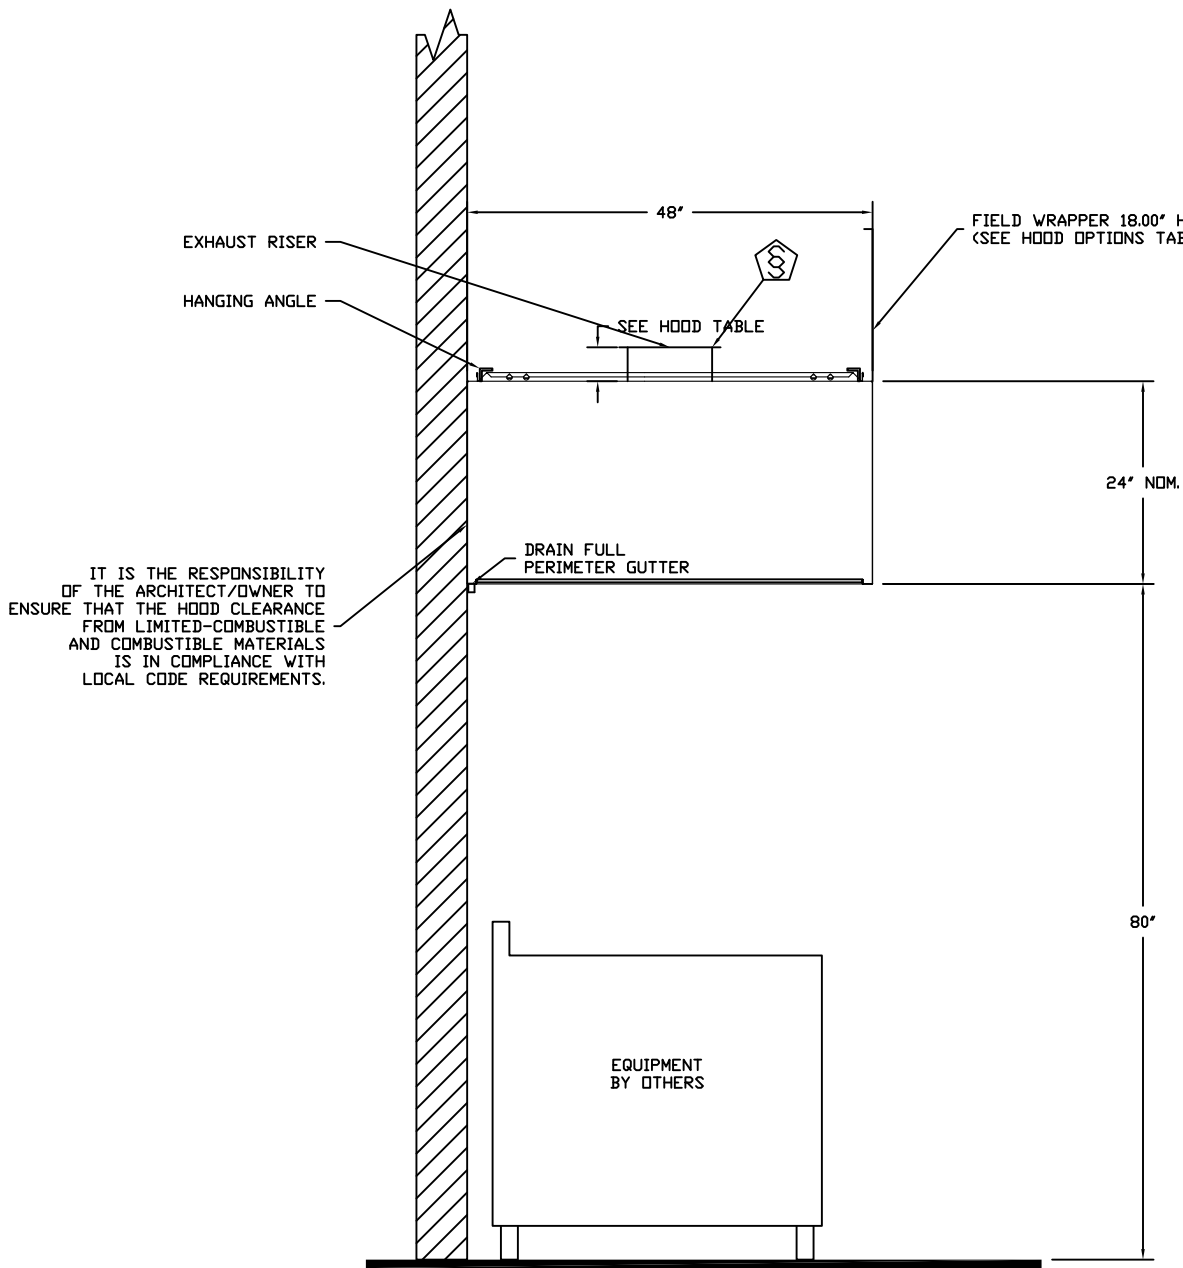

SECTION VIEW - MODEL 4824VHB-G
HOOD - #2 (45)

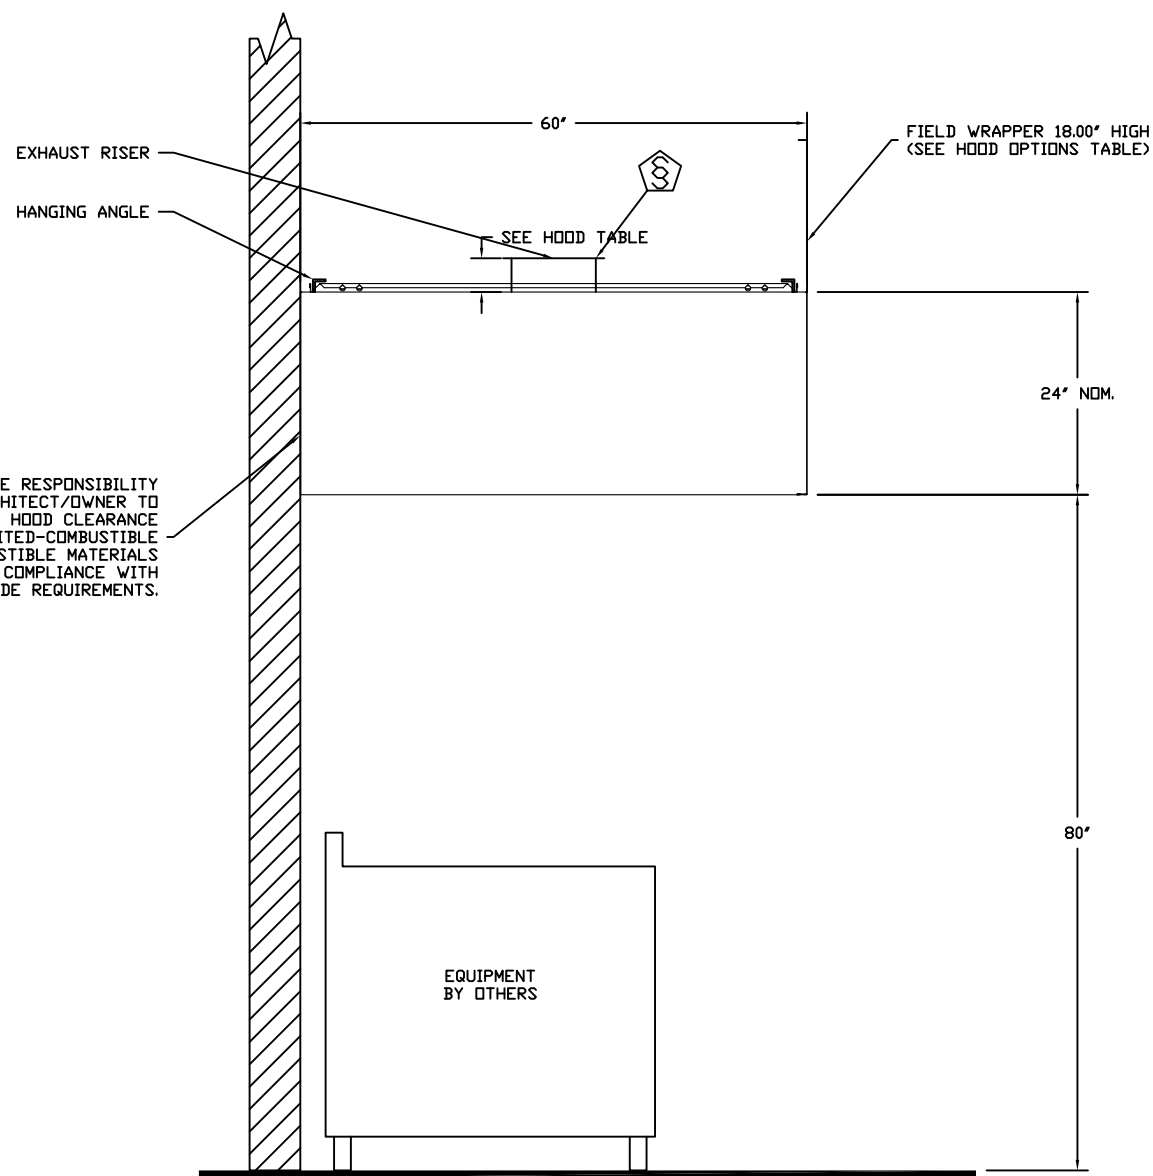

SECTION VIEW - MODEL 6024VHB
HOOD - #1 (58)

REVISIONS

NO.	DESCRIPTION	DATE
1		
2		
3		
4		
5		

CAPTIVE-AIRE

Advanced Hoods Systems, LLC

www.captiveaire.com

FL PHONE: FAX: EMAIL: roa140@captiveaire.com

HILTON TAPESTRY JAMAICA

JAMAICA, BWI

DATE: 4/8/2020

DWG.#: 3696884

DRAWN BY:

SCALE: 3/4" = 1'-0"

MASTER DRAWING

SHEET NO. 1

Rok Hotel Kingston
Main & Outdoor Grill
Kingston, Jamaica

TAPESTRY
COLLECTION
BY HILTON™


uni-source
SUPPLY
INTERNATIONAL INC.

2055 W 73rd Street, Miami, FL 33016
Ph:(305)826-8696 Fax:(305)826-9131

8	Updated Background from Architect with Bar Change	6-24-20
9	Updated Background from Architect with Bar Change	10-29-20
10	Moved Garde Manger, Added Chef's office, New Bev Room	3-10-21
11	Added Back in MEP Information. Final	3-18-21
No.	Revision/Issue	Date


Date
March 18, 2021
Drawn By
Dayne Gauntlett
Scale
NTS

Sheet
FF-6.0

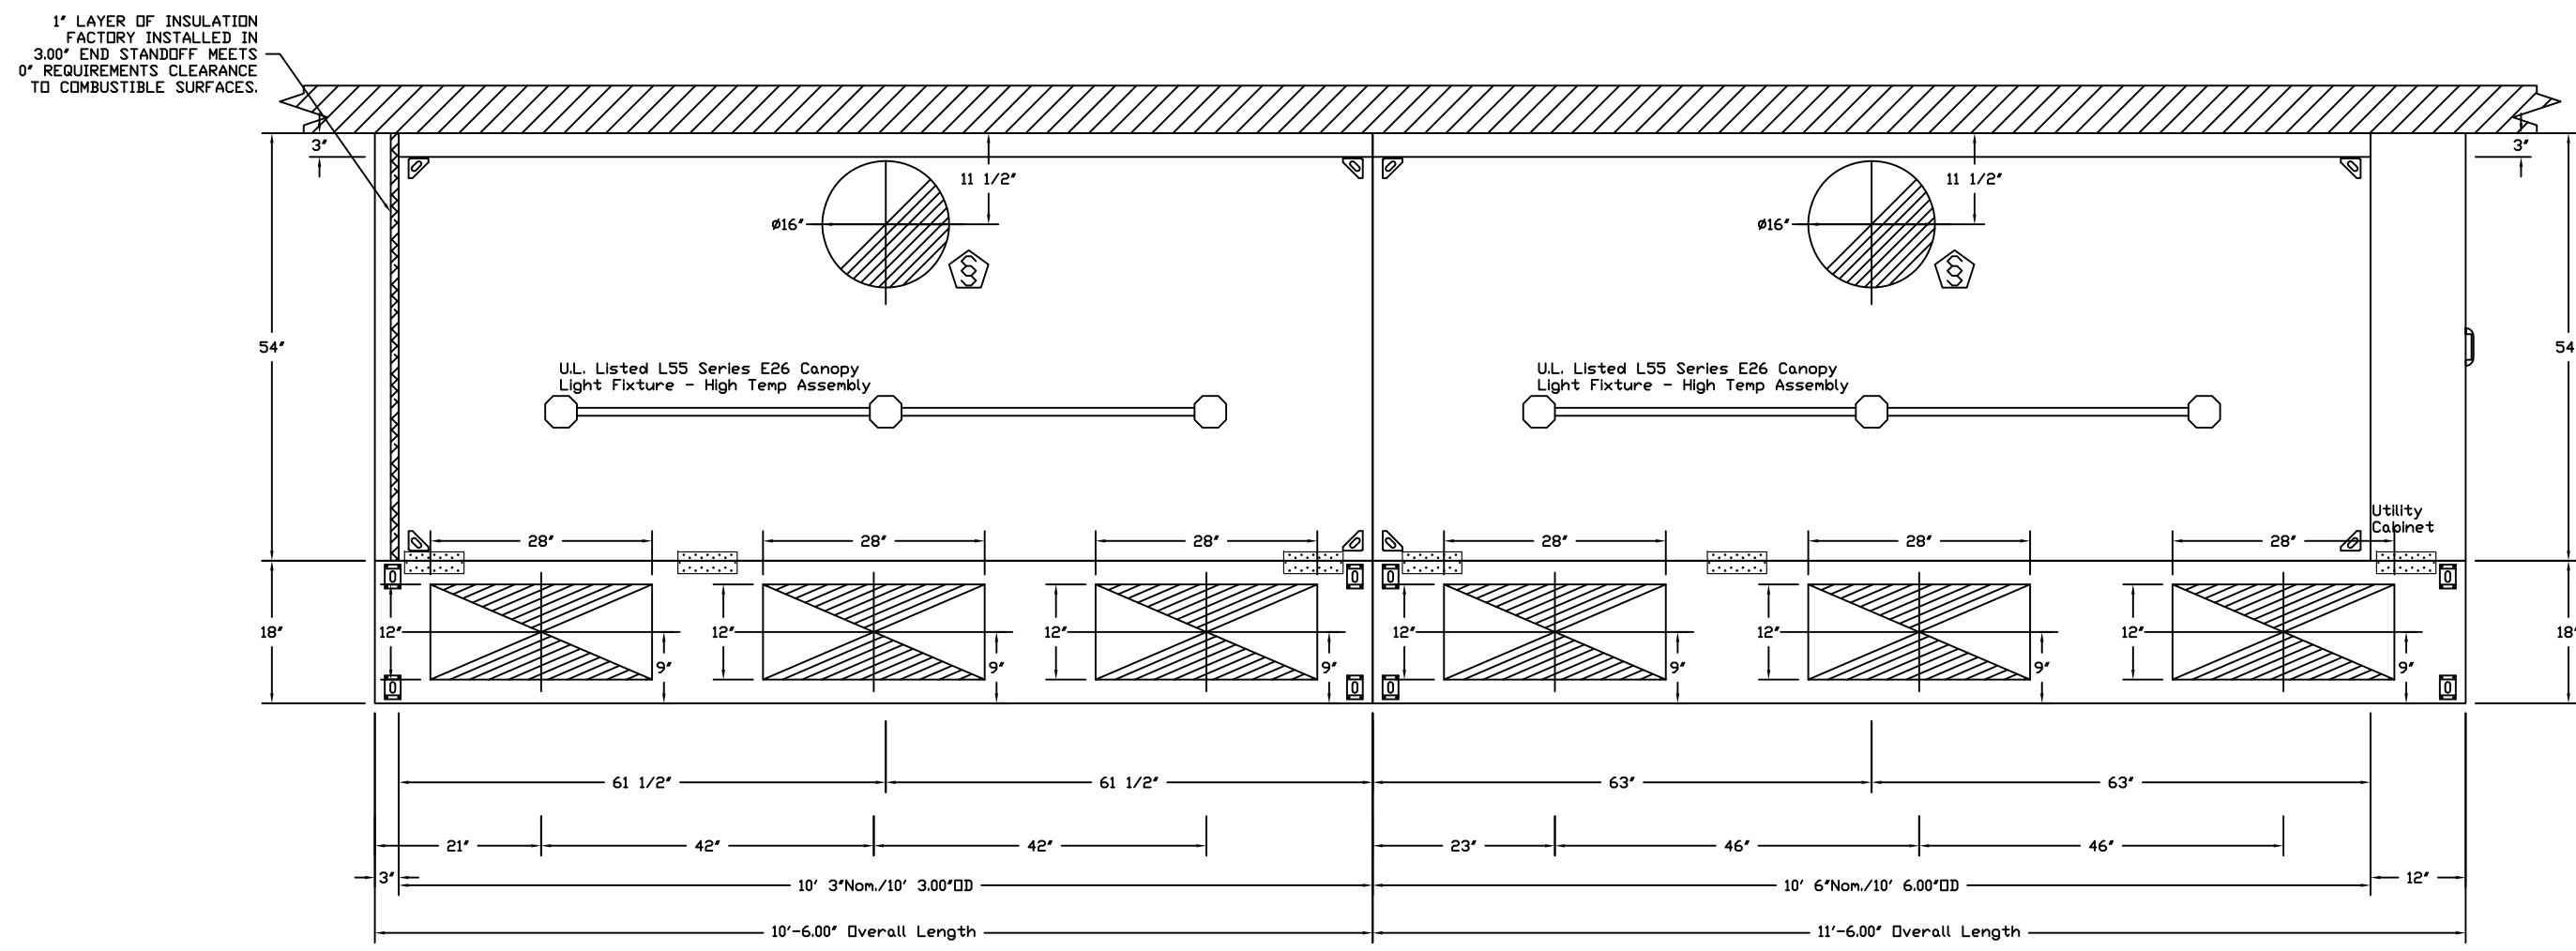


PLAN VIEW - Hood #3 (1)
10' 3.00' LONG 5424ND-2-PSP-F


PLAN VIEW - Hood #4 (1)
10' 6.00' LONG 5424ND-2-PSP-F

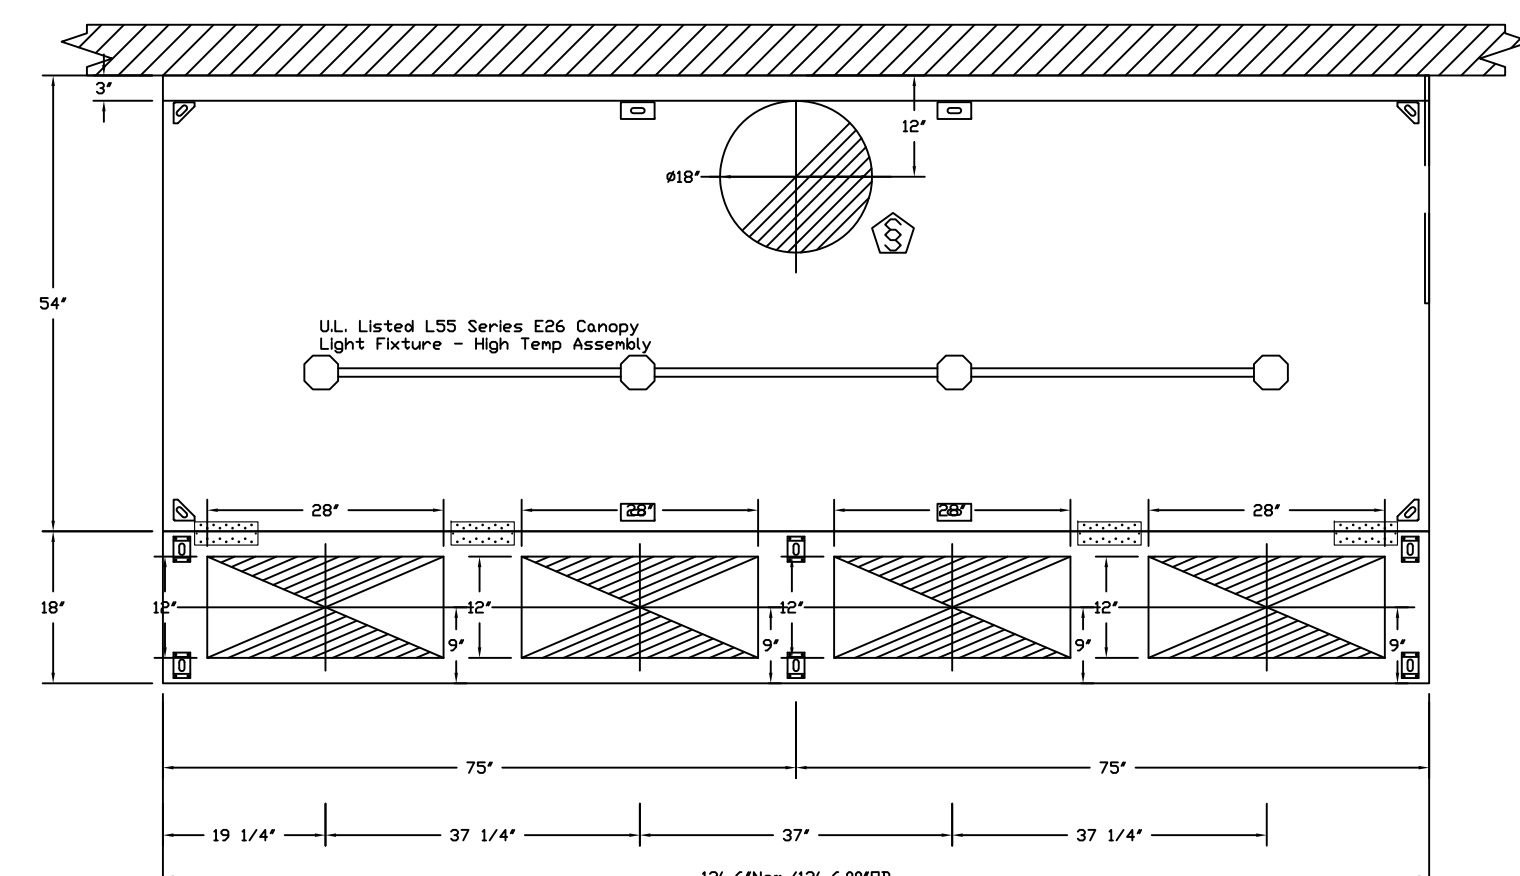

PLAN VIEW - Hood #5 (155)
12' 6.00' LONG 5424ND-2-PSP-F
NOTE: Additional hanging angles provided for hoods 12' and longer.

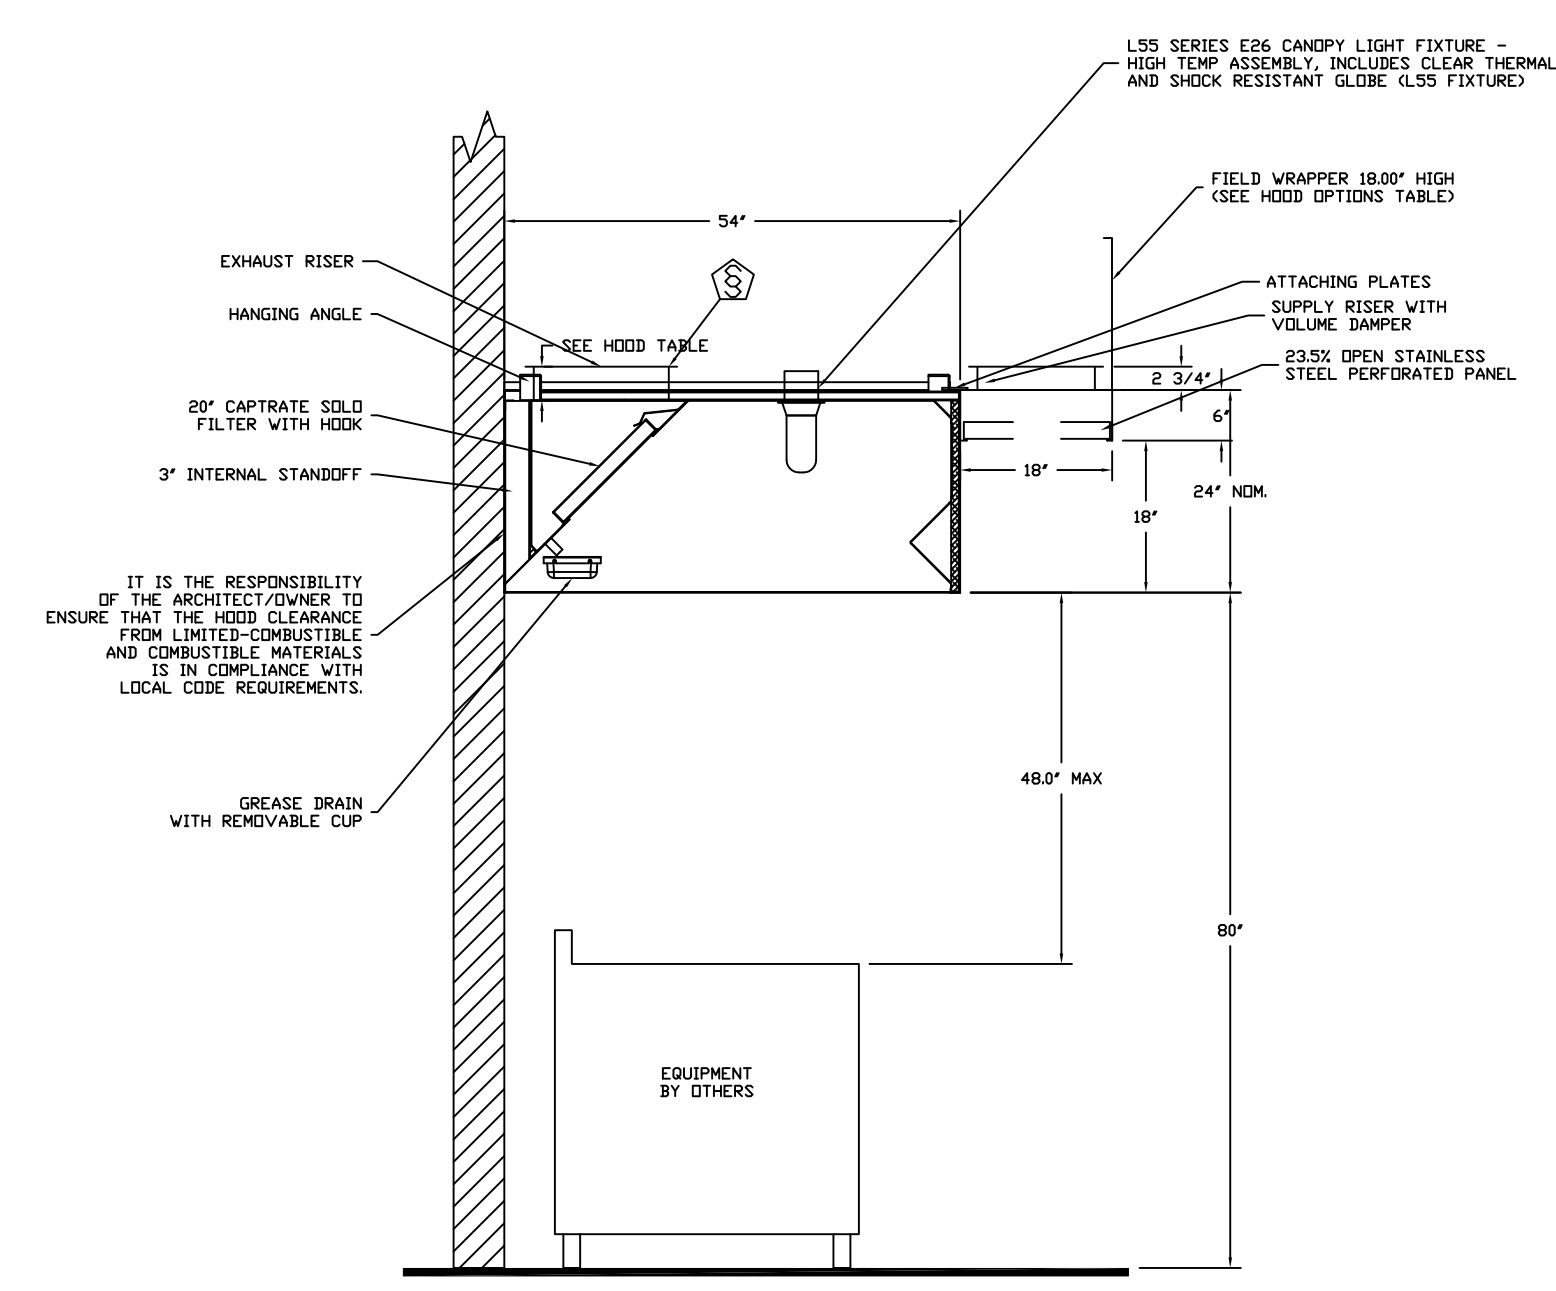

SECTION VIEW - MODEL 5424ND-2-PSP-F
HOOD - #4 (1)

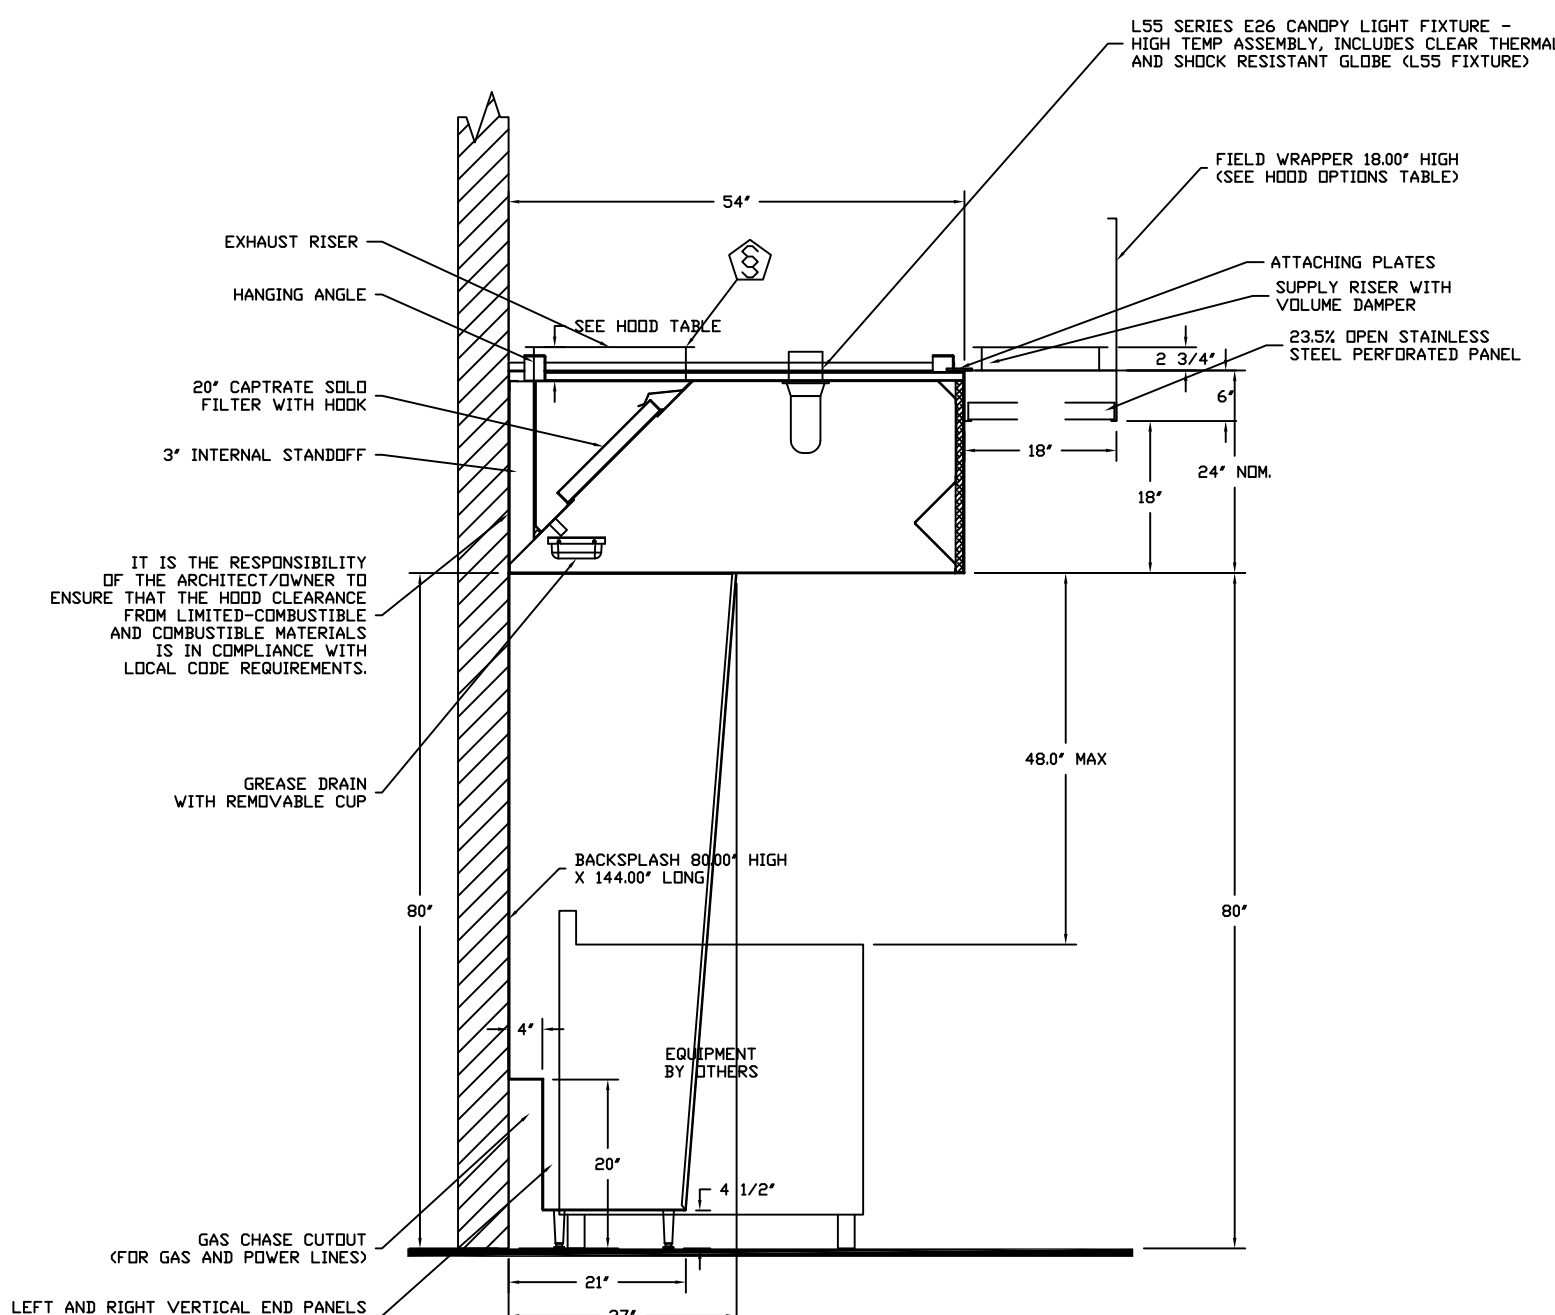

SECTION VIEW - MODEL 5424ND-2-PSP-F
HOOD - #5 (155)

REVISIONS	DESCRIPTION	DATE
Δ		
Δ		
Δ		
Δ		

CAPTIVE

Advanced Hoods Systems, LLC

www.captivehoods.com

FL PHONE: FAX: EMAIL: rag140@captivehoods.com

HILTON TAPESTRY JAMAICA
JAMAICA, BWI

DATE: 4/8/2020
DWG.#: 3696884
DRAWN BY:
SCALE: 3/4" = 1'-0"
MASTER DRAWING

SHEET NO.
2

Rok Hotel Kingston
Main & Outdoor Grill
Kingston, Jamaica

TAPESTRY
COLLECTION
BY HILTON™

uni-source
SUPPLY
INTERNATIONAL INC.

2055 W 73rd Street, Miami, FL 33016
Ph:(305)826-8696 Fax:(305)826-9131

8	Updated Background from Architect with Bar Change	6-24-20
9	Updated Background from Architect with Bar Change	10-29-20
10	Moved Garde Manger, Added Chef's office, New Bev Room	3-10-21
11	Added Back in MEP Information. Final	3-18-21
No.	Revision/Issue	Date


Date
March 18, 2021
Drawn By
Dayne Gauntlett
Scale
NTS

Sheet
FF-6.1

EXHAUST FAN INFORMATION - Job#3696884

FAN UNIT NO.	TAG	FAN UNIT MODEL #	CFM	ESP.	RPM	H.P.	B.H.P.	#	VOLT	FLA	DISCHARGE VELOCITY	WEIGHT (LBS.)	SONES
1	EF-58	DU33HFA	675	0.400	1197	0.333	0.1170	1	115	4.4	334 FPM	98	
2	EF-45	DU50HFA	1200	0.500	1278	0.500	0.2360	1	115	6.3	456 FPM	105	11.8
3	EF-1	DU200HFA	2614	1.400	1074	3.000	1.3590	3	208	9.8	636 FPM	238	16
4	EF-1	DU200HFA	2678	1.400	1079	3.000	1.3880	3	208	9.8	652 FPM	238	16.1
6	EF-155	DU200HFA	3438	1.500	1195	3.000	1.9350	3	208	9.8	836 FPM	238	20

FAN #1 DU33HFA - EXHAUST FAN (EF-58)

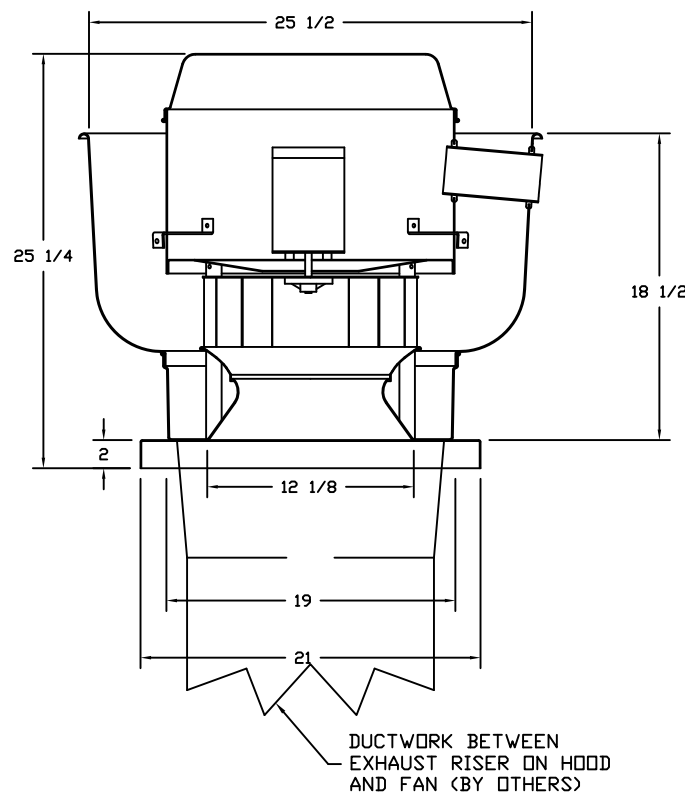


FEATURES:

- DIRECT DRIVE CONSTRUCTION (NO BELTS/PULLEYS)
- ROOF MOUNTED FANS
- RESTAURANT MODEL
- UL705
- VARIABLE SPEED CONTROL
- INTERNAL WIRING
- WEATHERPROOF DISCONNECT
- THERMAL OVERLOAD PROTECTION (SINGLE PHASE)
- HIGH HEAT OPERATION 300°F (149°C)


NORMAL TEMPERATURE TEST
EXHAUST FAN MUST OPERATE CONTINUOUSLY WHILE EXHAUSTING AIR AT 300°F (149°C) UNTIL ALL FAN PARTS HAVE REACHED THERMAL EQUILIBRIUM AND WITHOUT ANY DETERIORATING EFFECTS TO THE FAN WHICH WOULD CAUSE UNSAFE OPERATION.

OPTIONS:

- FULL CRATING FOR EXHAUST FANS
- ECM WIRING PACKAGE - EXHAUST - MANUAL OR 0-10VDC REFERENCE SPEED CONTROL (DIRECT MOTOR)
- MIAMI DADE CERTIFICATION - NEMA-1 ALUMINUM UPBLAST

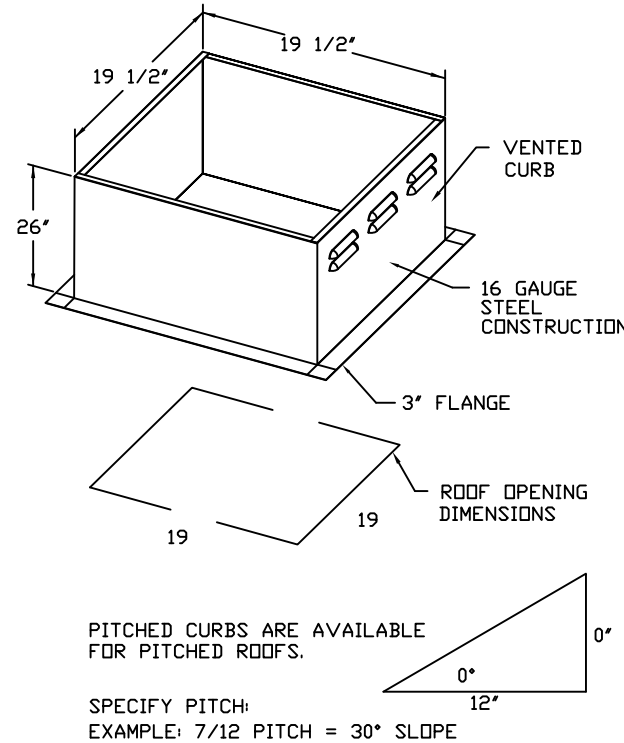

FAN #2 DU50HFA - EXHAUST FAN (EF-45)

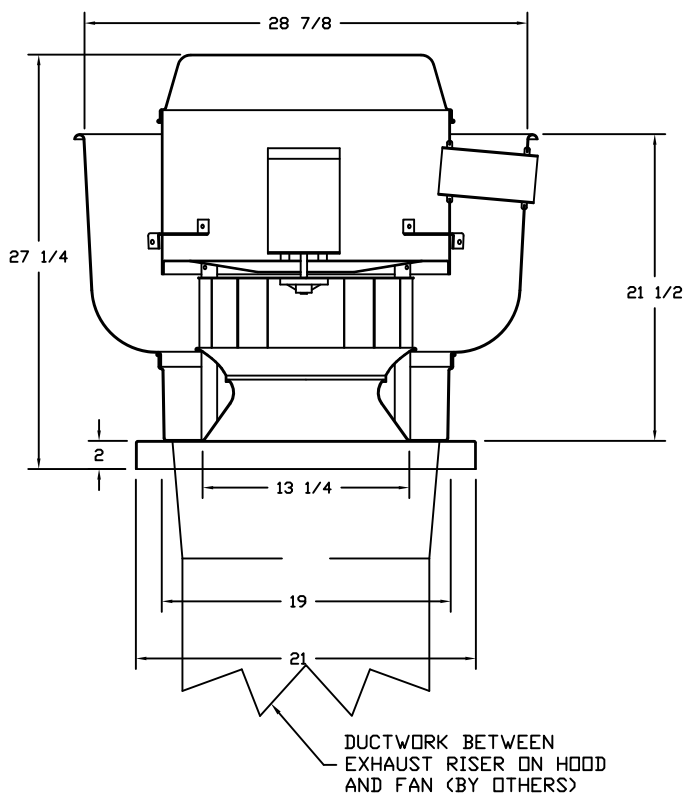


FEATURES:

- DIRECT DRIVE CONSTRUCTION (NO BELTS/PULLEYS)
- ROOF MOUNTED FANS
- RESTAURANT MODEL
- UL705
- VARIABLE SPEED CONTROL
- INTERNAL WIRING
- WEATHERPROOF DISCONNECT
- THERMAL OVERLOAD PROTECTION (SINGLE PHASE)
- HIGH HEAT OPERATION 300°F (149°C)


NORMAL TEMPERATURE TEST
EXHAUST FAN MUST OPERATE CONTINUOUSLY WHILE EXHAUSTING AIR AT 300°F (149°C) UNTIL ALL FAN PARTS HAVE REACHED THERMAL EQUILIBRIUM AND WITHOUT ANY DETERIORATING EFFECTS TO THE FAN WHICH WOULD CAUSE UNSAFE OPERATION.

OPTIONS:

- FULL CRATING FOR EXHAUST FANS
- ECM WIRING PACKAGE - MANUAL OR 0-10VDC REFERENCE SPEED CONTROL (FIELD MOTOR, CCV ROTATION)
- MIAMI DADE CERTIFICATION - NEMA-1 ALUMINUM UPBLAST

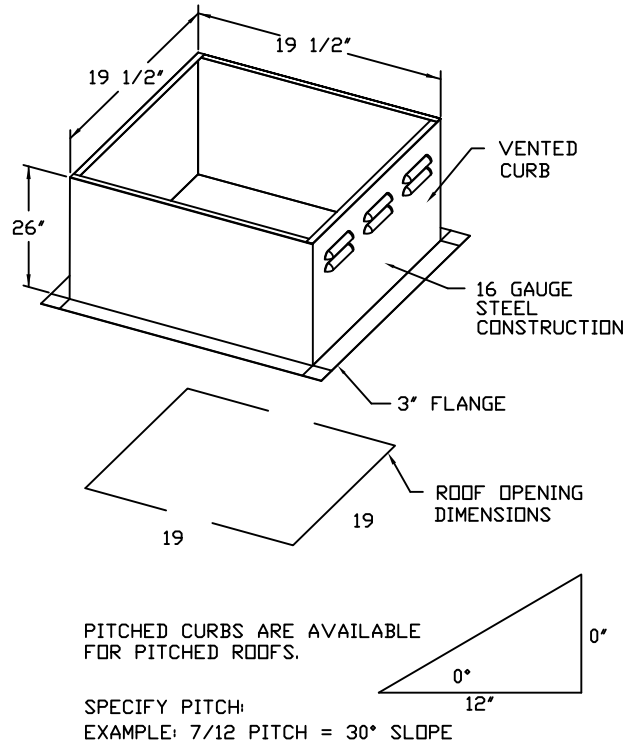

FANS #3 (EF-1), #4 (EF-1), #6 (EF-155) - DU200HFA EXHAUST FAN

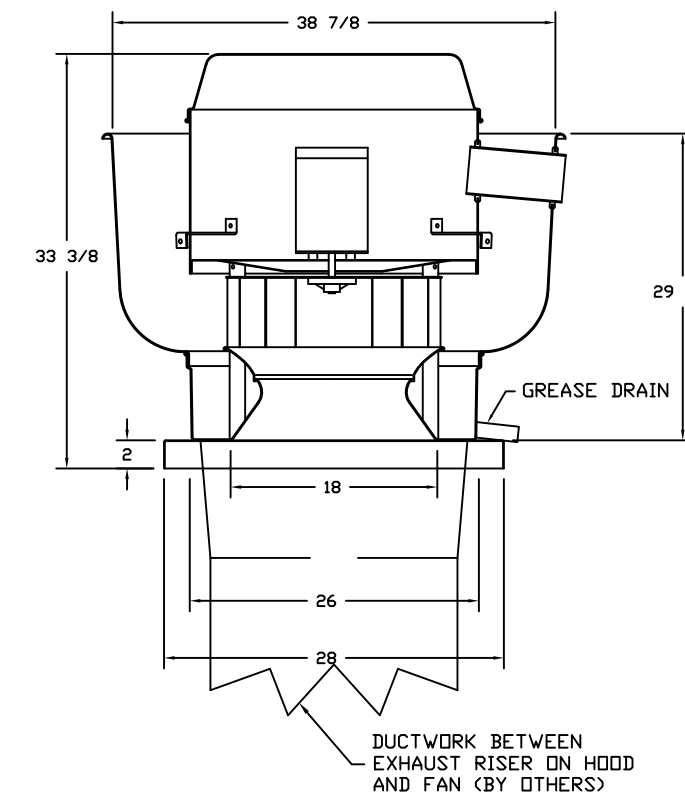

FEATURES:


- DIRECT DRIVE CONSTRUCTION (NO BELTS/PULLEYS)
- ROOF MOUNTED FANS
- RESTAURANT MODEL
- UL705 AND UL766 AND UL-6645
- VARIABLE SPEED CONTROL
- INTERNAL WIRING
- WEATHERPROOF DISCONNECT
- THERMAL OVERLOAD PROTECTION (SINGLE PHASE)
- HIGH HEAT OPERATION 300°F (149°C)
- GREASE CLASSIFICATION TESTING

NORMAL TEMPERATURE TEST
EXHAUST FAN MUST OPERATE CONTINUOUSLY WHILE EXHAUSTING AIR AT 300°F (149°C) UNTIL ALL FAN PARTS HAVE REACHED THERMAL EQUILIBRIUM AND WITHOUT ANY DETERIORATING EFFECTS TO THE FAN WHICH WOULD CAUSE UNSAFE OPERATION.

ABNORMAL FLARE-UP TEST
EXHAUST FAN MUST OPERATE CONTINUOUSLY WHILE EXHAUSTING BURNING GREASE VAPORS AT 600°F (315°C) FOR A PERIOD OF 15 MINUTES WITHOUT THE FAN BECOMING DAMAGED TO ANY EXTENT THAT COULD CAUSE AN UNSAFE CONDITION.

OPTIONS:

- GREASE BOX
- FULL CRATING FOR EXHAUST FANS
- MIAMI DADE CERTIFICATION - NEMA-1 ALUMINUM UPBLAST

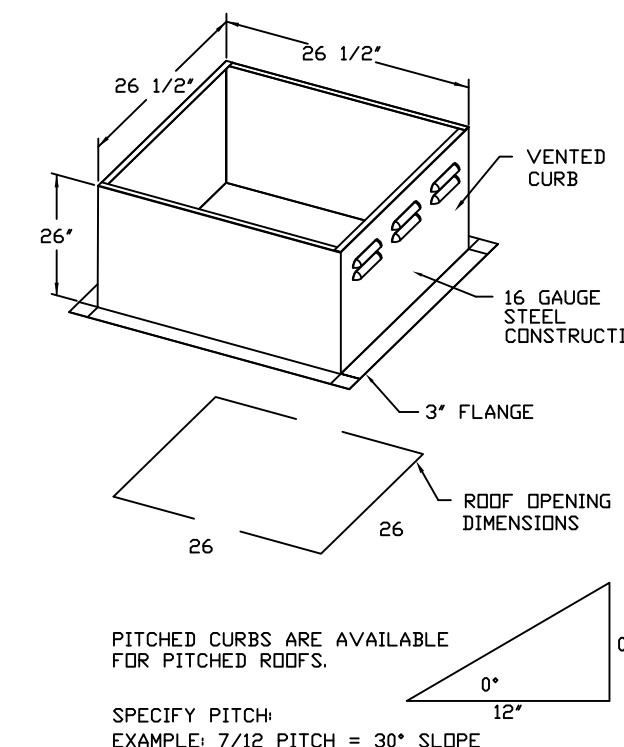

REVISIONS

NO.	DESCRIPTION	DATE
1		
2		
3		
4		
5		

CAPTIVE WIRE

Advanced Hoods Systems, LLC
www.captivewire.com
FL PHONE: FAX: EMAIL: reg.h40@captivewire.com

HILTON TAPESTRY JAMAICA
JAMAICA, B.W.I

DATE: 4/8/2020
DWG.#: 3696884
DRAWN BY:
SCALE: 3/4" = 1'-0"
MASTER DRAWING

SHEET NO. 3

Rok Hotel Kingston
Main & Outdoor Grill
Kingston, Jamaica

TAPESTRY
COLLECTION
BY HILTON™

uni-source
SUPPLY
INTERNATIONAL INC.

2055 W 73rd Street, Miami, FL 33016
Ph:(305)826-8696 Fax:(305)826-9131

8	Updated Background from Architect with Bar Change	6-24-20
9	Updated Background from Architect with Bar Change	10-29-20
10	Moved Garde Manger, Added Chef's office, New Bev Room	3-10-21
11	Added Back in MEP Information. Final	3-18-21
No.	Revision/Issue	Date

Date
March 18, 2021
Drawn By
Dayne Gauntlett
Scale
NTS



Sheet
FF-6.2

MUA FAN INFORMATION - Job#3696884

FAN UNIT NO.	TAG	FAN UNIT MODEL #	BLOWER	HOUSING	MIN CFM	DESIGN CFM	ESP.	RPM	H.P.	B.H.P.	Ø	V.D.L.T	FLA	MCA	MDCP	WEIGHT (LBS.)	SONES
5	SF-12/13	A2-20D	20MF-2-MDD	A2	2000	4233	0.650	1441	3.000	1.7820	3	208	9.8	12.3A	20A	456	17.7
7	SF-19S	A2-20D	20MF-2-MDD	A2	2000	2750	0.500	1042	1.000	0.6660	3	208	3.8	4.8A	15A	427	10.6

FAN #5 A2-20D - SUPPLY FAN (SF-12/13)
1. UNTEMPERED SUPPLY UNIT WITH 20" DIRECT DRIVE FAN IN SIZE #2 HOUSING
2. INTAKE HODD WITH EZ FILTERS
3. DOWN DISCHARGE - AIR FLOW RIGHT -> LEFT
4. FULL CRATING FOR UNTEMPERED FANS FOR SHIPPING
5. MIAMI DADE IMPACT AND WIND LOAD CERTIFICATION +30 / -130 PSF - MIAMI DADE COUNTY PRODUCT CONTROL APPROVED.
FLORIDA BUILDING CODE APPROVAL - ROOF MOUNT EXHAUST CURBS UP TO 20" HIGH MUST BE 16 GAUGE ALUMINIZED
6. SEPARATE TRIVAC WIRING PACKAGE FOR MAKE-UP AIR UNITS. OPTION MUST BE SELECTED WHEN MOUNTING VFD IN PREWIRE PANEL OR WITH DCV PACKAGE. PROVIDES SEPARATE TRIVAC INPUT TO SUPPLY FAN. THIS DCV SIGNAL MUST BE RUN BY ELECTRICIAN FROM DCV TO MUA SWITCH.



NOTE: SUPPLY DUCT MUST BE INSTALLED TO MEET SMGMA STANDARDS. A MINIMUM STRAIGHT DUCT LENGTH MUST BE MAINTAINED DOWNSTREAM OF UNIT DISCHARGE UNLESS OTHERWISE SPECIFIED. DO NOT RELY ON UNIT TO SUPPORT DUCT IN ANY WAY. FAILURE TO PROPERLY SIZE DUCTWORK MAY CAUSE SYSTEM EFFECTS AND REDUCE PERFORMANCE OF THE EQUIPMENT. SUGGESTED STRAIGHT DUCT SIZE IS 20" x 20" x 72" LONG.

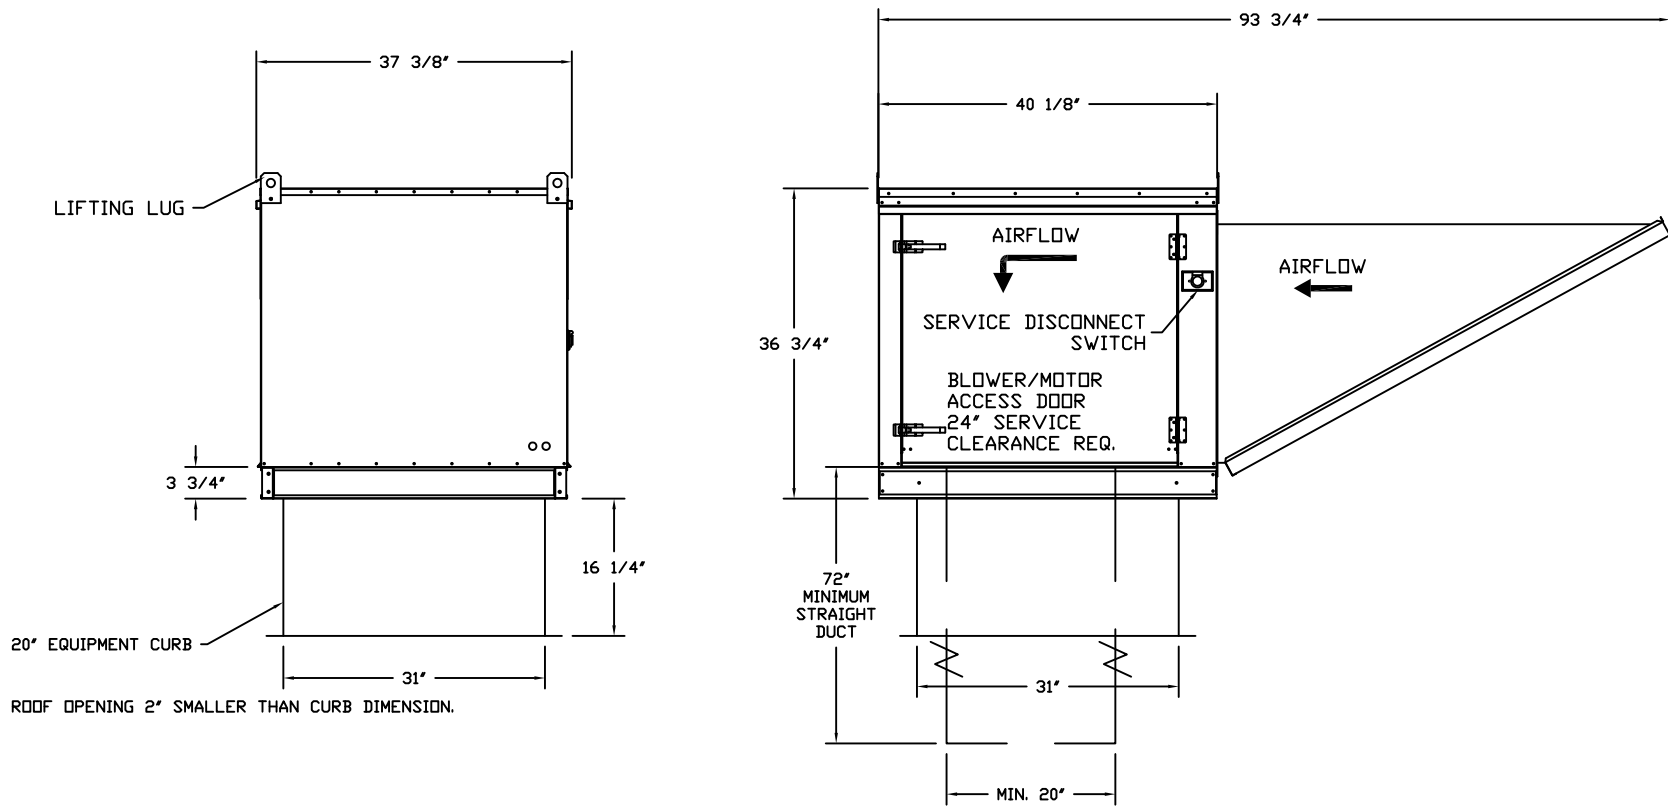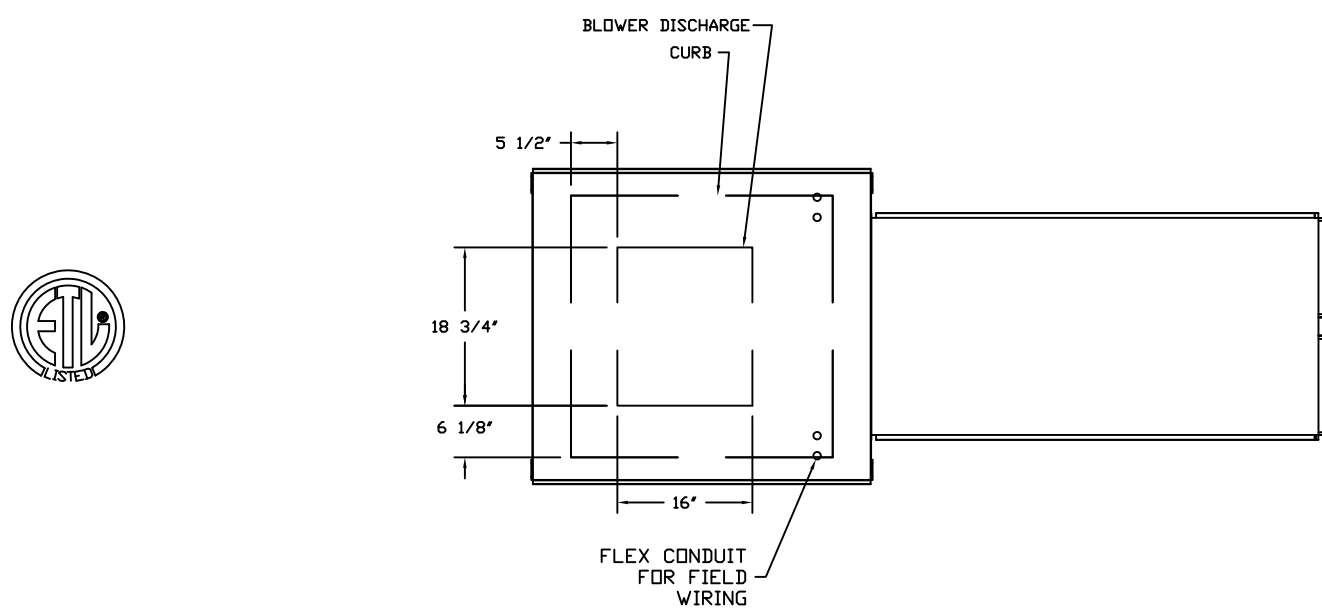

PITCHED CURBS ARE AVAILABLE FOR PITCHED ROOFS.
SPECIFY PITCH:
EXAMPLE: 7/12 PITCH = 30° SLOPE

FAN #7 A2-20D - SUPPLY FAN (SF-19S)
1. UNTEMPERED SUPPLY UNIT WITH 20" DIRECT DRIVE FAN IN SIZE #2 HOUSING
2. INTAKE HODD WITH EZ FILTERS
3. DOWN DISCHARGE - AIR FLOW RIGHT -> LEFT
4. FULL CRATING FOR UNTEMPERED FANS FOR SHIPPING
5. MIAMI DADE IMPACT AND WIND LOAD CERTIFICATION +30 / -130 PSF - MIAMI DADE COUNTY PRODUCT CONTROL APPROVED.
FLORIDA BUILDING CODE APPROVAL - ROOF MOUNT EXHAUST CURBS UP TO 20" HIGH MUST BE 16 GAUGE ALUMINIZED

NOTE: SUPPLY DUCT MUST BE INSTALLED TO MEET SMGMA STANDARDS. A MINIMUM STRAIGHT DUCT LENGTH MUST BE MAINTAINED DOWNSTREAM OF UNIT DISCHARGE UNLESS OTHERWISE SPECIFIED. DO NOT RELY ON UNIT TO SUPPORT DUCT IN ANY WAY. FAILURE TO PROPERLY SIZE DUCTWORK MAY CAUSE SYSTEM EFFECTS AND REDUCE PERFORMANCE OF THE EQUIPMENT. SUGGESTED STRAIGHT DUCT SIZE IS 20" x 20" x 72" LONG.

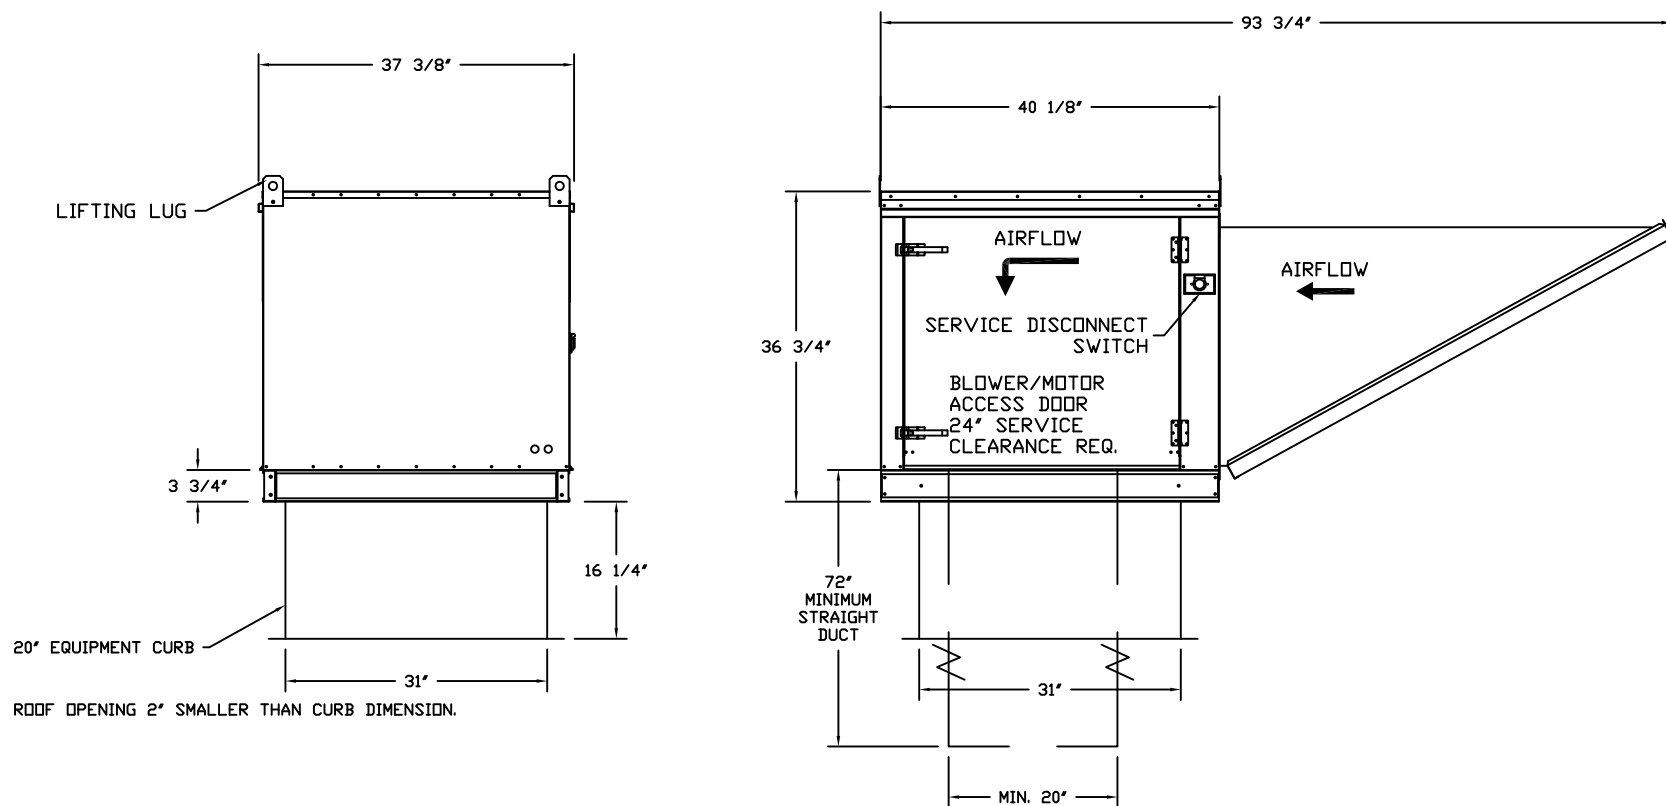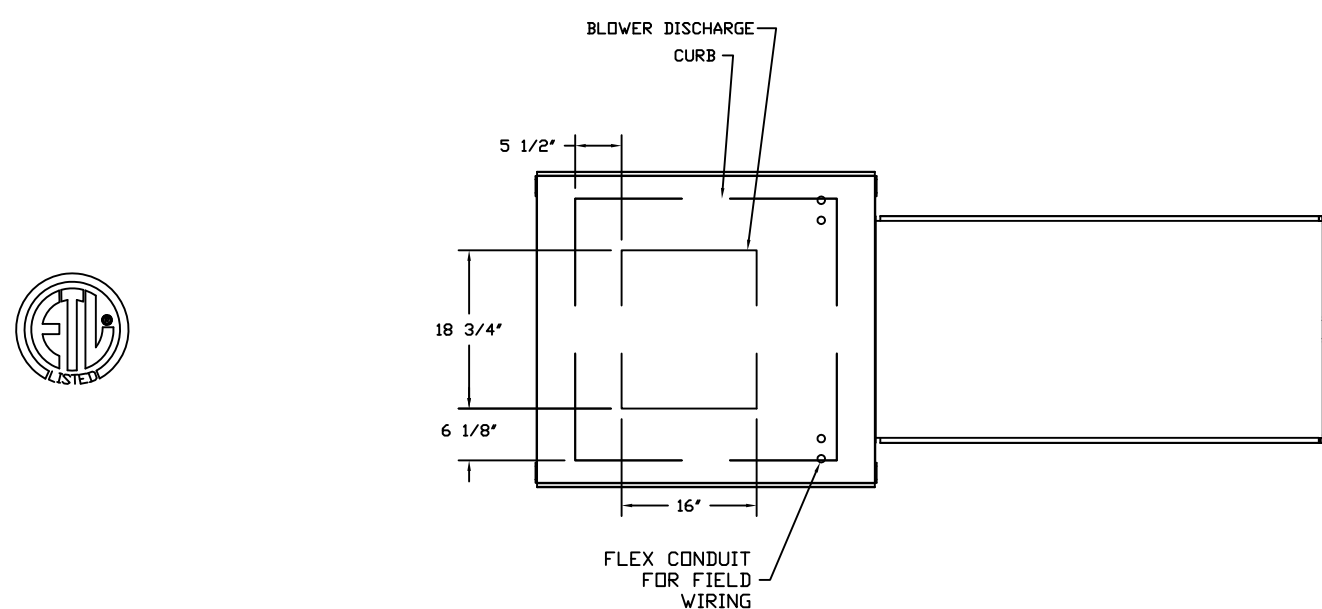

PITCHED CURBS ARE AVAILABLE FOR PITCHED ROOFS.
SPECIFY PITCH:
EXAMPLE: 7/12 PITCH = 30° SLOPE

REVISIONS

NO.	DESCRIPTION	DATE
1		
2		
3		
4		
5		

CAPTIVE

Advanced Hoods Systems, LLC

www.captivehoods.com

FL PHONE: FAX: EMAIL: reg.hill@captivehoods.com

HILTON TAPESTRY JAMAICA

JAMAICA, BVI

DATE: 4/8/2020

DWG.#: 3696884

DRAWN BY:

SCALE: 3/4" = 1'-0"

MASTER DRAWING

SHEET NO. 4

Rok Hotel Kingston
Main & Outdoor Grill
Kingston, Jamaica

TAPESTRY
COLLECTION
BY HILTON™

uni-source
SUPPLY
INTERNATIONAL INC.

2055 W 73rd Street, Miami, FL 33016
Ph:(305)826-8696 Fax:(305)826-9131





8	Updated Background from Architect with Bar Change	6-24-20
9	Updated Background from Architect with Bar Change	10-29-20
10	Moved Garde Mange, Added Chef's office, New Bev Room	3-10-21
11	Added Back in MEP Information. Final	3-18-21
No.	Revision/Issue	Date

Date
March 18, 2021
Drawn By
Dayne Gauntlett
Scale
NTS

Sheet
FF-6.3

ELECTRICAL PACKAGE -- Job#3696884

ND.	TAG	PACKAGE #	LOCATION	SWITCHES		OPTION	FANS CONTROLLED			
				LOCATION	QUANTITY		FAN TAG	TYPE	#	HP, VOLT FLA
1	1	DCV-2111	Utility Cabinet Right	04 - Utility Cabinet Right	1 Light	Smart Controls DCV	EF-1	Exhaust	3	3,000 208 9.8
				Hood # 4	1 Fan		SF-12/13	Supply	3	3,000 208 9.8
2	155	DCV-1111	Wall Utility Cabinet Left	02 - Face Mount Right Side of Hood	1 Light	Smart Controls DCV	EF-155	Exhaust	3	3,000 208 9.8
				Hood # 5	1 Fan		SF-155	Supply	3	1,000 208 3.8

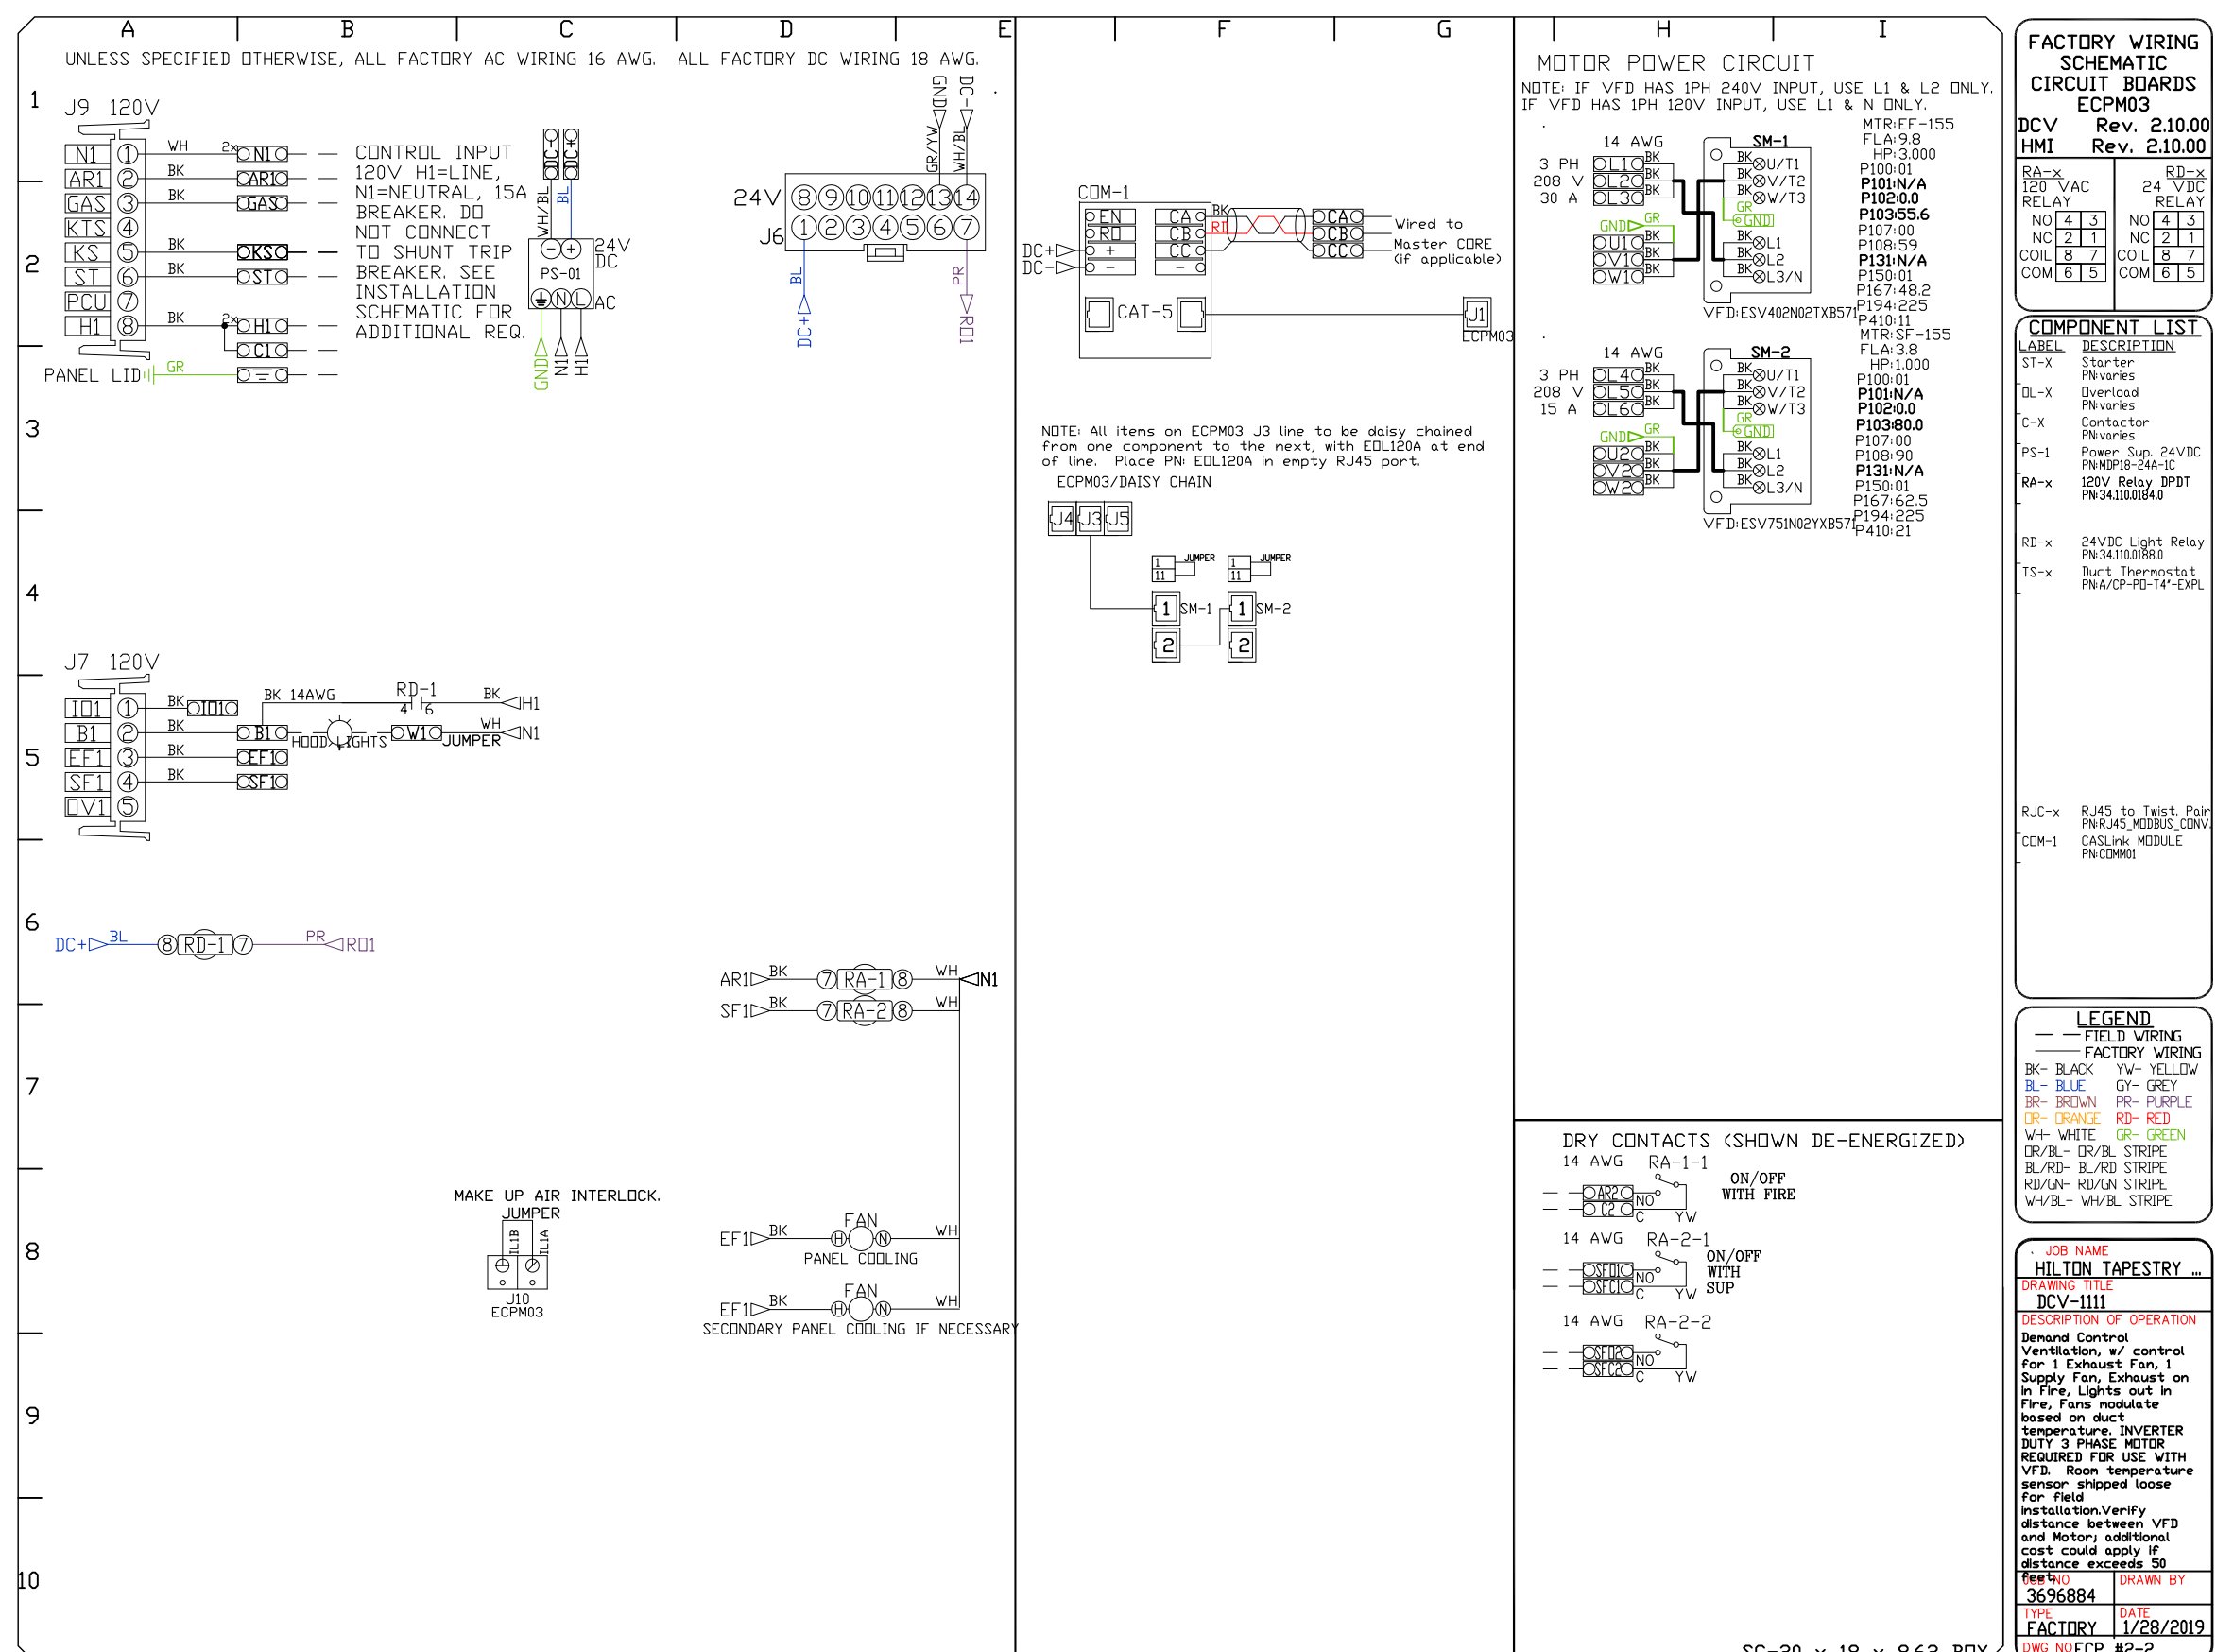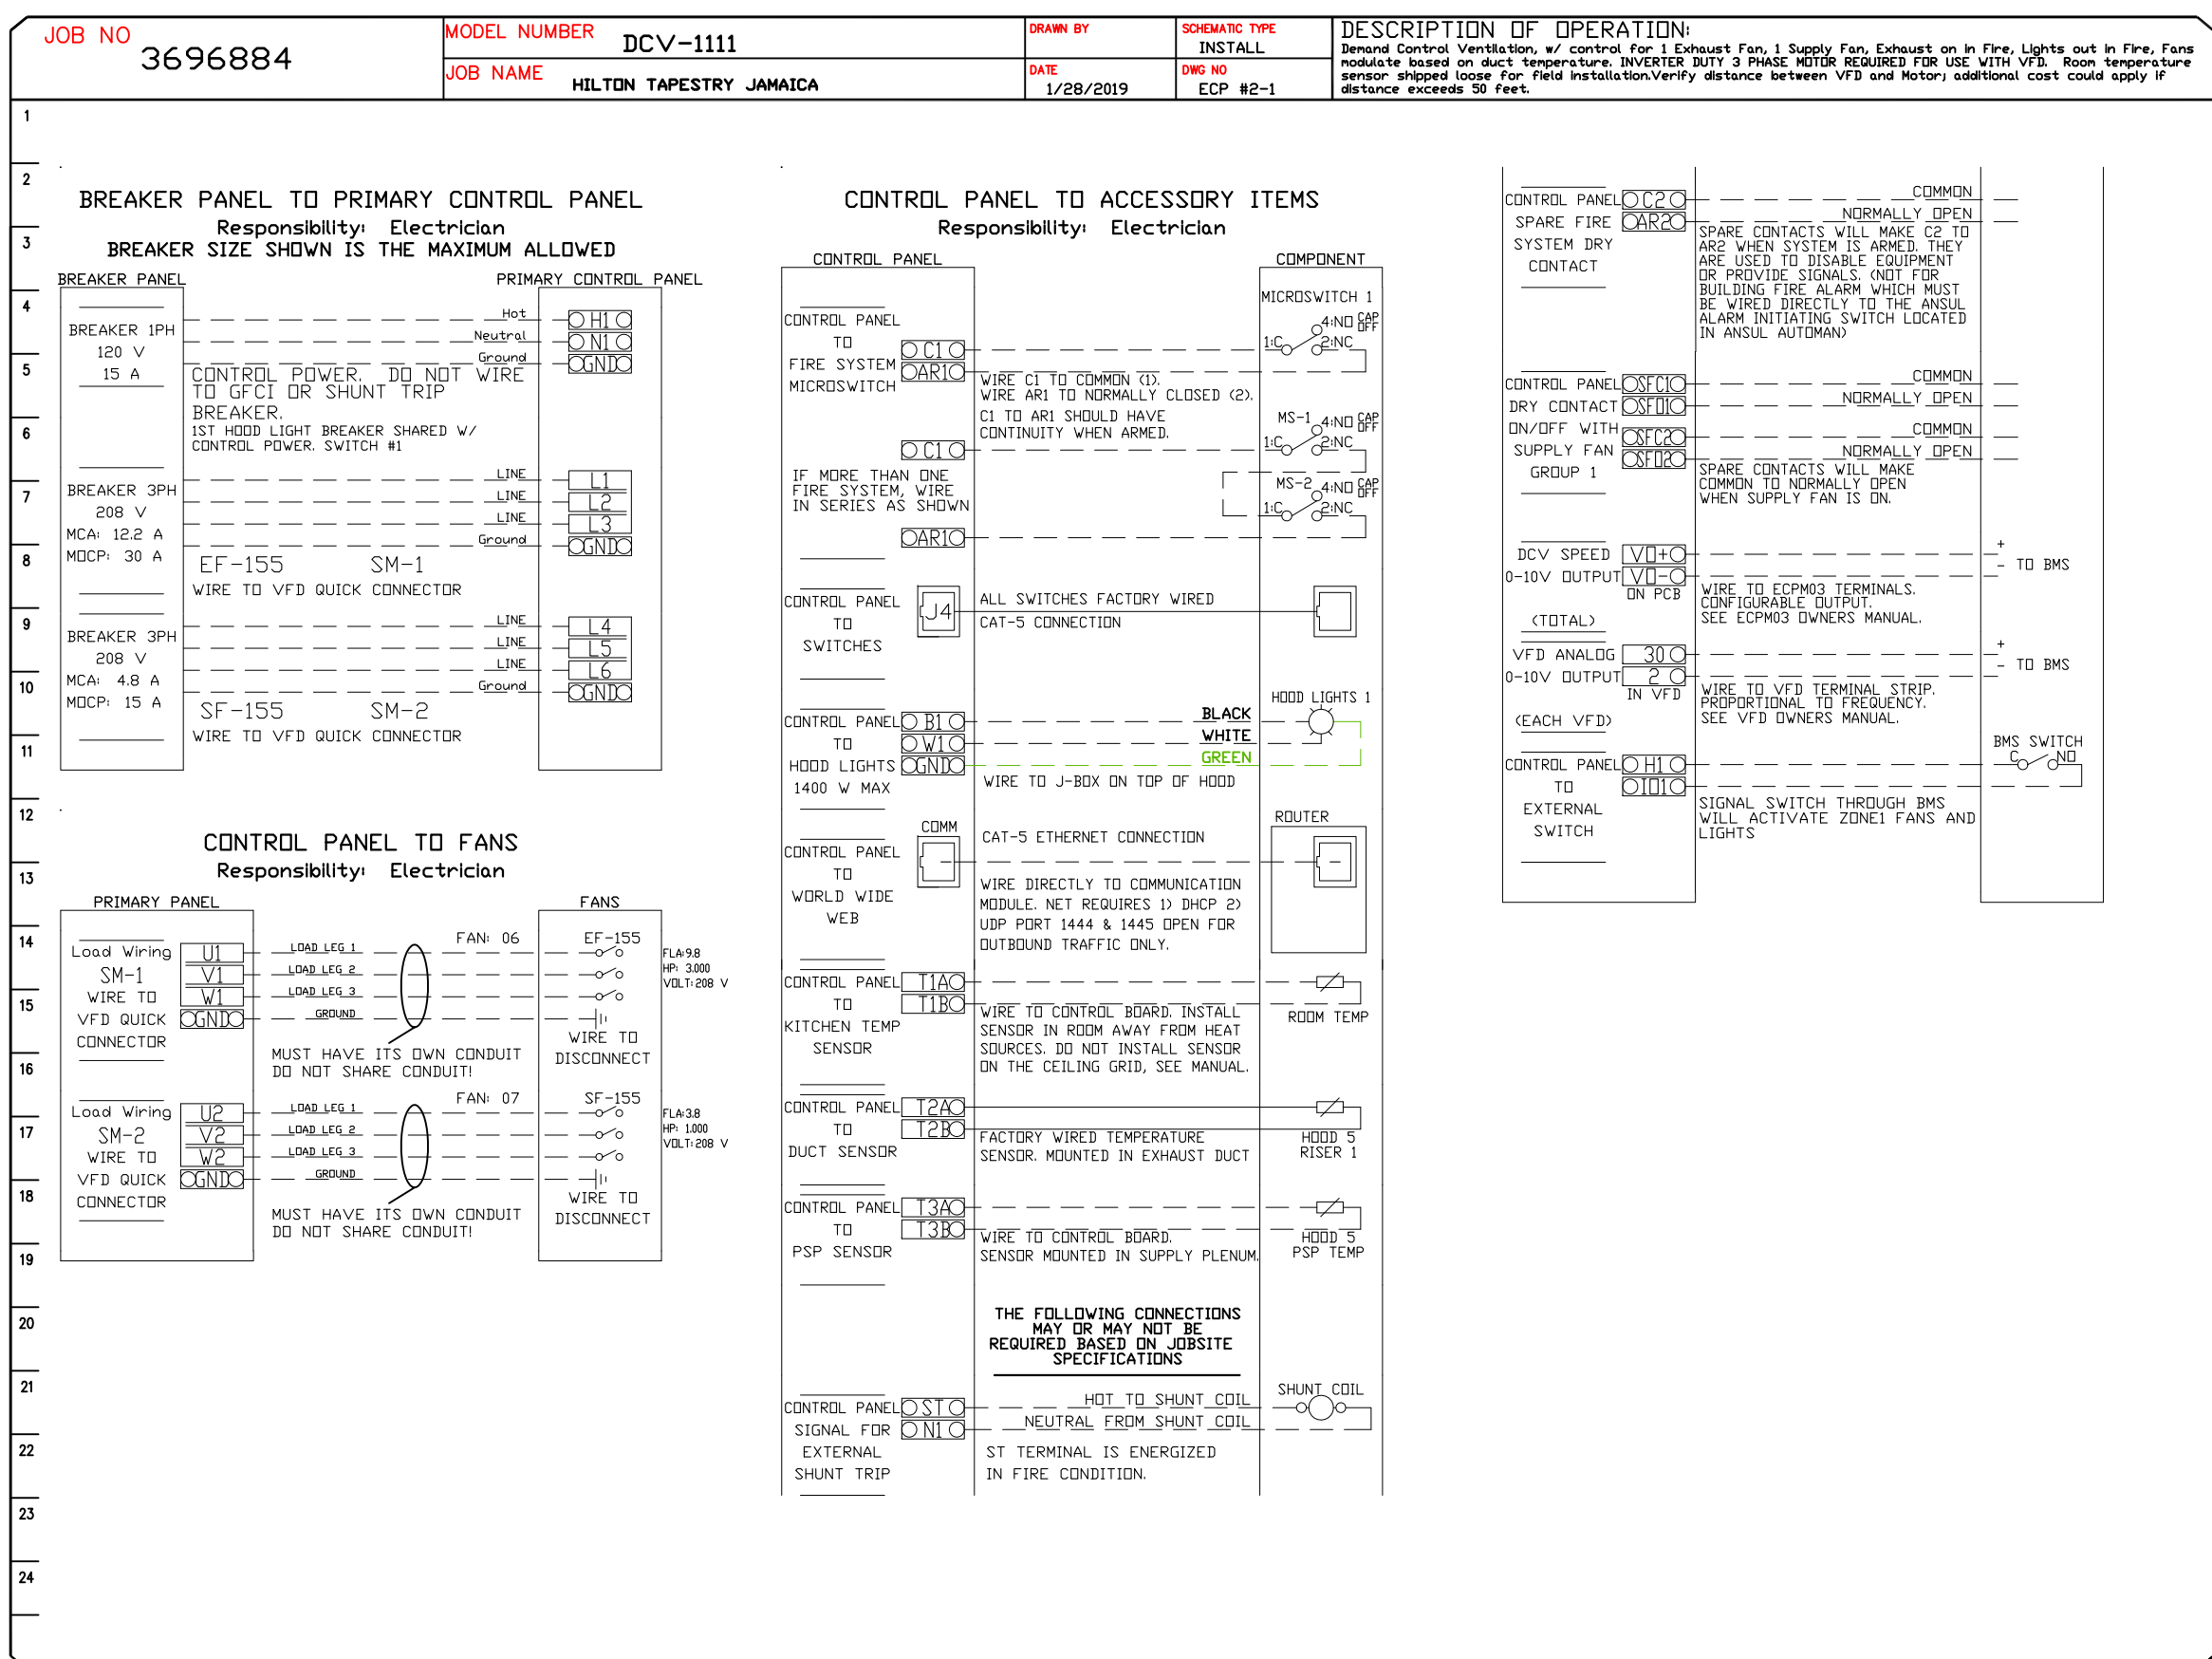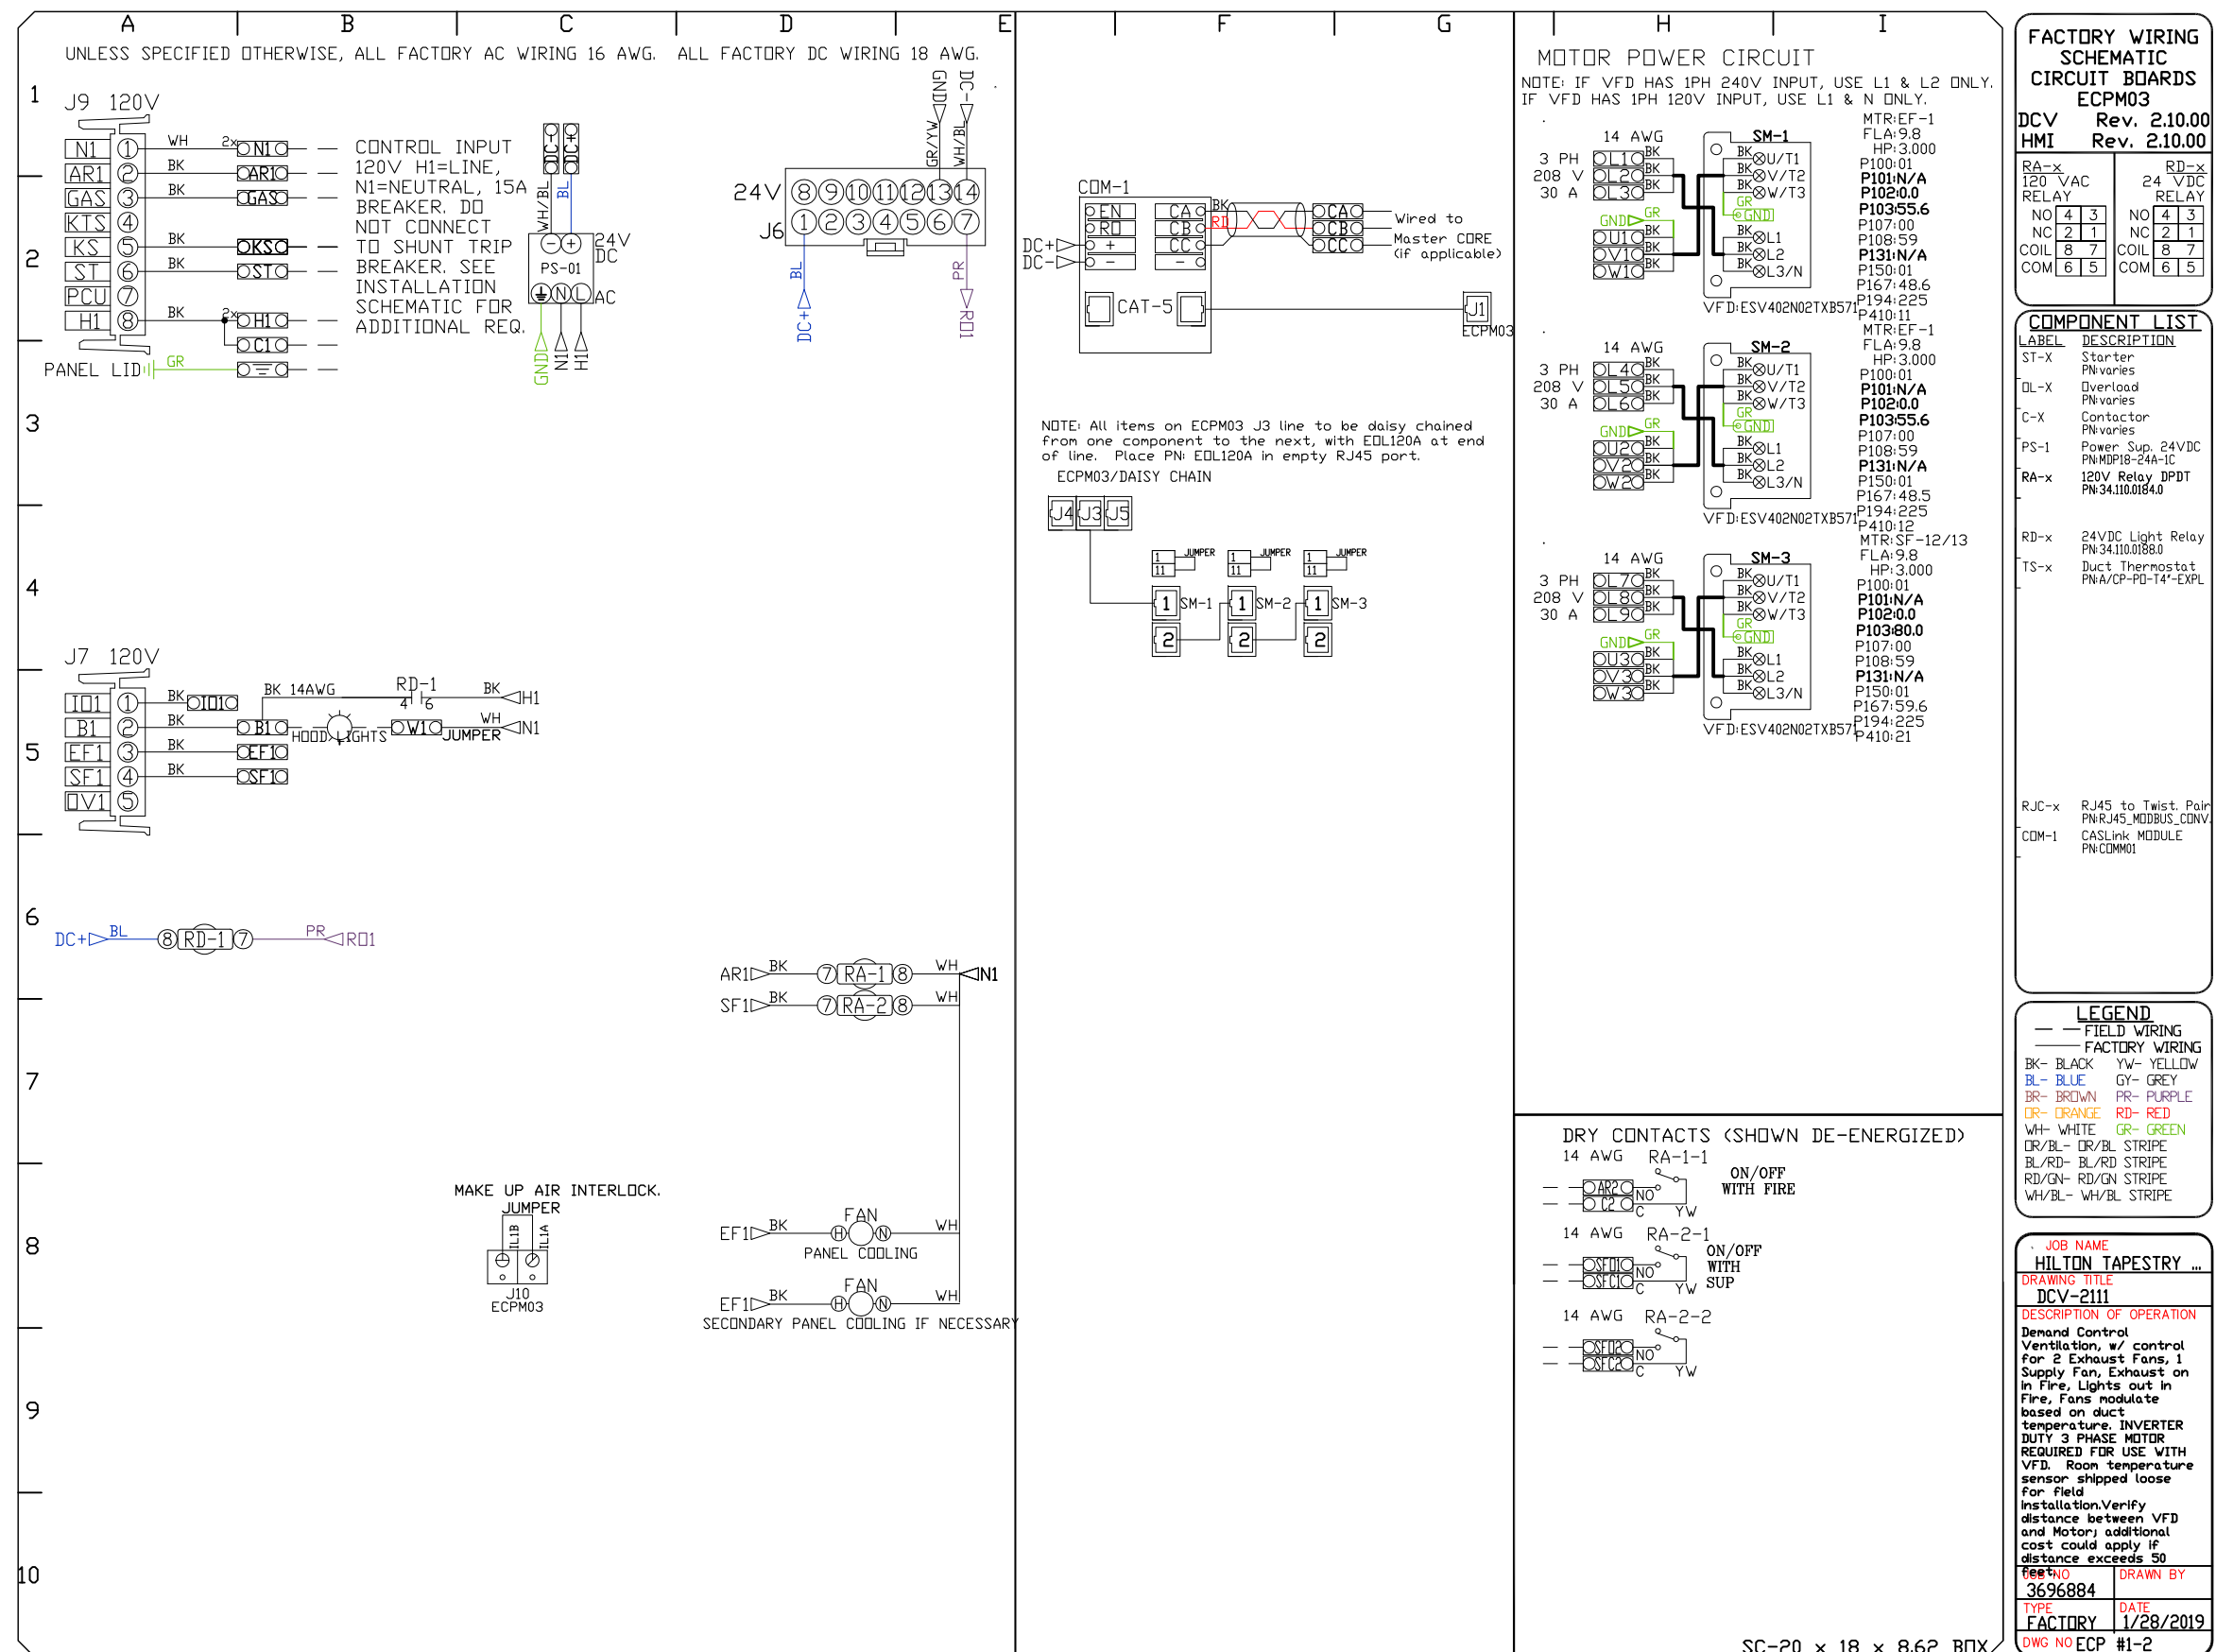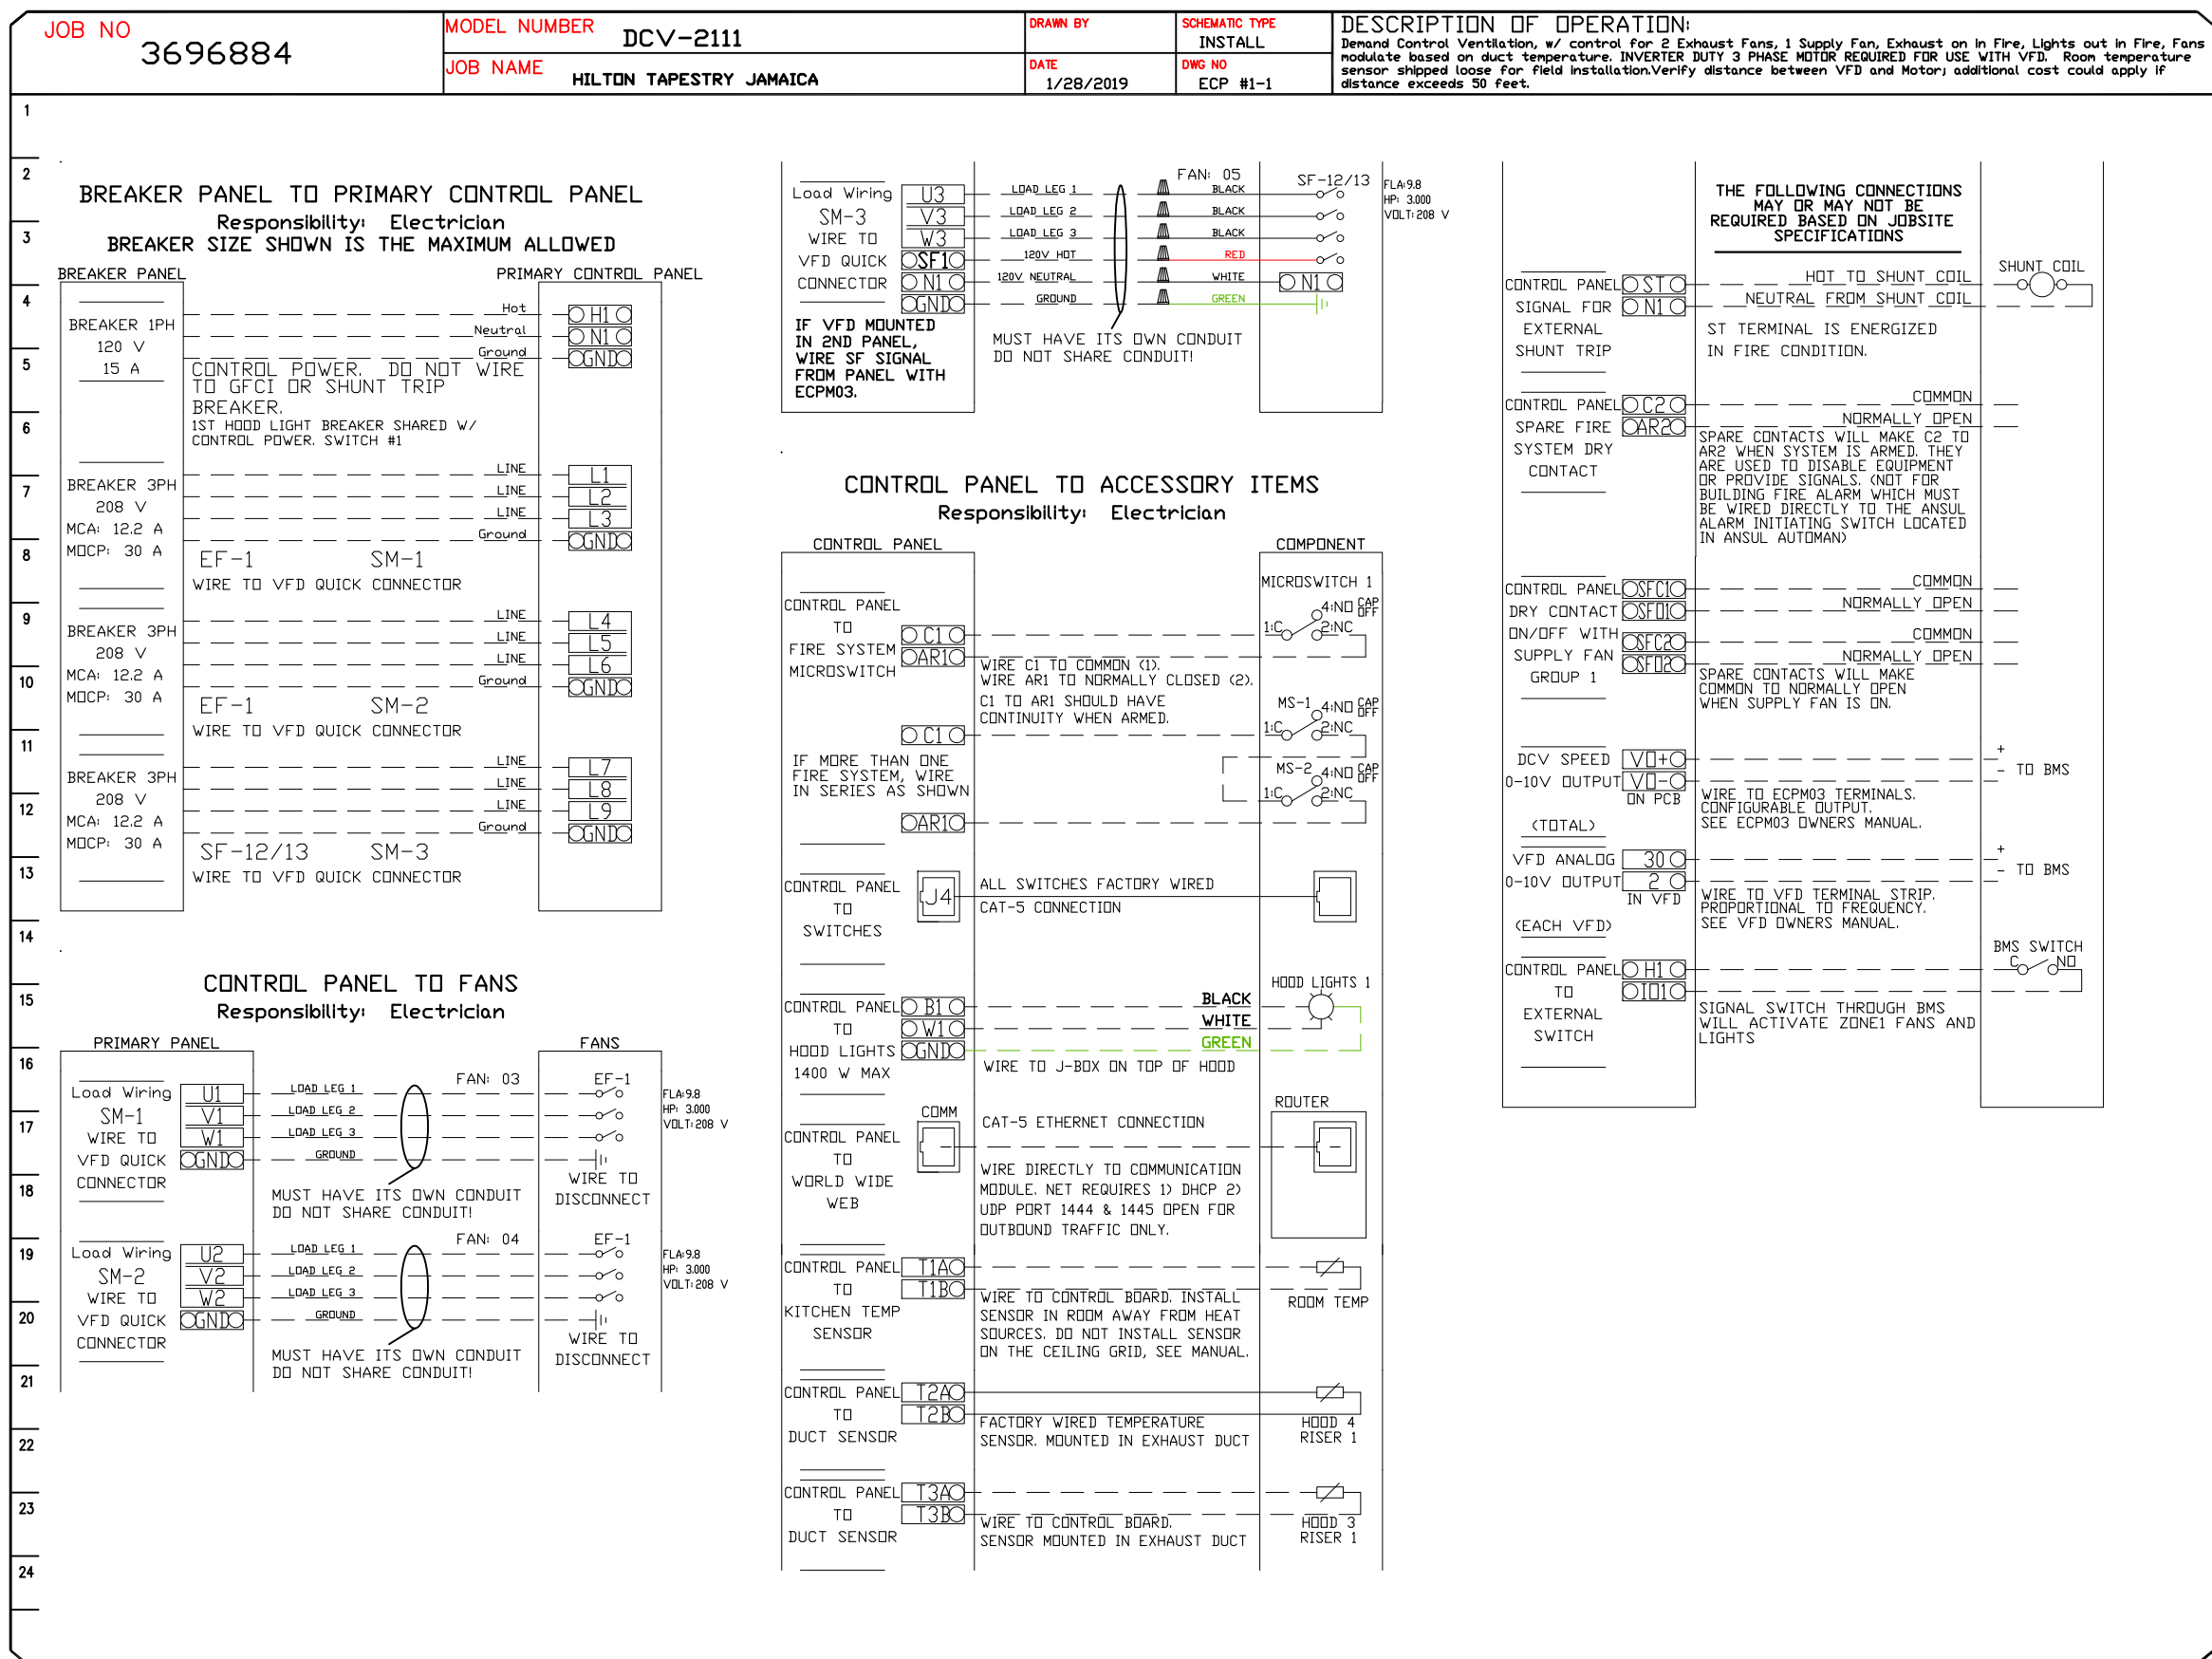


REVISIONS

NO.	DESCRIPTION	DATE
1	Initial Issue	1/28/2019

DATE: 4/8/2020 **DWG. #:** 3696884 **DRAWN BY:** DAYNE GAUNTLETT **SCALE:** 3/4" = 1'-0" **MASTER DRAWING**

SHEET NO. 5

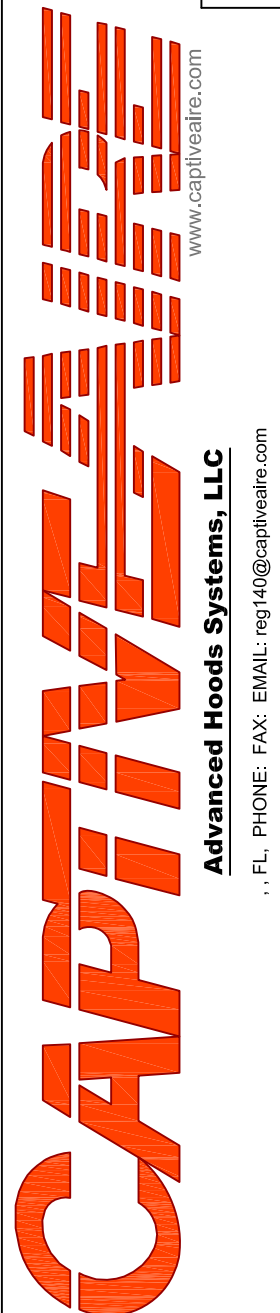

Rok Hotel Kingston
Main & Outdoor Grill
Kingston, Jamaica

TAPESTRY COLLECTION
BY HILTON™



uni-source SUPPLY
INTERNATIONAL INC.

2055 W 73rd Street, Miami, FL 33016
Ph:(305)826-8696 Fax:(305)826-9131

8	Updated Background from Architect with Bar Change	6-24-20
9	Updated Background from Architect with Bar Change	10-29-20
10	Moved Garde Manger, Added Chef's Office, New Bev Room	3-10-21
11	Added Back in MEP Information. Final	3-18-21
No.	Revision/Issue	Date


Date
March 18, 2021
Drawn By
Dayne Gauntlett
Scale
NTS

Sheet
FF-6.4

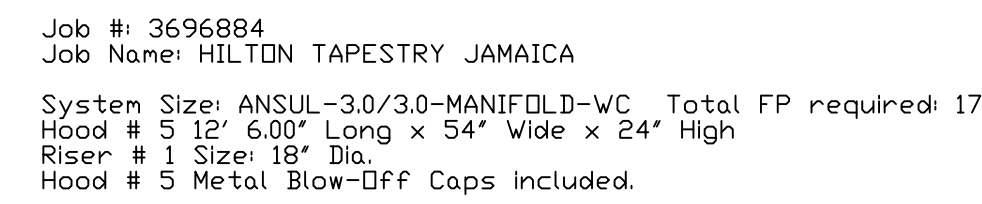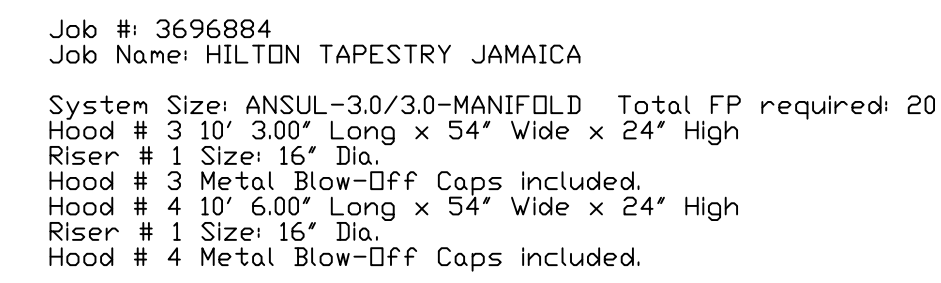

Sheet

FF-6.5

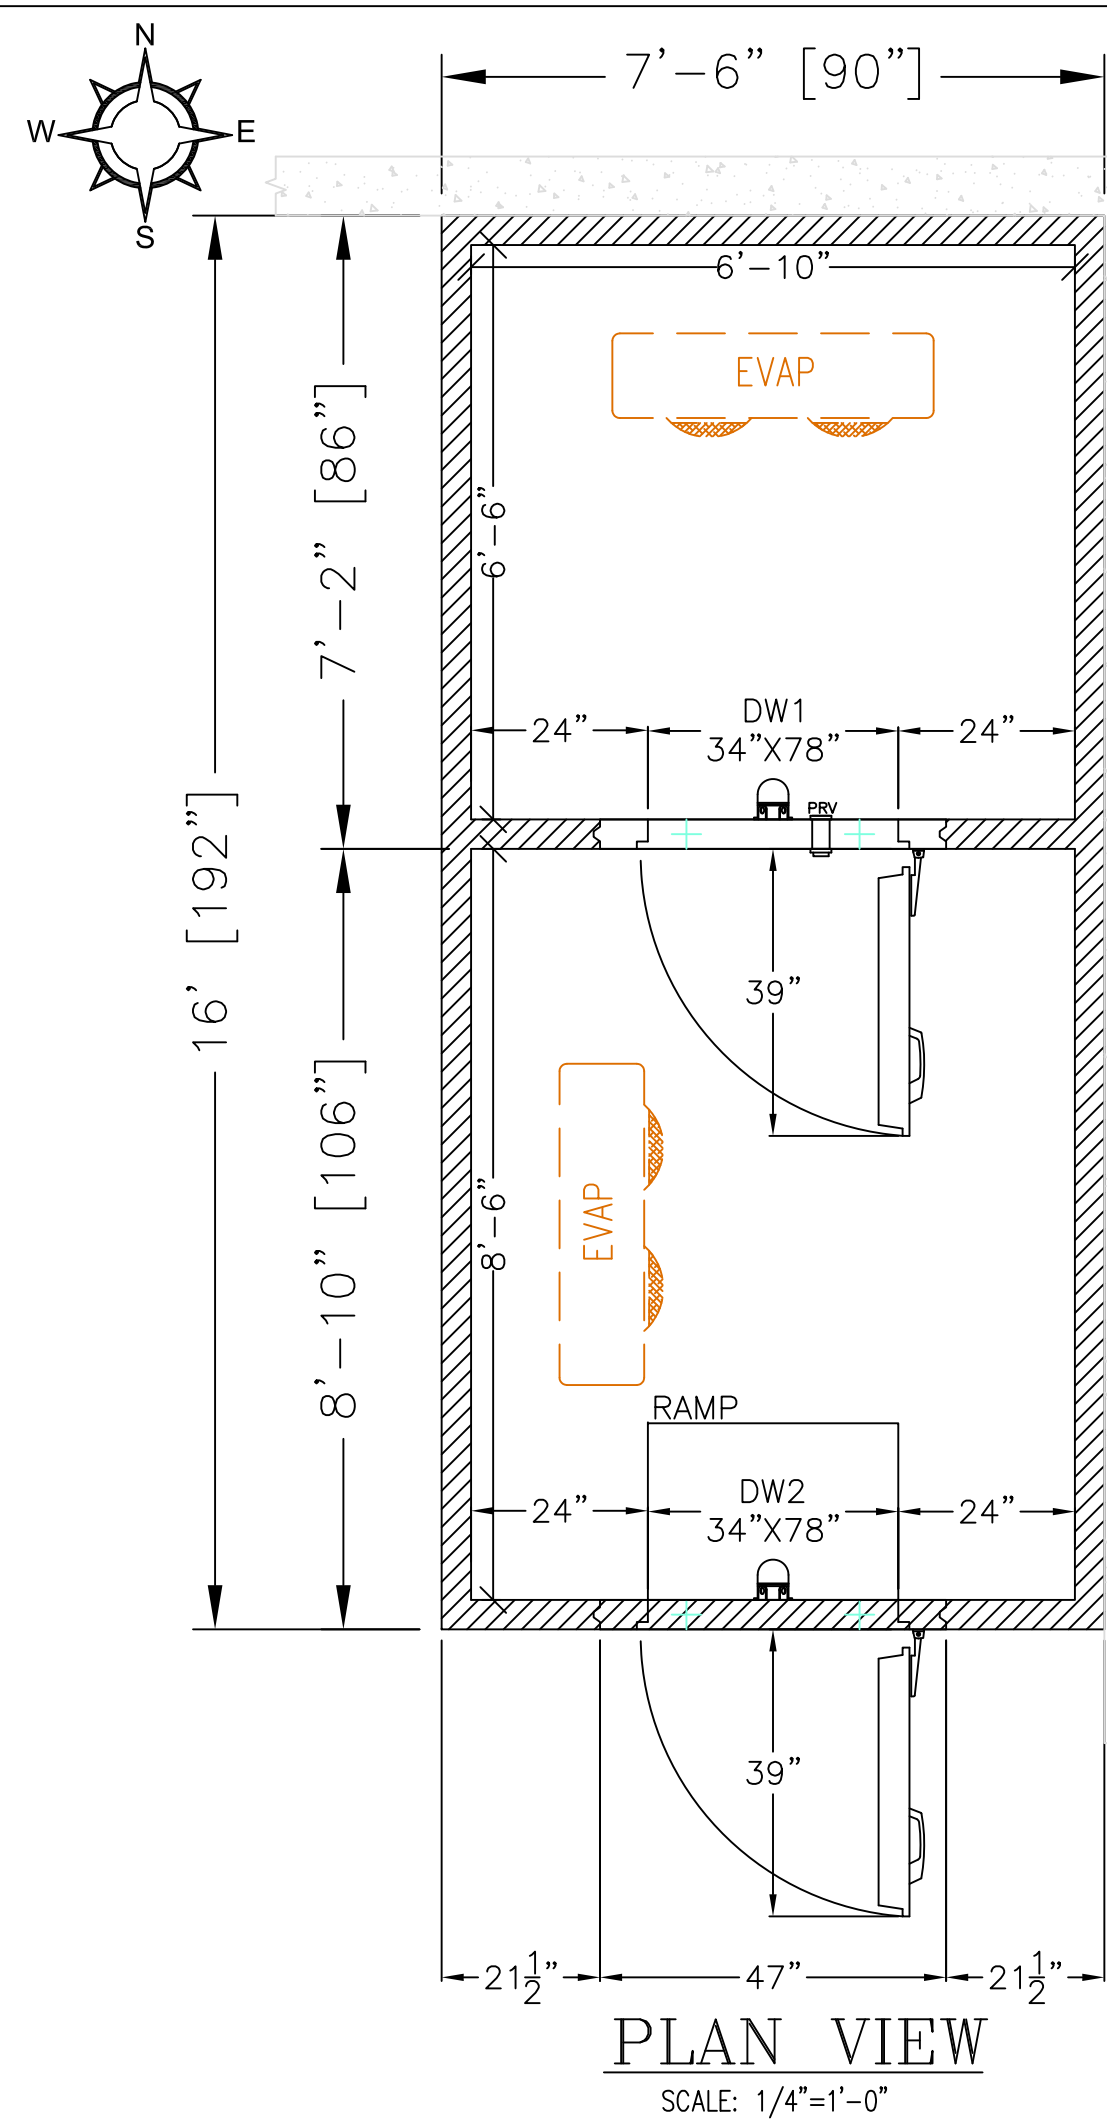


FREEZER -10°
(WITH FLOOR)
EXTRUDED HDF


COOLER 35°
(WITH FLOOR)
EXTRUDED HDF

ACCESSORIES

- (2) AIR CURTAIN, PLASTIC STRIP (UP TO 41"x80" DOOR)
- (1) 34" INT.RAMP.

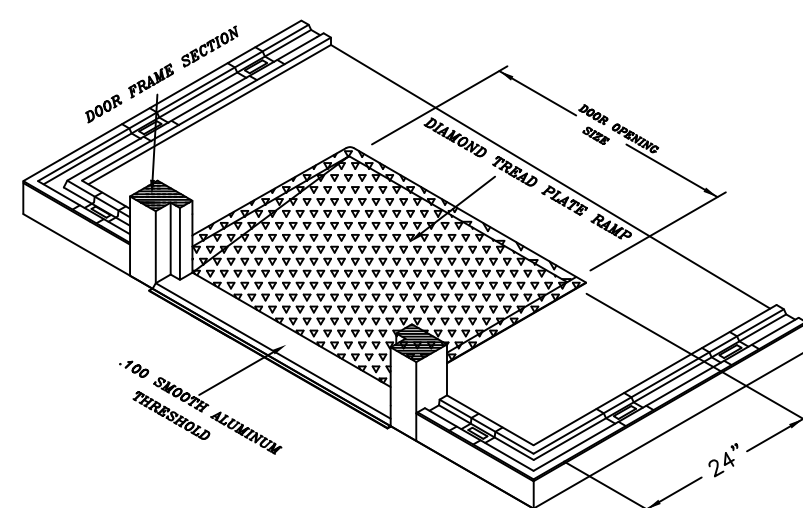


INTERIOR RAMP. STD
ISOMETRIC VIEW

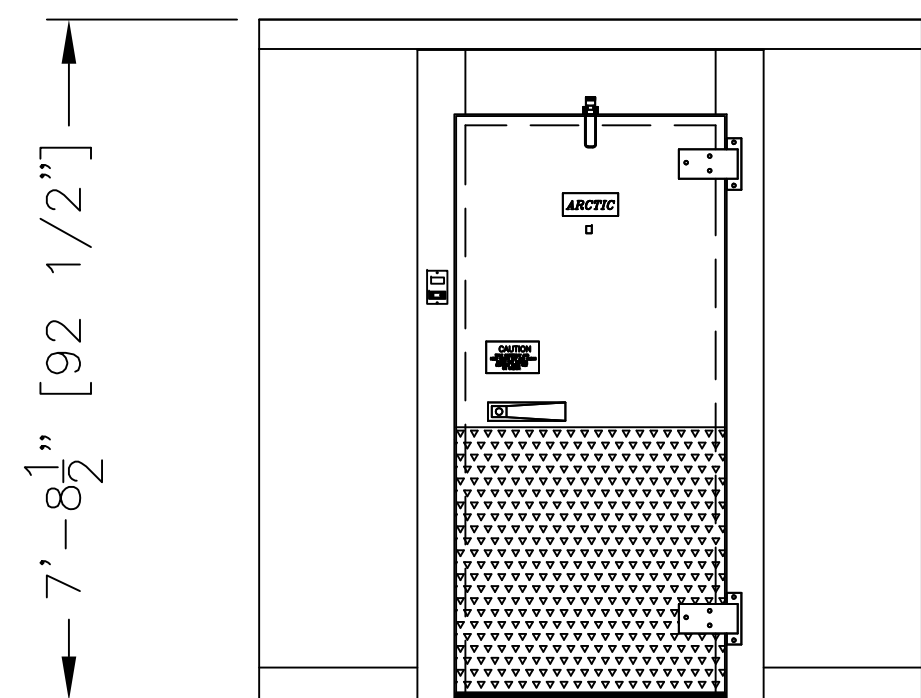

ELEVATION


REFRIGERATION DATA SHEET														
ITEM	QTY	HP	MANUFACTURE	MODEL	REFRIG	VP/H	MCA	FANS	CONNECTION		DIMENSIONS(IN)			COVER
									INLET	SUCTION	LENGTH	DEEP	HEIGHT	
HERMETIC,REMOTE PRE-ASSEMBLED,AIR-COOLED,35°,OUTDOOR														
1	1	3/4	RUSSELL	RFH090E4SMA	R404/R448	200-220/1/50	15		3/8	5/8	26 1/4	28 1/4	18 3/4	
2	1		RUSSELL	RL6A073M		220/1/60	1.6	2	3/8	5/8	43 5/8	12 1/2	16 3/4	
EVAPORATOR PLACEMENT ON DRAWING SHOULD BE USED FOR REFERENCE ONLY														
HERMETIC,REMOTE PRE-ASSEMBLED,AIR-COOLED,-10°F,OUTDOOR														
3	1	2	RUSSELL	RFH200L44M	R404A	200-220/1/50	32.2		1/2	7/8	38 1/4	28 1/4	18 3/4	
4	1		RUSSELL	RL6E077MEA		200-220/1/50	10.8	2	3/8	5/8	43 5/8	15 1/2	16 3/4	
ACCESSORIES		6.56 FT DRAIN LINE HEATER MODEL HB02-2.240/1/60, 46 WATTS, 0.19 AMP(SHIPPED LOOSE)												
EVAPORATOR PLACEMENT ON DRAWING SHOULD BE USED FOR REFERENCE ONLY														

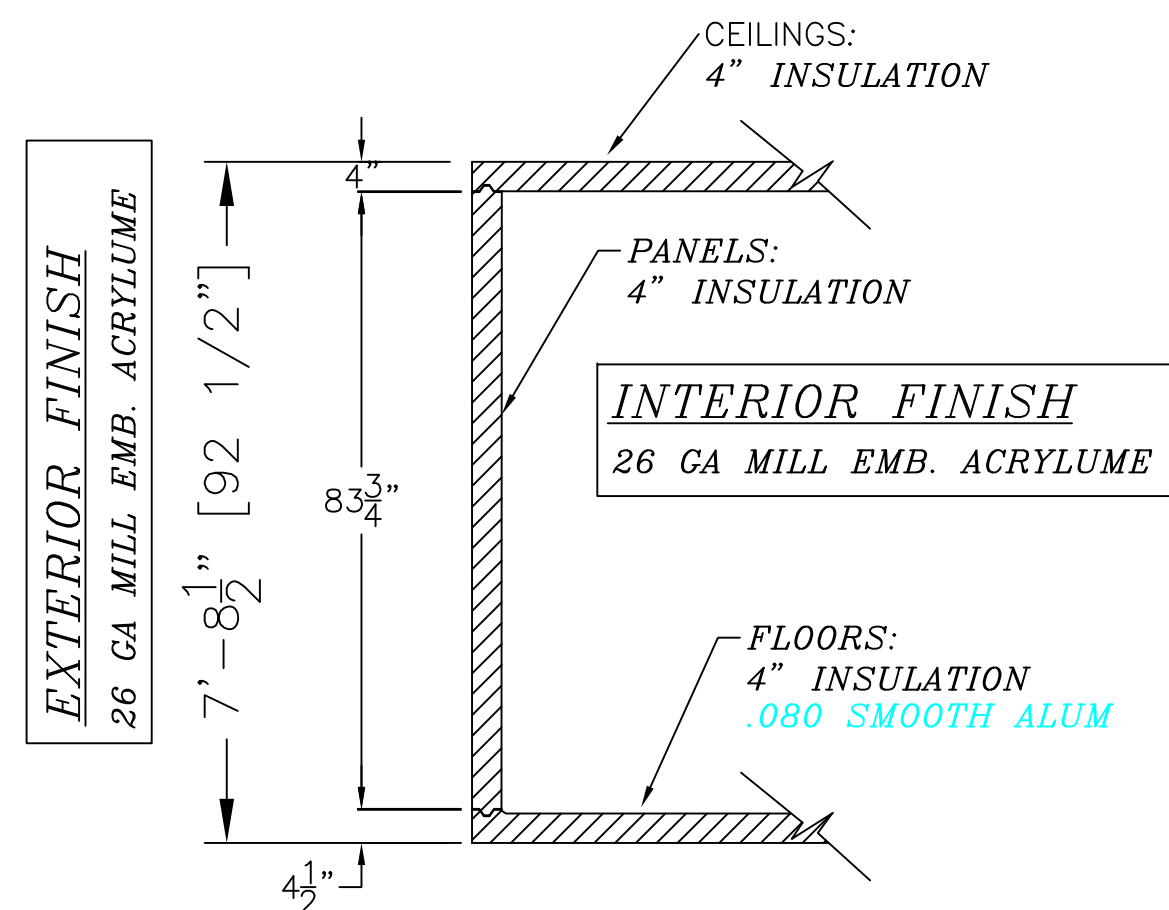

SECTION WALL WITH FLOOR

SCALE: 1/4"=1'-0"

-ARCTIC'S STANDARD WALK-IN FLOOR PANELS ARE DESIGNED TO WITHSTAND UNIFORMLY DISTRIBUTED STATIONARY LOADS OF 750 LBS AND ROLLING LOAD OF 300 LBS.

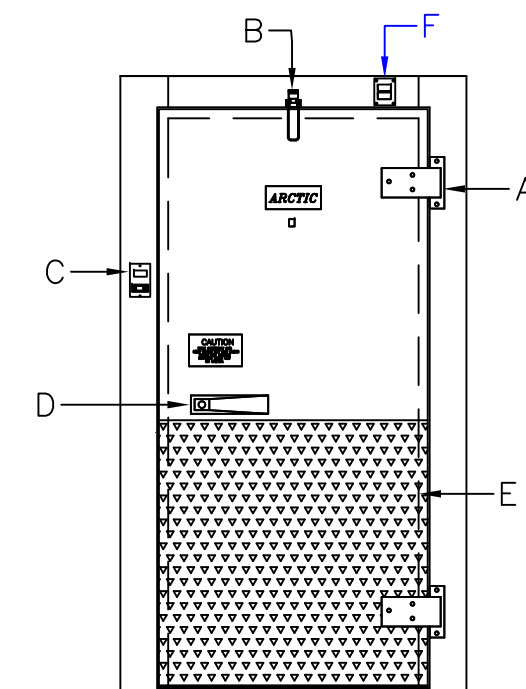

DOOR & FRAME RHH

- A-HEAVY DUTY CAM-LIFT HINGES
- B-HYDRAULIC DOOR CLOSER
- C-DIGITAL THERM/SWITCH 24DT-L4F1-B
- D-KEYED LATCH W/INT. SAFETY RELEASE
- E-36" DIAMOND TREAD PLATE INT. & EXT.
- F-PRV (FREEZER ONLY)

INTERIOR FINISH

26 GA MILL EMB. ACRYLUME

EXTERIOR FINISH

26 GA MILL EMB. ACRYLUME

DOOR(S) ELECTRICAL DATA			
DOOR NO.	DESCRIPTION.	VOLTS	AMP
1	FREEZER DOOR, V.P.LIGHT & HEATER	115/1/60	2.2
2	COOLER DOOR, V.P LIGHTS	115/1/60	1.0

INSULATION PROPERTIES:

TYPE: XPS FOAM
THICKNESS: 4"
FLAME SPREAD: 15
SMOKE DEVELOPED: 165



GENERAL NOTE
NOTICE TO GENERAL CONTRACTOR AND SUB-CONTRACTOR. FOR QUARRY TILE OR CONCRETE WEARING FLOORS, THE METAL FACINGS MAY BE SUS-CEPTIBLE TO STAINING DUE TO EXCESSIVE MOISTURE CREATED BY HYDRATION OF CONCRETE-TYPE MATERIALS. IT IS ESSENTIAL THAT EACH ROOM BE PROPERLY VENTILETED. SPECIAL PRECAUTIONS MUST BE TAKEN WHEN USING MURIATIC ACID DUE TO EFFECTS OF ACID FUMES ON ALUMINUM AND STAINLESS STEEL. IN ADDITION, METAL SURFACES MUST BE PROTECTED FROM LIME AND OTHER CHEMICALS FOUND IN CONCRETE BY-PRODUCTS. PETROLEUM BASED PROTECTION MUST BE APPLIED BETWEEN CONCRETE AND THE METAL SURFACES. (LIQUID TAR, BRUSHED OR SPRAYED ABOVE THE CONCRETE CONTACT LINE, HEAVY EPOXY PAINT, 8 MIL POLYETHYLENE H.D. BLACK DOUBLE LAYERED, 30 LB. ASPHALT IMPREGNATED ROOFING PAPER).

CONSTRUCTION

N.S.F. CONSTRUCTION

Project Name:
UNI-SOURCE SUPPLY/EXC
HILTON KINGSTON JAMAICA 1/71

P.O.#: P.O #:

APPLICATION:
COMBO WITH FLOOR

NOTES:

FLOOR MUST BE LEVEL SMOOTH AND CLEAR OF OBSTRUCTIONS TO ACCEPT WALK-IN PANELS. ALSO, THERE MUST BE A MINIMUM OF 2" CLEARANCE AROUND ALL SIDES OF THE WALK-IN FOR PROPER CIRCULATION.

VERIFY ALL DIMENSIONS AND SPECIFICATIONS BEFORE APPROVING DRAWINGS

Revisions:

#	Date & Description
1	Date & by Description
2	
3	

SIGNED APPROVED PRINT
MUST BE REC'D. B/4 FAB.

- ☐ APPROVED AS DRAWN
- ☐ APPROVED AS NOTED
- ☐ NOT APPROVED RESUBMIT

SIGNED

DATE:

Drawn By: CARMEN
Checked By: JANET
Scale: 1/4"= 1'-0"
CREATED: 3/3/2021

DRW No:

150687

V001

Rok Hotel Kingston
Main & Outdoor Grill
Kingston, Jamaica

TAPESTRY
COLLECTION
BY HILTON™

uni-source
SUPPLY
INTERNATIONAL INC.

2055 W 73rd Street, Miami, FL 33016
Ph:(305)826-8696 Fax:(305)826-9131

8	Updated Background from Architect with Bar Change	6-24-20
9	Updated Background from Architect with Bar Change	10-29-20
10	Moved Garde Mange, Added Chef's office, New Bev Room	3-10-21
11	Added Back in MEP Information. Final	3-18-21
No.	Revision/Issue	Date

Date

March 18, 2021

Drawn By

Dayne Gauntlett

Scale

NTS

Sheet

FF-7.0

